



LEGEND

2'x4' TROFFER FIXTURE		SUSP. ACOUSTICAL TILE	
2'x4' TROFFER FIXTURE (EMERGENCY)		GYP. RD. CEILING	
4 POINT AIRCRAFT CABLE SUSPENDED 2'x4' LIGHT FIXTURE (MOUNTED @ 12'-0" A.F.F.)		MECHANICAL VENTS (REF. MEP)	
4 POINT AIRCRAFT CABLE SUSPENDED 2'x4' LIGHT FIXTURE (MOUNTED @ 12'-0" A.F.F.) (EMERGENCY)		PART BOOTH INTAKE/EXHAUST	
RECESSED LIGHT FIXTURE		FAN/HEATER (REF. MEP)	
RECESSED WALL WASHER		WALL SOUNDC	
EXIT LIGHT/RECREATIONAL EXIT LIGHT		LED LIGHT FIXTURE AT ENTRANCE CANOPY	
WALL PACK			
LIGHT FIXTURE AT DESK BAY			

- SHEET NOTES**
1. ALL DIMENSIONS NOTED OR SHOWN ARE TAKEN FROM FACE OF STUD/GIRT UNLESS NOTED OTHERWISE.
 2. ALL FIXTURES LOCATED IN THE SHOP ARE TO BE SUSPENDED @12'-0" AFF UNLESS NOTED OTHERWISE.
 3. BIG ASS FANS ARE TO BE PROVIDED BY GC AND INSTALLED BY THE GENERAL CONTRACTOR'S ELECTRICIAN.

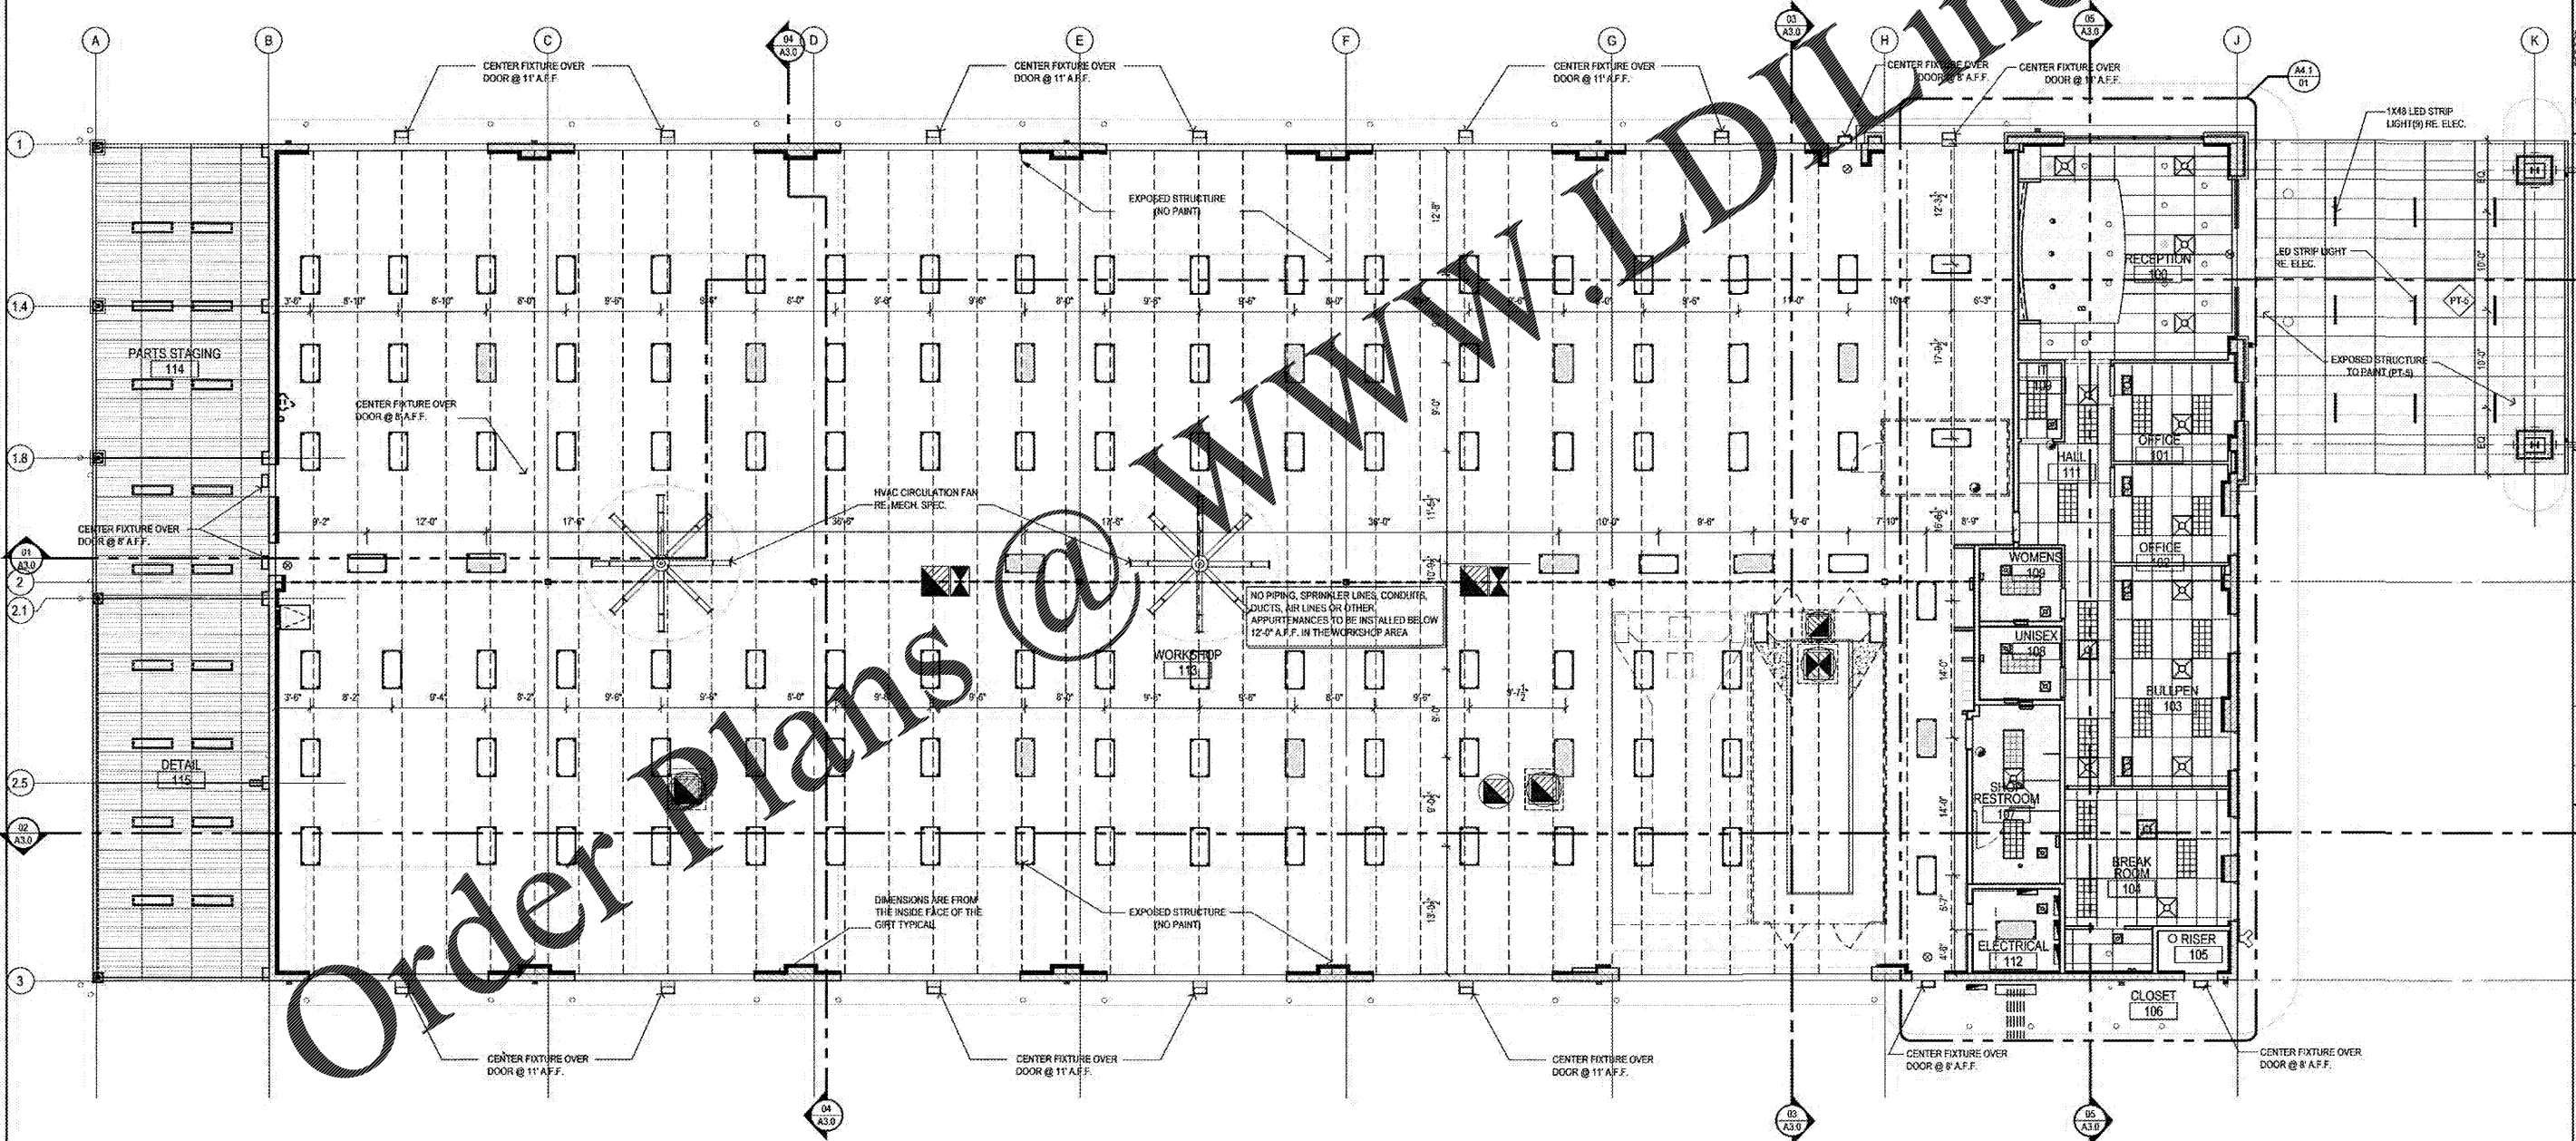

Order Plans @ WWW.LDOnline.com

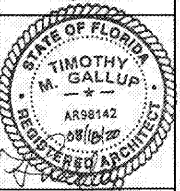

timothy m. gallup
architect of record
801 S. Boulder Ave., Suite 808
Tulsa, OK 74116
Tel: 918.493.8800

NO.	DATE	BY	DESCRIPTION	REVISIONS

REFLECTED CEILING PLAN
CALIBER COLLISION
2100 GRIFFIN RD
LAKELAND, FL
PROJECT NO. 202002

FILE NAME: 202002
DRAWN BY:
DATE: 05/19/2020
REVIEWED BY: TMG

01 REFLECTED CEILING PLAN
1/8"=1'-0"