



- SHEET NOTES**
- SOME EQUIPMENT IS NOT SHOWN FOR CLARITY
  - FIRE SPRINKLER/ALARM SYSTEM TO BE DESIGNED BY A LICENSED FIRE PROTECTION CONTRACTOR. INSTALL LATERAL LINES TO BE HELD TIGHT AGAINST THE BOTTOM OF STRUCTURE.
  - G.C. TO INSTALL FIRE EXTINGUISHERS IN THE LOCATIONS SHOWN AND APPROVED BY THE FIRE MARSHAL.
  - UNLESS NOTED OTHERWISE PROVIDE CONDUIT FOR FUTURE GATE OPERATIONS
  - CONTRACTOR TO COORDINATE THE INSTALLATION OF O.S.O.L. EQUIPMENT WITH OWNERTENANT

- KEY NOTES**
- (A14.10) WALL MOUNTED WASH/MOP SINK
  - (A14.20) WATER HEATER (REFER MEP)
  - (A14.30) PORTABLE EMERGENCY EYE WASH KIT (BY OWNER)
  - (A14.40) H/LOW WATER FOUNTAIN (REFER MEP)
  - (A14.50) LOCATION OF POWER - REF TO MEP "N" A.F.F.
  - (A14.51) POWER @ 18" BELOW STRUCTURE FOR WELDER EQUIP.
  - (A14.52) POWER AND DATA FOR FRAME RACK CONTROLLER @ 48" A.F.F.
  - (A14.53) POWER FOR HEAT LAMP @ STRUCTURE
  - (A14.60) HOSE REELS OWNER PROVIDED AND INSTALLED BY CALIBER COLLISION EQUIPMENT INSTALLER.
  - (A14.70) MILLWORK PROVIDED AND INSTALLED BY G.C.
  - (A14.80) RECESSED CONCRETE SLAB (REFER STRUCTURAL DRAWINGS FOR ADDITIONAL INFORMATION)
  - (A14.90) PAINT BOOTH TO BE PROVIDED AND INSTALLED BY CALIBER COLLISION PAINT BOOTH MANUFACTURER.
  - (A14.100) CONCRETE FILLED STEEL BOLLARD. (REF: SP1 SHEETS FOR BOLLARD INFORMATION)
  - (A14.110) OFFICE FURN. BY OWNER.
  - (A14.120) TWO POST LIFT STATION TO BE PROVIDED AND INSTALLED BY CALIBER COLLISION EQUIPMENT INSTALLER.
  - (A14.130) LOCATION OF POWER FOR PC - REF TO MEP "N" A.F.F.
  - (A14.140) TIME CLOCK STATION, OWNER PROVIDED AND INSTALLED. REFER MEP FOR POWER/DATA TO BE MOUNTED AT 42" O.C.
  - (A14.150) RECOMMENDED FIRE EXTINGUISHER LOCATION. GC TO INSTALL. VERIFY W/ FIRE MARSHAL.
  - (A14.160) FRAME RACK RE. BRSS
  - (A14.170) REFRIGERATOR FURNISHED BY CALIBER COLLISION
  - (A14.180) EMPLOYEE LOCKERS FURNISHED BY CALIBER COLLISION
  - (A14.190) STANDUP PRINTER FURNISHED BY CALIBER COLLISION
  - (A14.200) CAR-CLIMBER WALL BOARD BY CALIBER COLLISION
  - (A14.210) PAINT BOOTH CLOSURE BY PAINT BOOTH SUPPLIER
  - (A14.220) COMPRESSOR, DRYER, TANK FURNISHED AND INSTALLED BY TENANT (AIRLINES BY G.C.)
  - (A14.230) FLOOR SINK CAST IN SLAB, RE. PLUMBING PLANS
  - (A14.240) PLYWOOD PANEL AND MAST BY G.C. (RE. EMERGENCY RADIO REPEATER EQUIPMENT AND ANTENNA BY G.C.)

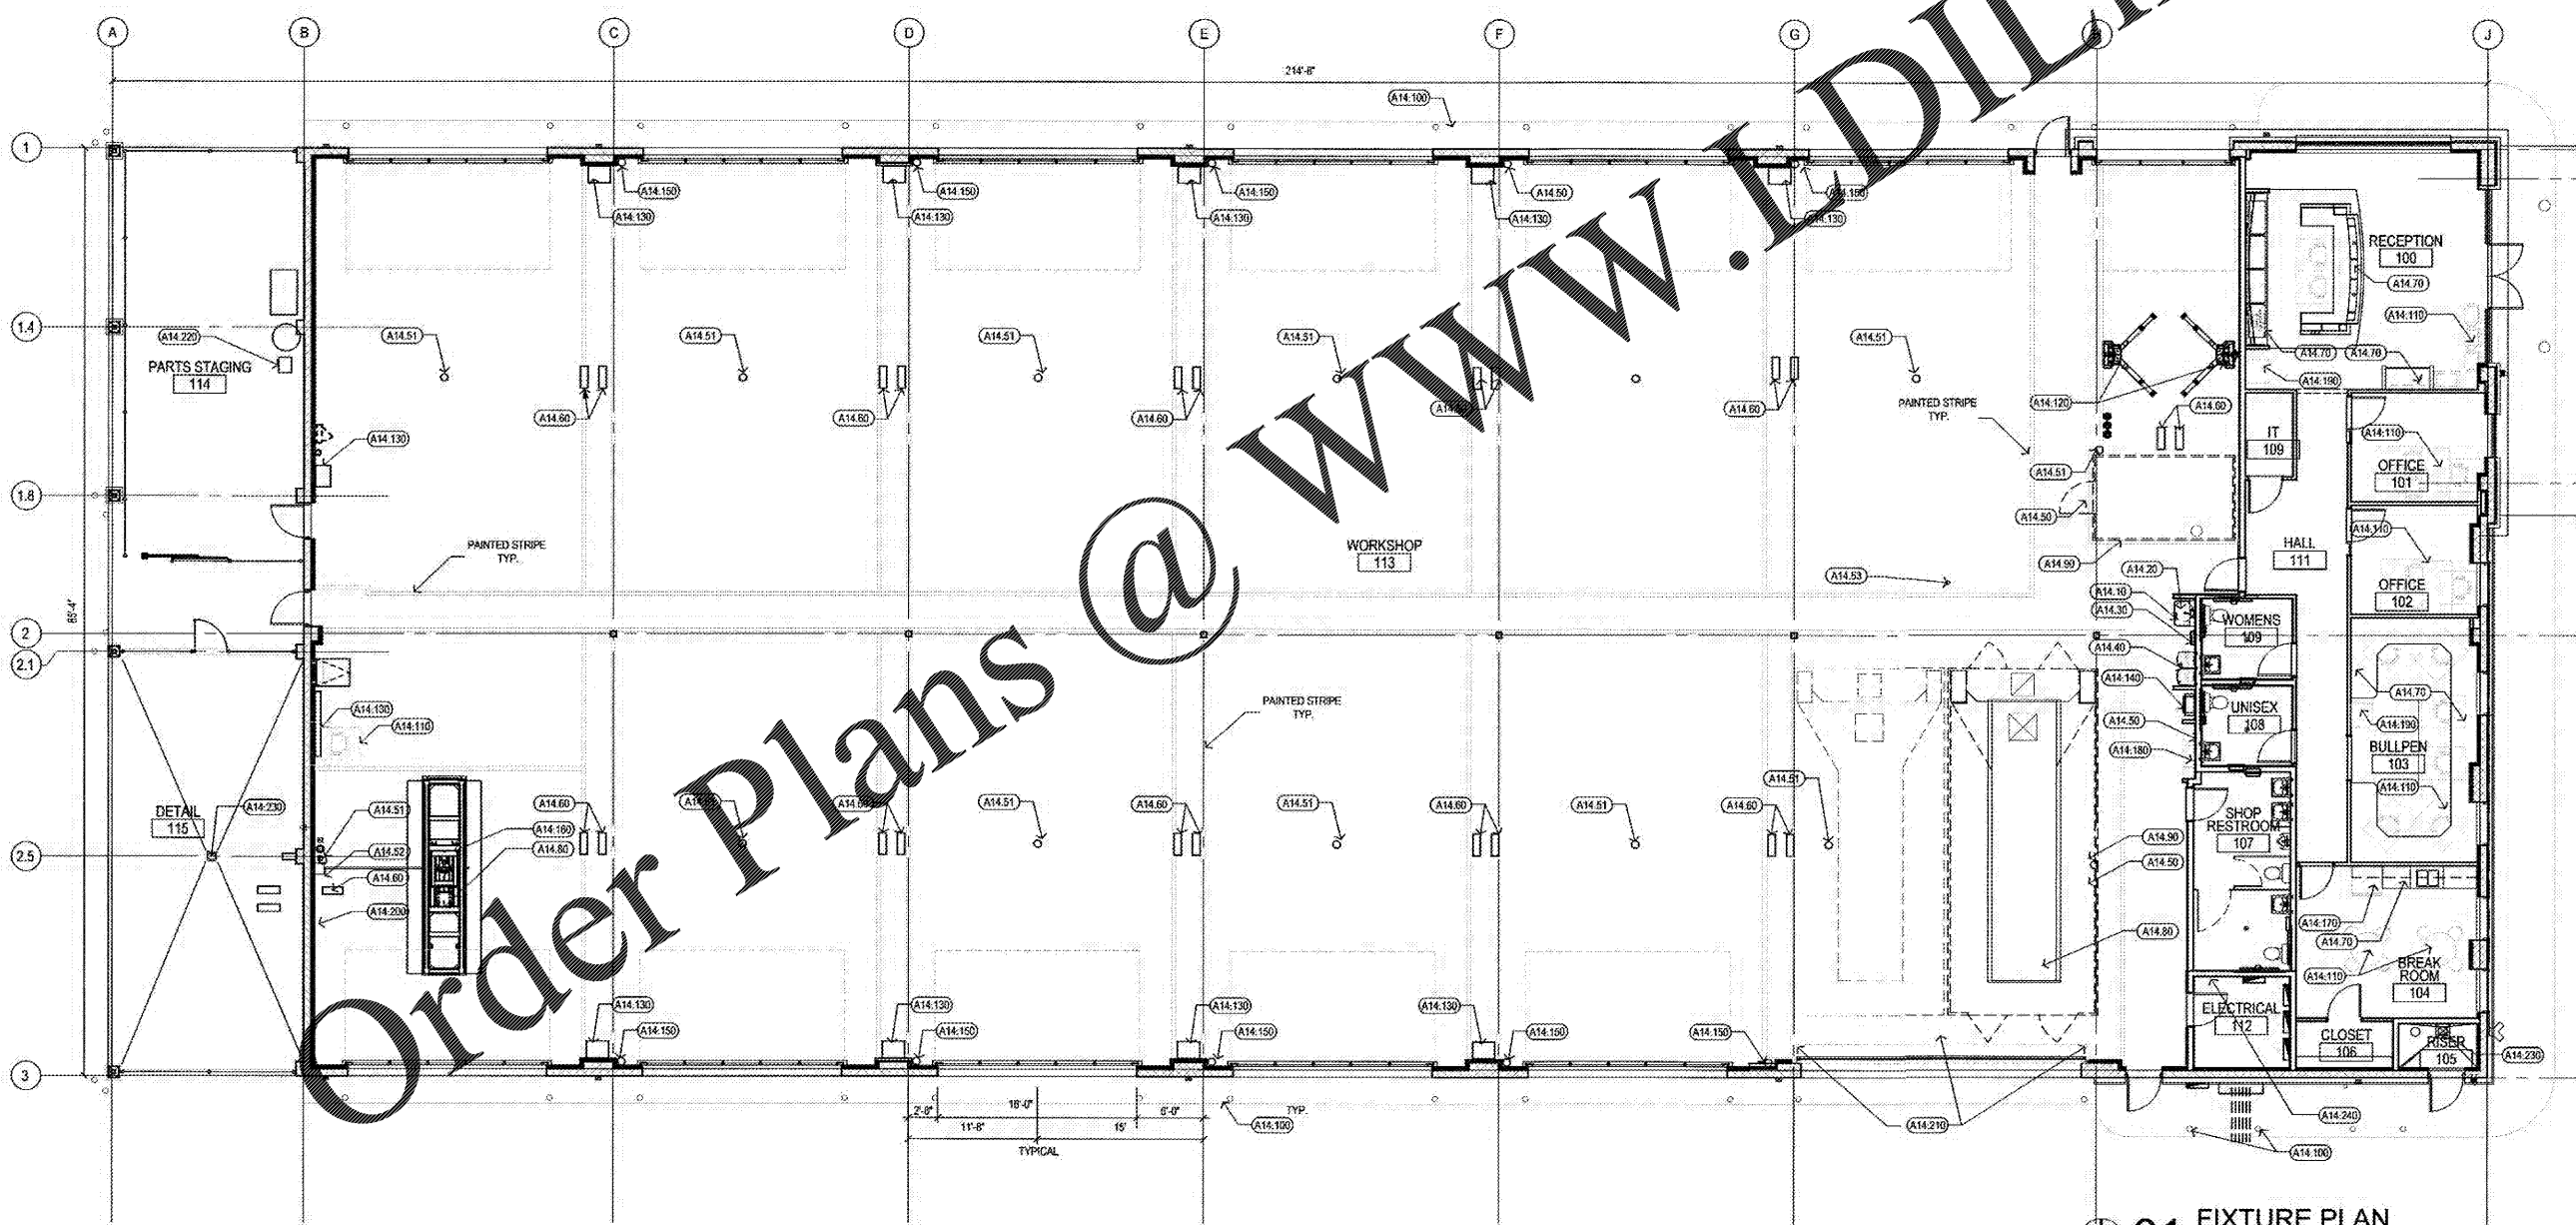

Order Plans @ WWW.DIline.com

**01 FIXTURE PLAN**  
1/8"=1'-0"

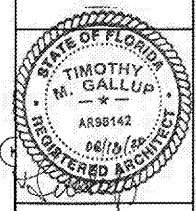

timothy m. gallup  
architect of record  
901 S. Boulder Ave., Suite 908  
Tulsa, Oklahoma 74118  
918.498.8800

NO.	DATE	BY	DESCRIPTION	REVISIONS

**FIXTURE PLAN**  
CALIBER COLLISION  
2100 GRIFFIN RD  
LAKELAND, FL  
PROJECT NO. 202002

FILE NAME: 202002  
DRAWN BY:  
DATE: 06/19/2020  
REVIEWED BY: TMG