



timothy m. gallup
architect of record

601 S. Boulder Ave., Suite 808
Tulsa, OK 74106
Phone: 918.948.9900

NO.	DATE	BY	DESCRIPTION

ENLARGED FLOOR PLANS
CALIBER COLLISION
2100 GRIFFIN RD.
LAKELAND, FL
PROJECT NO. 202002

FILE NAME: 202002
DRAWN BY:
DATE: 08/18/2020
REVIEWED BY: TMG

A4.0

LEGEND


	NEW STUD WALL PER PARTITION KEY
	NEW STUD WALL TO DECK PER PARTITION KEY
	HALF WALL PER PARTITION KEY
	PARTITION KEY, REFER TO PARTITION DETAIL SHEET

SHEET NOTES


- ALL DIMENSIONS NOTED OR SHOWN ARE TAKEN FROM FACE OF STUDY CMU OR GRT UNLESS NOTED OTHERWISE.
- ALL DOORS LOCATED 4" OFF ADJACENT WALL AT HINGE SIDE UNLS.
- FIRE SPRINKLER ALARM SYSTEM TO BE DESIGNED BY LICENSED FIRE PROTECTION CONTRACTOR. INSTALL LATERAL LINES TIGHT AGAINST BOTTOM OF STRUCTURE WITH MIN. SLOPE.
- GC TO INSTALL FIRE EXTINGUISHERS PER FIRE MARSHALS RECOMMENDATIONS. PROVIDE 50 MAX TRAVEL DISTANCE 15 TO 20'.
FLOOR DRAINS ARE TO BE FLUSH WITH FINISH FLOOR.

KEY NOTES


A4.10 WALL MOUNTED WASHMOP SINK REFER TO SHEET A4.2	A4.80 FLOOR SINK (REF. MEP)	A4.120 RECEPTION MILLWORK, REFER TO SHEET A4.3
A4.20 WATER HEATER (REF. MEP) REFER TO SHEET A4.2	A4.70 WALL SHELVING 07/A4.2	A4.130 UPPER AND LOWER CABINETS W/ SINK, REFER TO SHEET, RE. A4.4.2
A4.30 EMERGENCY EYE WASH STATION (PORTABLE BY CLIENT)	A4.80 KNEE WALL WITH GRANITE CAP REF.	A4.140 COUNTER TOP REFER TO SHEET S4.4.3
A4.40 HIGH-LOW DRINKING FOUNTAIN (REF. MEP)	A4.90 KNOX BOX. VERIFY WITH FIRE MARSHAL. RE. SPEC.	A4.150 COFFEE BAR, REFER TO SHEET L3/A4.3
A4.50 FLOOR DRAIN (REF. MEP)	A4.100 PROVIDE BLSG. @80° AND 92° FOR TV BRACKET ARV. COFFEE BAR	A4.160 FIRE RISER PER PLUMBING PLANS
	A4.110 PROVIDE 3/32" TS FOR VERT. SUPPORT. ANCHOR TO SLAB.	A4.170 F.D.C PER PLUMBING PLANS
		A4.180 REF. MILLWORK TO S4/A.3

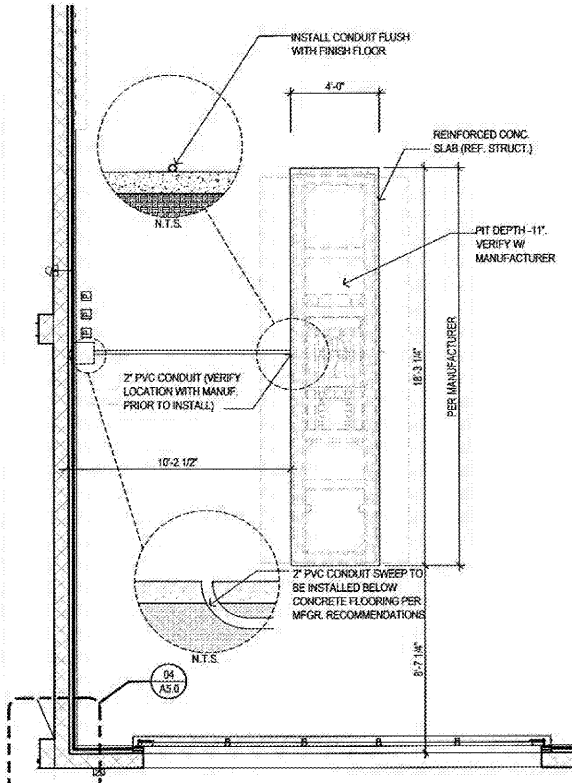

04 PLAN DETAIL (FRAME RACK PIT)
1/4"=1'-0"

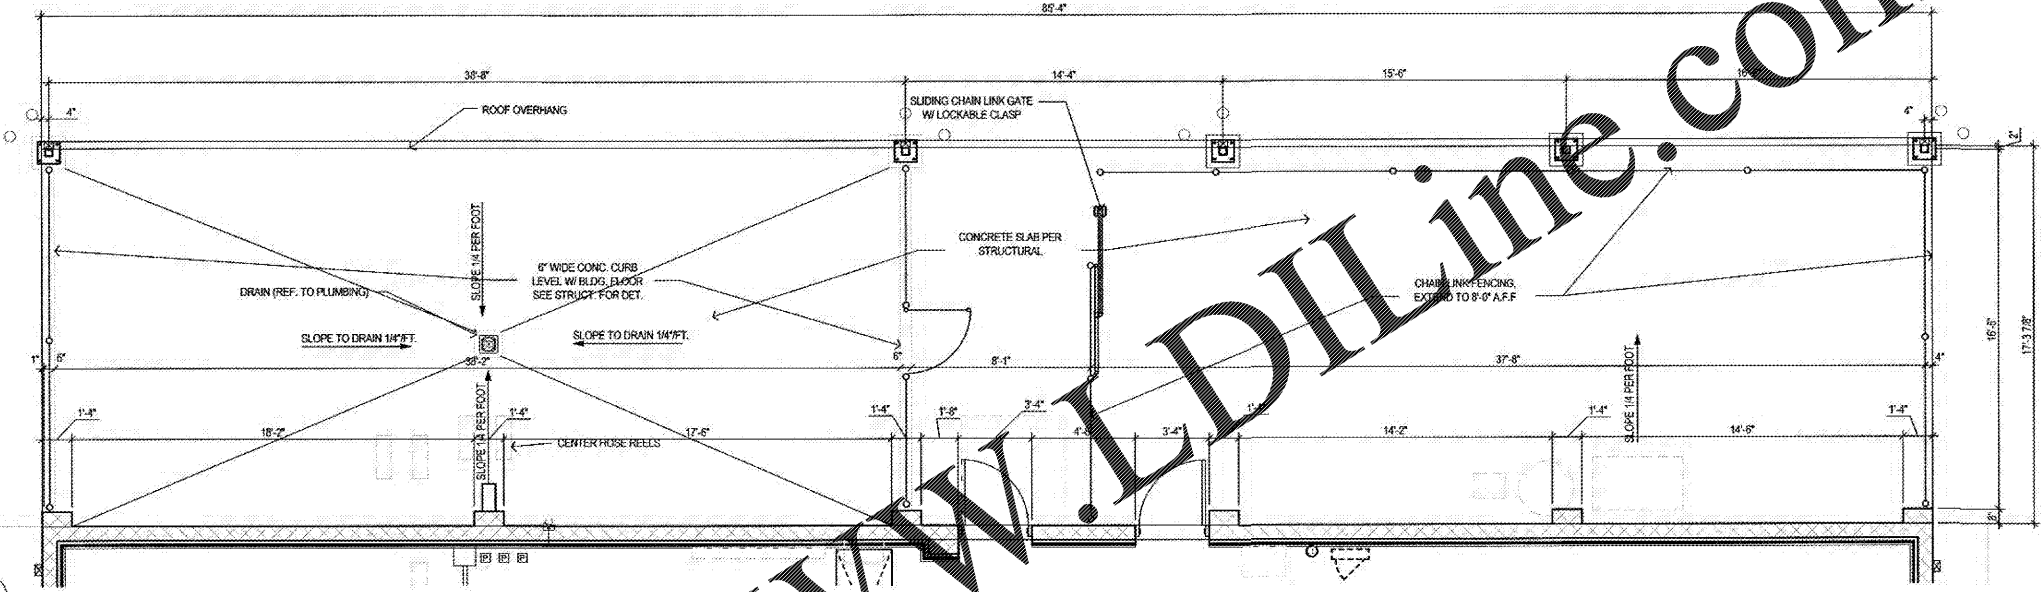

02 PLAN DETAIL (DETAIL & PARTS STAGING)
1/4"=1'-0"

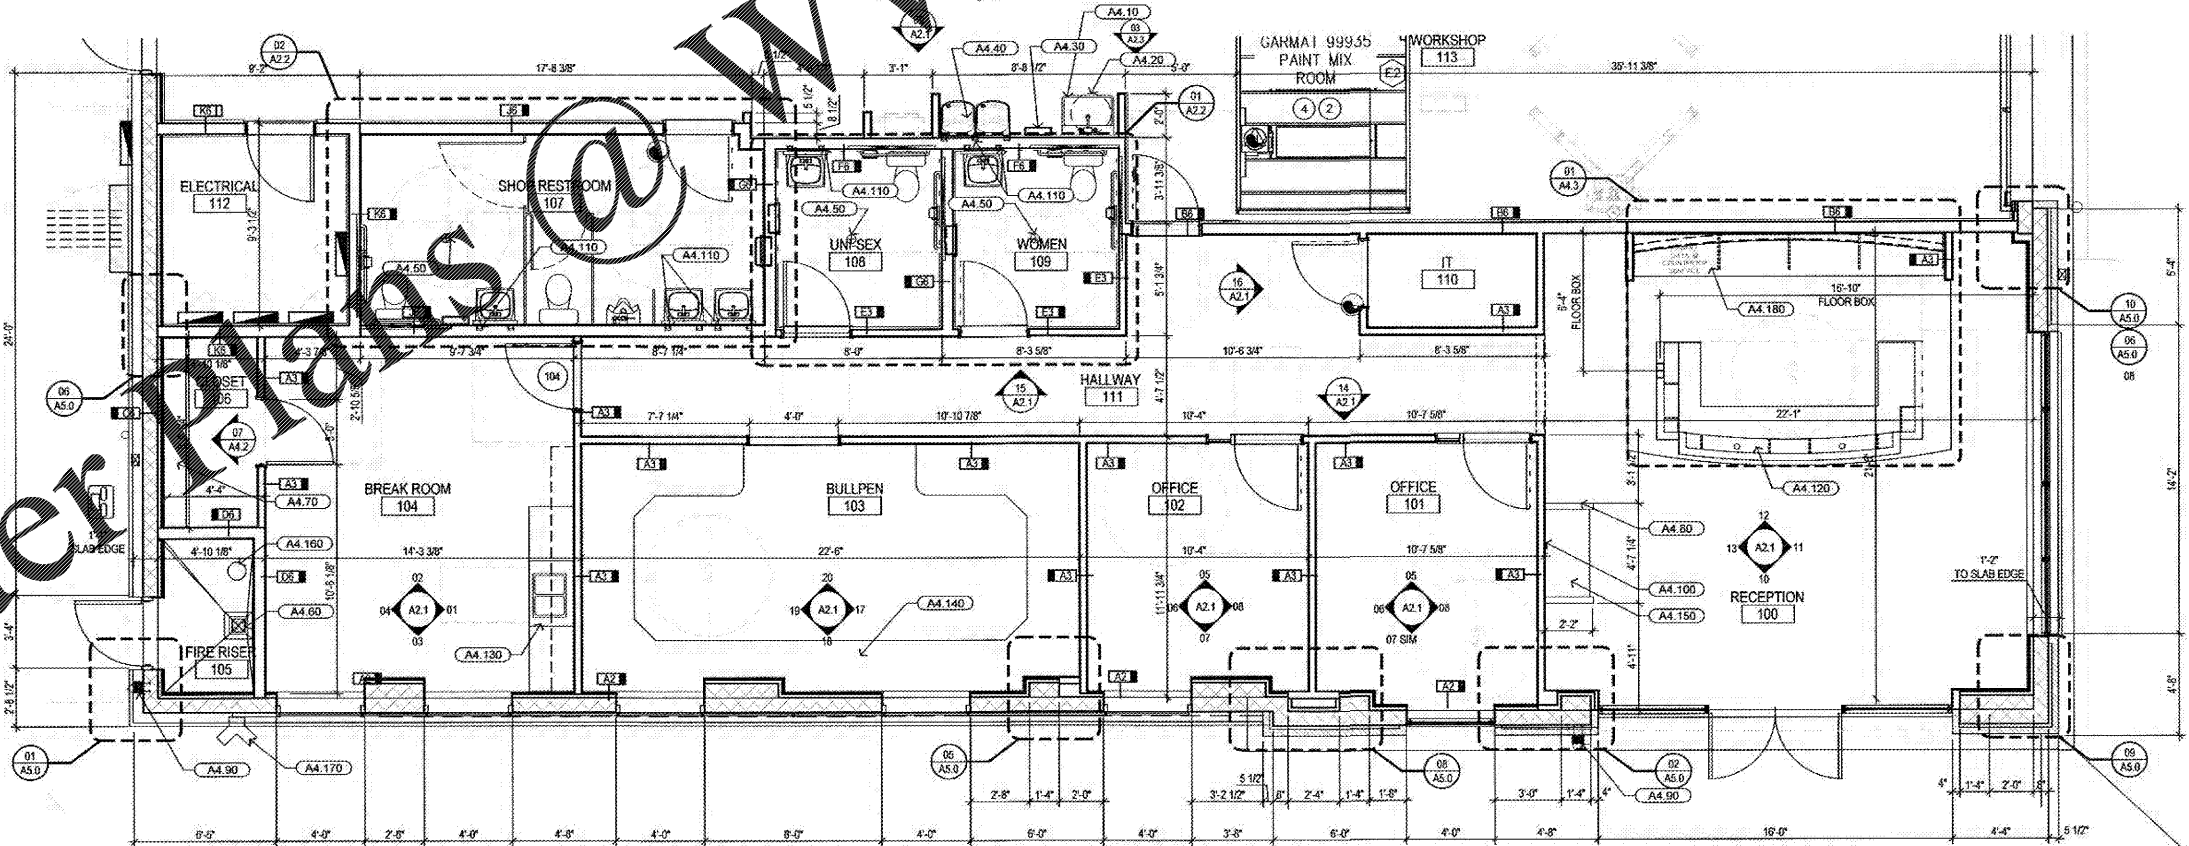

01 ENLARGED FLOOR PLAN
1/4"=1'-0"

Order Plans @ www.DIline.com