


PLUMBING NOTES BY SYMBOL " " ○

1. DOMESTIC SANITARY UTILITY CONNECTION LOCATION. REFERENCE CIVIL FOR CONTINUATION.
2. 3" VENT FROM SAMPLE WELL & SAND/OIL INTERCEPTOR FROM BELOW GRADE UP THROUGH WALL TO VTR. REFERENCE SHEET P2.1 FOR CONTINUATION ABOVE SLAB.
3. NEW 8" FIRE WATER MAIN FROM CITY. REFERENCE CIVIL FOR CONNECTION POINT. PROVIDE WATER CONNECTION FROM 5' OUTSIDE BUILDING INTO FIRE RISER CLOSET. REFERENCE SHEET 01/FO.3 FIRE RISER DETAIL.
4. NEW 2" - 2 PSI GAS LINE DOWN FROM METER TO BELOW GRADE. CONTRACTOR SHALL REFERENCE CIVIL AND SHEET P2.1 FOR CONTINUATION.
5. NEW 1-1/2" DOMESTIC WATER IN FROM CITY MAIN. REFERENCE COORDINATE WITH CIVIL ON FINAL LOCATION. ROUTE FROM 5' OUTSIDE OF BUILDING INTO FIRE RISER ROOM AND UP THROUGH SLAB INTO FIRE RISER ROOM. REFERENCE P2.1 FOR ABOVE SLAB CONTINUATION.
6. CONTRACTOR IS TO PROVIDE GREY WATER TRAP PRIMER FROM TAIL PIECE OF LAVS TO FLOOR DRAIN. REFERENCE SHEET P0.205 FOR DETAILS.
7. OIL/SAND TRAP FINAL LOCATION IS TO BE COORDINATED WITH ARCHITECT/OWNER PRIOR TO CONSTRUCTION. REFERENCE SHEET P0.305.
8. ELECTRONIC TRAP PRIMER IN WALL. CONTRACTOR IS TO CONNECT FLOOR DRAIN AND FLOOR SINK TO TRAP PRIMER AS REQUIRED. CONNECT WATER LINE UP IN WALL. PROVIDE ACCESS PANEL. REFERENCE SHEET P2.1 FOR CONTINUATION TO ABOVE SLAB PLAN. REFERENCE SHEET P0.101 FOR DETAILS.
9. UTILITY CONNECTION LOCATION. REFERENCE CIVIL FOR CONTINUATION.
10. 4" FDC UNDERGROUND CONNECTION LINE. CONNECT TO FIRE RISER MAIN. REFER TO CIVIL UTILITY PLAN FOR FINAL LOCATION.

THIS ITEM HAS BEEN DIGITALLY SIGNED AND SEALED BY DUSTIN M. VOGT, PE ON 08-19-2020 USING A DIGITAL SIGNATURE. PRINTED COPIES ARE NOT CONSIDERED SIGNED AND SEALED AND THE SIGNATURE MUST BE VERIFIED ON ANY ELECTRONIC COPIES.

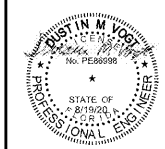


timothy m. gallup
architect of record
601 S. Boulder Ave., Suite 808
Tulsa, Oklahoma 74119
918.949.9600

NO.	DATE	BY	DESCRIPTION
2	2007/02	OLS	PR NO. 1
1	2006/13	OLS	ADDENDUM NO. 1

PLUMBING UNDER FLOOR PLAN
CALIBER COLLISION
2300 GEFREN RD
LAKELAND, FL
PROJECT NO. 23202

FILE NAME: 192006
DRAWN BY: BPH
DATE: 08/19/2020
REVIEWED BY: MS

P2.0

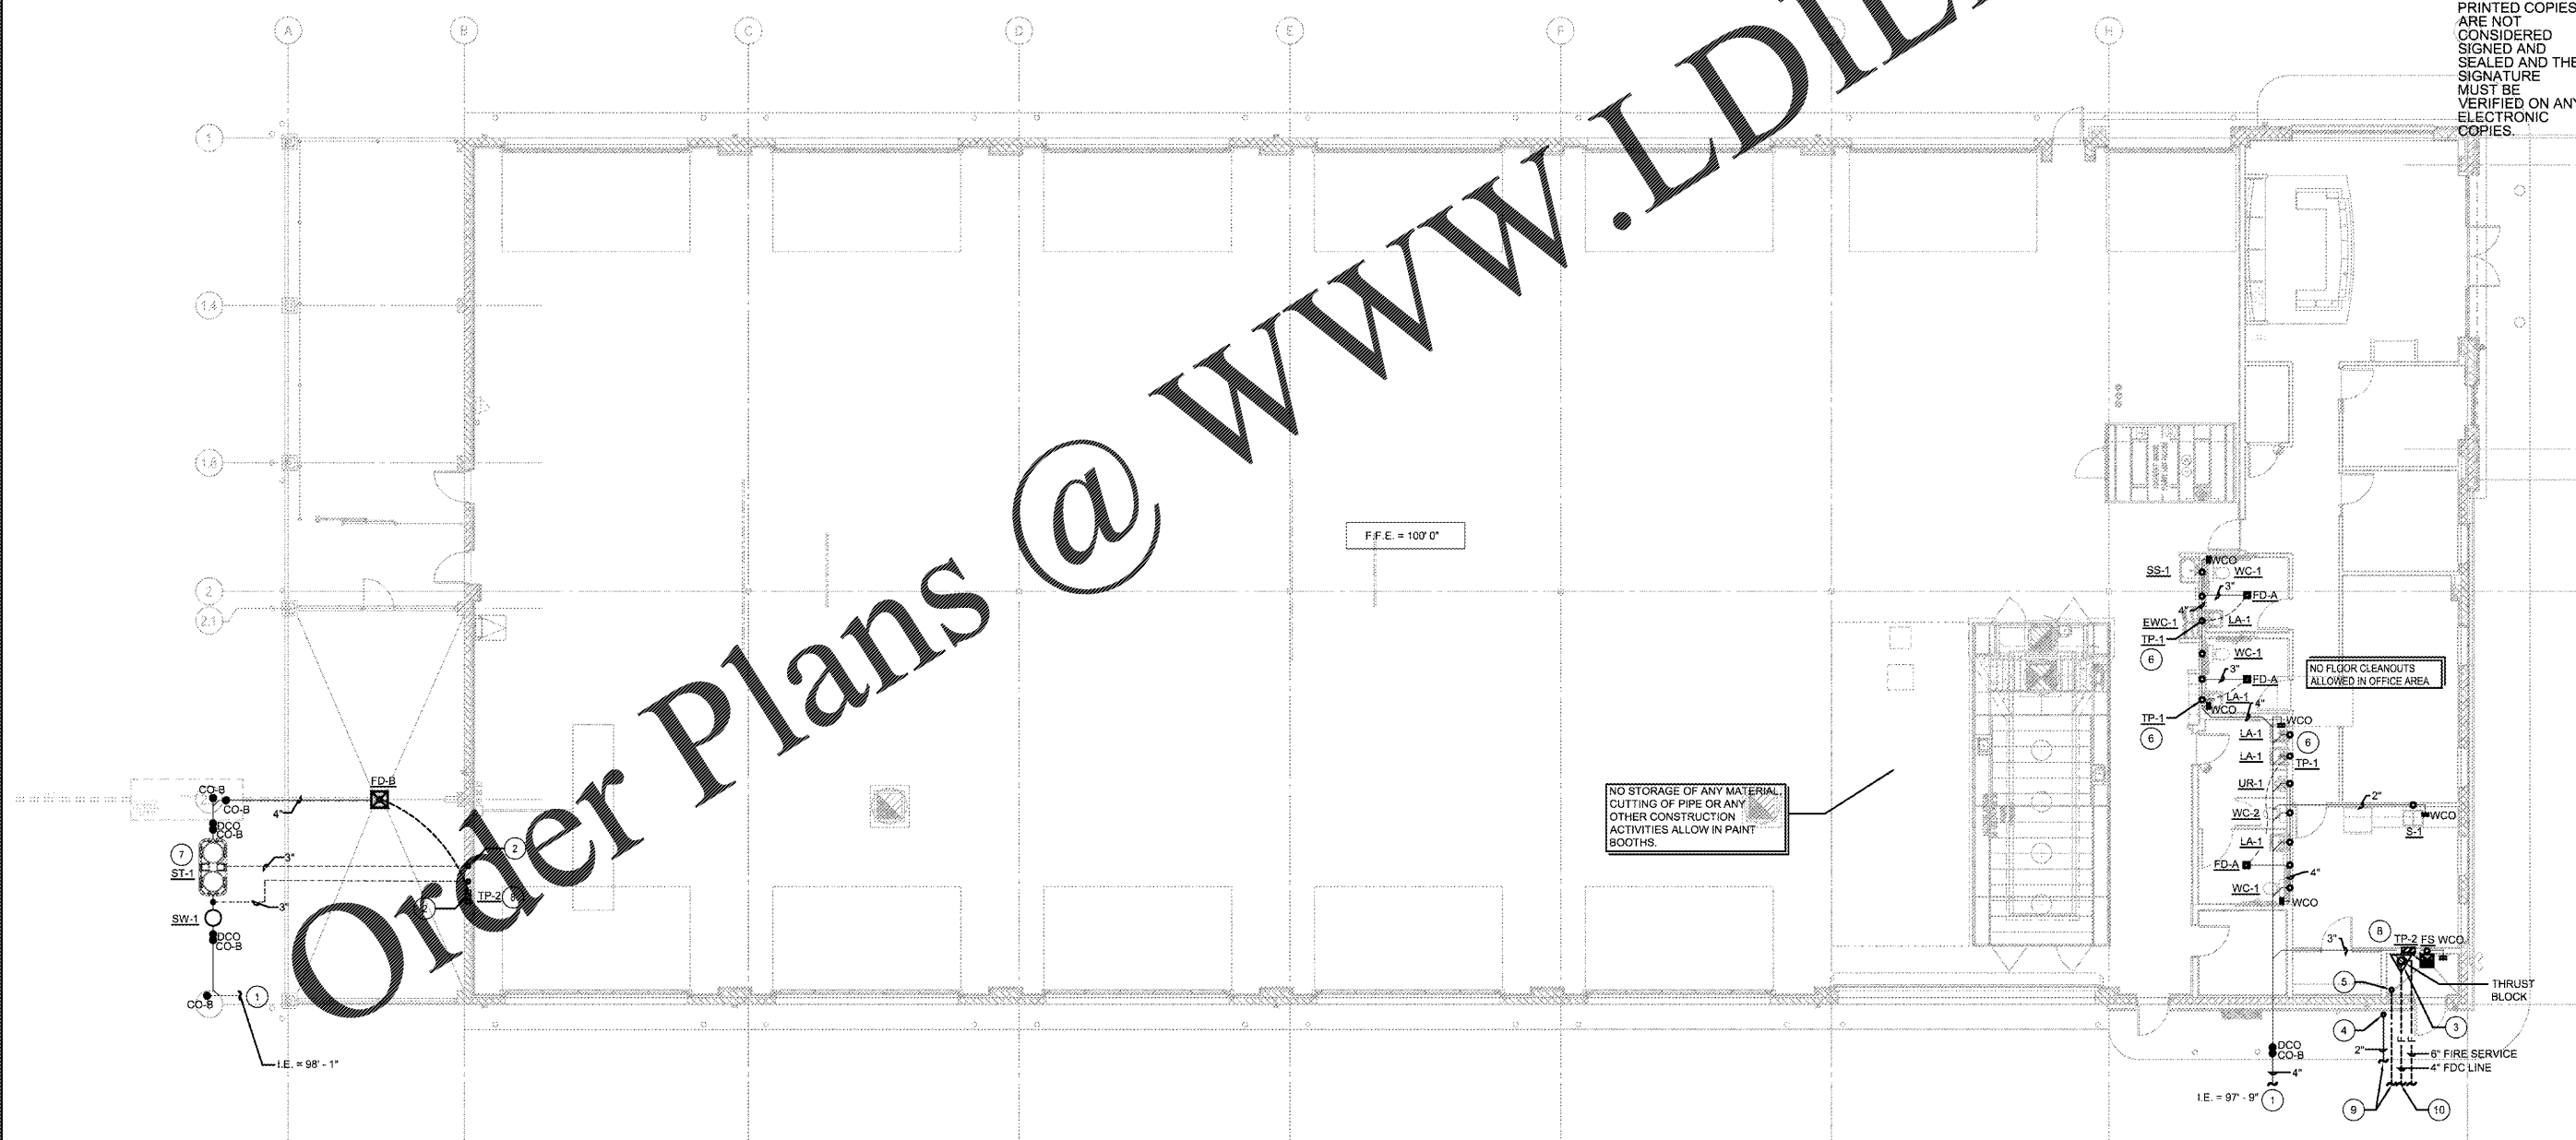

01 UNDER FLOOR PLAN - PLUMBING
SCALE: 1/8" = 1'-0"

Order Plans @ www.LDILine.com