


LOCATION SKETCH



VICINITY SKETCH

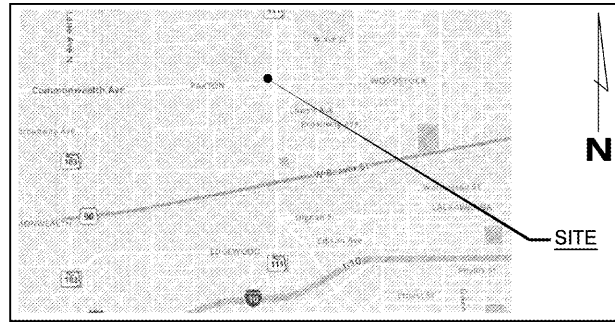

**PETROLEUM STORAGE AND DISTRIBUTION
SYSTEM CONSTRUCTION PLANS**

Wawa #5351


1004 N. Edgewood Ave. & Commonwealth (N.W. Corner)
Jacksonville, Duval County, FL

APPLICANT:
WAWA, INC
7022 TPC DR., SUITE 200
ORLANDO, FL 32822
(407) 718-9607
CONTACT: Ryan Keidel, P.E.
EMAIL: ryan.keidel@wawa.com

PETROLEUM ENGINEER:
STILLWATER TECHNOLOGIES, INC.
1700 N. ORANGE AVE., SUITE 100A
ORLANDO, FL 32804
(407) 206-7222; FAX (407) 206-7223
CONTACT: Rick Blecha, P.E.
EMAIL: rblecha@stillwatertech.com

CODE REFERENCES:

- NFPA 30 (2018) - FLAMMABLE & COMBUSTIBLE LIQUIDS
- NFPA 30A (2018) - MOTOR FUEL DISPENSING FACILITIES
- PEI/RP 100-17 - RECOMMENDED PRACTICES FOR INSTALLATION OF UNDERGROUND LIQUID STORAGE SYSTEMS
- NFPA 70, N.E.C. 2017
- FLORIDA BUILDING CODE (FBC) 2017 (6th Edition)
- FLORIDA FIRE PREVENTION CODE - 6th Edition

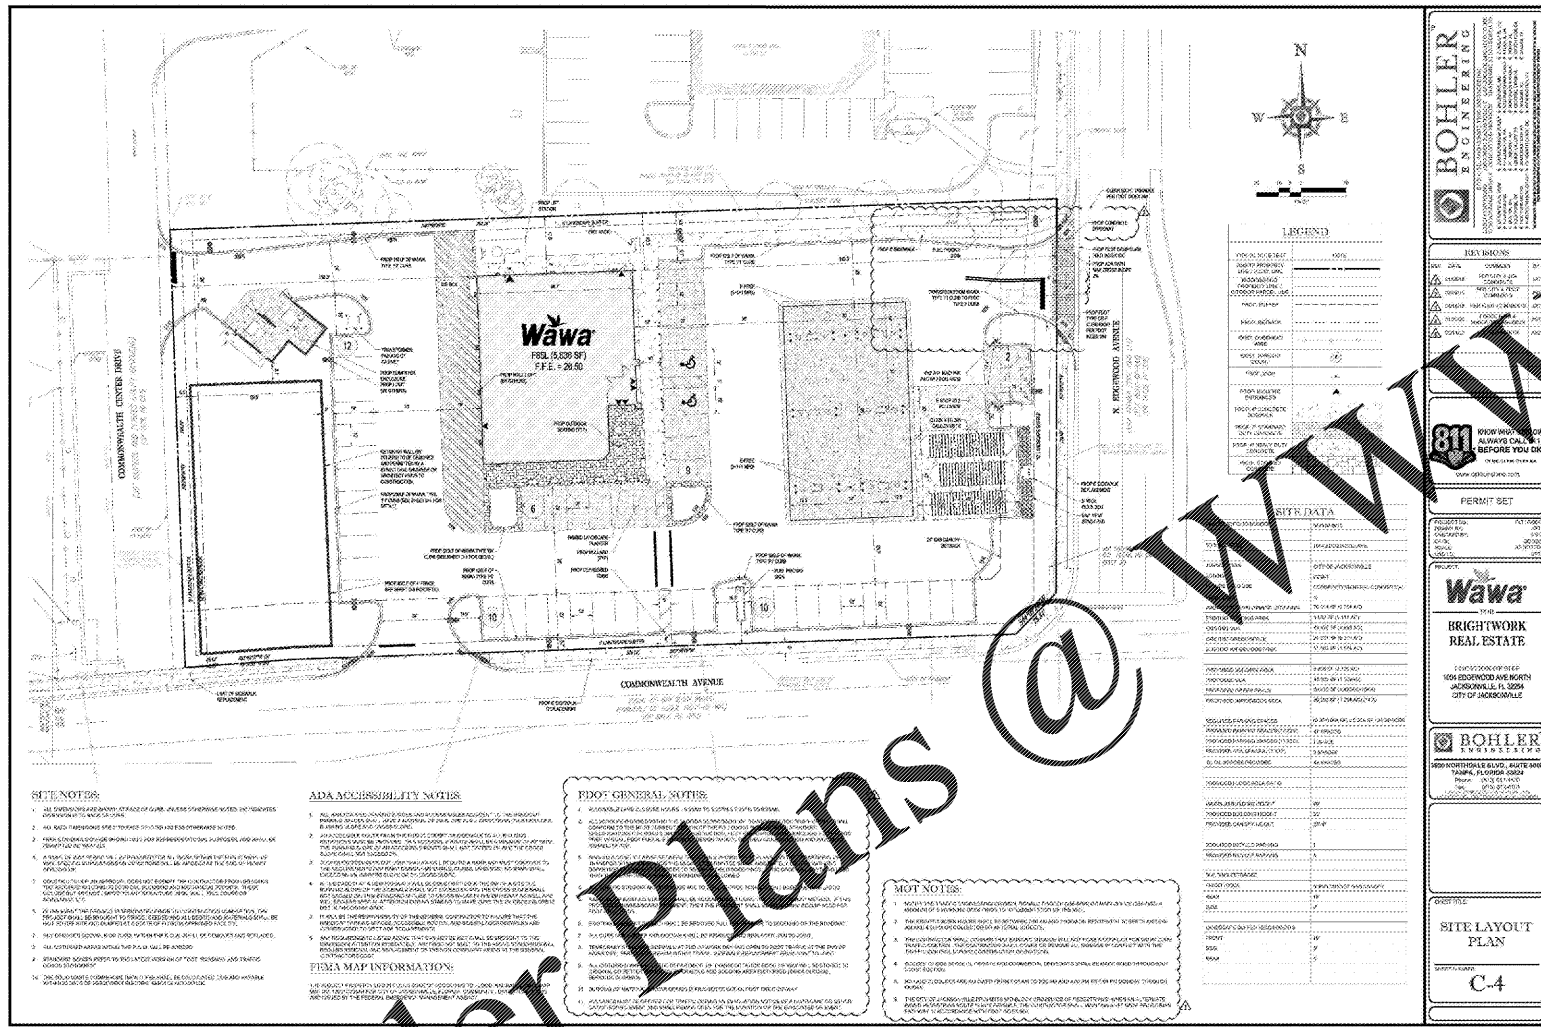

RE #: 048980-0010

CIVIL SITE PLAN
N.T.S.
(FOR REFERENCE ONLY)

Order Plans @


BOHLER ENGINEERING
311
PERMIT SET
Wawa
BRIGHTWORK REAL ESTATE
BOHLER
SITE LAYOUT PLAN
C-4

FLORIDA GAS DRAWINGS					
PAGE	DESCRIPTION	DATE	REV. DATE	REV. DATE	REV. DATE
6-0	COVER SHEET (1-20,000 GAL. TANK W/ 2-22,000 GAL. COMPARTMENTALIZED TANKS)	09/08/14	07/31/19	03/01/20	09/15/20
6-1	FLORIDA TANK DETAILS (1-20,000 GAL. TANK W/ 2-22,000 GAL. COMPARTMENTALIZED TANKS)	09/08/14	07/31/19	03/01/20	
6-2	FLORIDA TANK DETAILS (1-20,000 GAL. TANK W/ 2-22,000 GAL. COMPARTMENTALIZED TANKS)	09/08/14	07/31/19	03/01/20	
6-3	FLORIDA GASOLINE DETAILS STACKED 6 DISPENSER LAYOUT	09/08/14	07/31/19	03/01/20	09/15/20
6-4	FLORIDA GAS/DIESEL SUMP DETAILS	09/08/14	07/31/19	03/01/20	
6-5	FLORIDA GENERAL NOTES & LEGEND (1-20,000 GAL. TANK W/ 2-22,000 GAL. COMPARTMENTALIZED TANKS)	09/08/14	07/31/19	03/01/20	
6-6	FLORIDA CONCRETE DETAILS STACKED 6	08/08/18	07/31/19		



EQUIPMENT DESCRIPTION	F.D.E.P. EQ#S	MANUFACTURER / MODEL	EQ#
1. DOUBLE-WALLED UNDERGROUND STORAGE TANKS		XERXES DWT-III	200
2. DOUBLE-WALLED PRODUCT PIPE		APT XP	618
3. VENT PIPING		NOV DUALOY 8000	291
4. DISPENSER SUMPS		APT LHM-8617-96	423
5. STP SUMPS - SINGLE WALL FIBERGLASS		PETROLEUM CONTAINMENT INC. PC4550J-S-C2	209
6. DOUBLE-WALLED SPILL BUCKETS		OPM EDGE IC-812D (FILL); IC-812P (VAPOR)	108
7. MECHANICAL LINE LEAK DETECTOR		FE PETRO STP-MLD-S, STP-MLD-D	995
8. OVERFILL PROTECTION SYSTEM		OPM TISO-410-C	641
9. LEAK DETECTION CONSOLE		FRANKLIN FUELING SYSTEMS TS-550 EVO	652
10. DISCRIMINATING TANK SUMP LEAK SENSOR		FRANKLIN FUELING SYSTEMS FMP-DTS	652
11. DISCRIMINATING DISPENSER SUMP LEAK SENSOR		FRANKLIN FUELING SYSTEMS FMP-DDS	652
12. TANK LEVEL INVENTORY MONITORING PROBE		FRANKLIN FUELING SYSTEMS FMP-LLS-151	652
13. TANK INTERSTITIAL LEAK SENSOR		FRANKLIN FUELING SYSTEMS FMP-HIS-XL	652

stillwater TECHNOLOGIES
1700 N. Orange Ave.
Suite 100A
Orlando, Florida 32804
(407) 206-7222
(407) 206-7223 fax
FL. Cert. of Auth. #8326
STILLWATER PROJECT #464-184

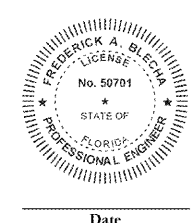

COVER SHEET			
WAWA - 1004 N. EDGEWOOD AVE. & COMMONWEALTH (N.W. CORNER) JACKSONVILLE, DUVAL COUNTY, FL (1)-20,000 GAL. TANK W/ (2)-22,000 GAL. COMPARTMENTALIZED TANKS			
SCALE	DATE	DRAWN BY:	CHECKED BY:
AS NOTED	03/01/20	STILLWATER	FAB

Wawa
7022 TPC DR., SUITE 200
ORLANDO, FL 32822
TEL: (407) 718-9607 FAX: (407) 206-7223

G-0
DRAWING NO.
1 OF 7
SHEET NO.