


Order Plans @

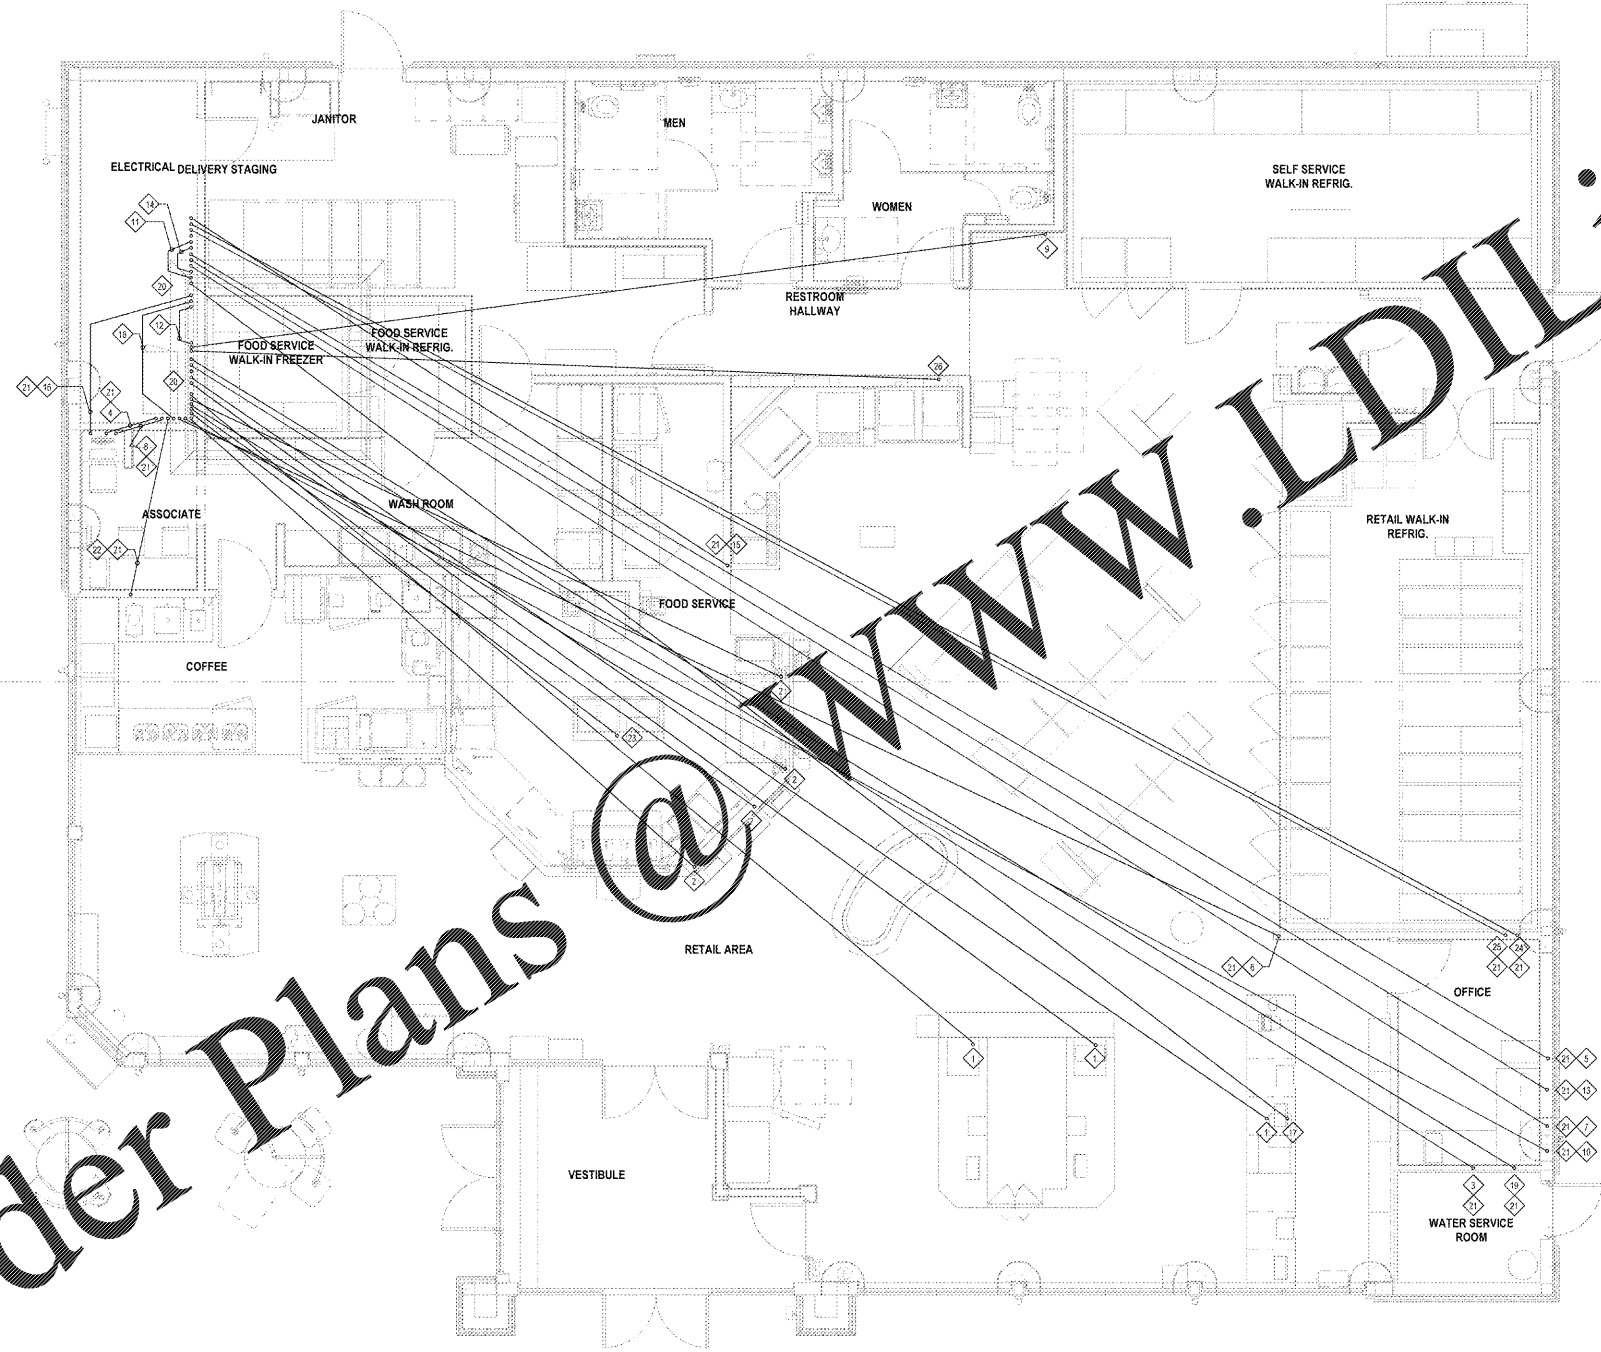

GENERAL NOTES

1. THE INTENT OF THIS SHEET IS TO SHOW ROUTING OF SOME LOW VOLTAGE CONDUCTORS AND DEFINE ASSOCIATED TERMINATIONS. SEE OTHER ELECTRICAL FLOOR PLAN SHEETS FOR MORE INFORMATION ON RELATED DEVICES AND CONDUIT RUNS.
2. CABLES 1-8 TO TERMINATE IN 12 PORT PATCH PANEL.
3. CABLES 9-11 AND 13 TO TERMINATE IN BLUE RJ45 PLATE.
4. CABLES 14 AND 15 TO TERMINATE IN WHITE RJ45 PLATE.
5. CABLES 12 AND 16-17 TO TERMINATE IN ORANGE RJ45 PLATE.
6. CABLES 18-21 TO TERMINATE IN YELLOW RJ45 PLATE.
7. CABLE 22 TO TERMINATE IN WHITE RJ45 PLATE.
8. CABLE 23 TO TERMINATE IN RED RJ45 PLATE.
9. DATA CABINET IS 24 PORT PATCH PANEL #1, 2 AND 3. CHECK-OUT AND FOOD SERVICE IS 12 PORT PATCH PANEL.

PLAN NOTES

1. ROUTE ONE (1) 28 PAIR CABLE FROM DATA CABINET TO OFFICE AREA (1) OF 3. (CABLES #1-3)
2. ROUTE ONE (1) 24 PAIR CABLE FROM DATA CABINET TO JELLY AREA (1) OF 4. (CABLES #5-8)
3. ROUTE ONE (1) 4 PAIR BLUE OR GRAY CABLE FROM DATA CABINET TO OFFICE WALL TYP. OF 2. (CABLES #9-10 AND #11-12)
4. ROUTE ONE (1) 4 PAIR BLUE OR GRAY CABLE FROM DATA CABINET TO ASSOCIATE AREA (CABLE #13)
5. ROUTE ONE (1) 4 PAIR BLUE OR GRAY CABLE FROM DATA CABINET TO FRONTIER AREA (CABLE #14)
6. ROUTE ONE (1) 4 PAIR BLUE OR GRAY CABLE FROM DATA CABINET TO TIME CLOCK (CABLE #15)
7. ROUTE ONE (1) 4 PAIR WHITE CABLE FROM DATA CABINET TO DVR IN OFFICE AREA (CABLE #16)
8. ROUTE ONE (1) 4 PAIR BLUE OR GRAY CABLE FROM DATA CABINET TO SCIT IN ASSOCIATE AREA (CABLE #17)
9. ROUTE ONE (1) 4 PAIR ORANGE CABLE FROM DATA CABINET TO ATM AREA (CABLE #18)
10. ROUTE CAT5 CABLE FROM DATA CABINET TO ABOVE DESK IN MANAGER'S OFFICE.
11. ROUTE ONE (1) 4 PAIR YELLOW CABLE FROM ALLIED BOX TO FUEL TANK MONITOR DATA BOX. (CABLE #19)
12. ROUTE TWO (2) 4 PAIR YELLOW CABLE FROM ALLIED BOX TO GAS PATCH PANEL AT SERVER RACK TYP. OF 8. (CABLES #20-27)
13. ROUTE ONE (1) 4 PAIR BLUE OR GRAY PHONE CABLE FROM BROM TO PRINTER (CABLE #28)
14. ROUTE ONE (1) 4 PAIR BLUE OR GRAY TELEPHONE CABLE FROM BROM TO FUEL TANK EQUIPMENT (CABLE #30)
15. ROUTE ONE (1) 4 PAIR BLUE OR GRAY TELEPHONE CABLE FROM BROM TO FOOD SERVICE TYP. OF 2. (CABLES #31-32)
16. ROUTE ONE (1) 4 PAIR BLUE OR GRAY TELEPHONE CABLE FROM BROM TO ASSOCIATE AREA (CABLE #33)
17. ROUTE ONE (1) 4 PAIR BLUE OR GRAY TELEPHONE CABLE FROM BROM TO CHECKOUT AREA (CABLES #34-35)
18. ROUTE ONE (1) 4 PAIR BLUE OR GRAY TELEPHONE CABLE FROM BROM TO DATA CABINET (CABLE #36)
19. ROUTE ONE (1) 4 PAIR BLUE OR GRAY CABLE FROM BROM TO OFFICE (CABLE #37)
20. CABLE ARRANGEMENT AT SYSTEMS AREA AND DATA RACK IS DIAGRAMMATIC ONLY. ROUTE CABLES NEATLY INTO EQUIPMENT USING CONDUIT FISHERS INTO CEILING SPACE ABOVE.
21. PROVIDE OUTLET BOX AND CONDUIT TO ACCESSIBLE ABOVE CEILING SPACE PRIOR TO DRYWALL AND CEILING INSTALLATION.
22. ROUTE ONE (1) VGA TRIPLE SHIELDED AND ONE (1) CAT5 FROM MEDIA PLAYER AT DATA RACK TO DIGITAL MONITOR.
23. ROUTE THREE (3) VGA TRIPLE SHIELDED AND THREE (3) CAT5 FROM MEDIA PLAYER AT DATA RACK TO DIGITAL MONITORS, THREE SCREENS AT THIS LOCATION.
24. ROUTE ONE (1) 4 PAIR YELLOW CABLE FROM ALLIED BOX TO FUEL TANK MONITOR DATA BOX.
25. ROUTE ONE (1) 4 PAIR BLUE OR GRAY TELEPHONE CABLE FROM PHONE DEMO BOX TO FUEL TANK EQUIPMENT.
26. ROUTE TWO (2) CAT5 FROM DATA CABINET TO FREESTYLE.

WIRELESS NETWORK :

- A. (1) ORANGE CABLE FROM DATA CABINET TO CEILING IN FRONT OF FOOD SERVICES.
- B. (1) ORANGE CABLE FROM DATA CABINET TO CEILING IN CENTER CS
- C. (2) ORANGE CABLES FROM DATA CABINET TO RETAIL WALK-IN AND SELF SERV WALK-IN
- D. (2) ORANGE CABLES FROM DATA CABINET TO EACH TOWER WALL.

1 LOW VOLTAGE PLAN
E10 1/4" = 1'-0"

1925 Prospect Ave.
Orlando, FL 32814
P (407) 661-9100
F (407) 661-9101
www.ep.com



CLIENT NAME
WAWA
280 WEST BALTIMORE PIKE
WAWA, PENNSYLVANIA 19063

PROJECT NAME
WAWA F85L 2019.01 STORE #6351 - CMM
1004 EDGEWOOD AVE.
JACKSONVILLE, FL 32254

No.	Description	Date
1	PRELIMINARY	08/09/2020
2	REV. 2019.01	08/10/2020
3	REV. 2019.01	08/10/2020
4	REV. 2019.01	08/10/2020
5	REV. 2019.01	08/10/2020

PROJECT NO.	212780
DATE	08/09/2020
DRAWN	WAWA
CHECKED	WAWA
DATE	08/09/2020