


Order Plans

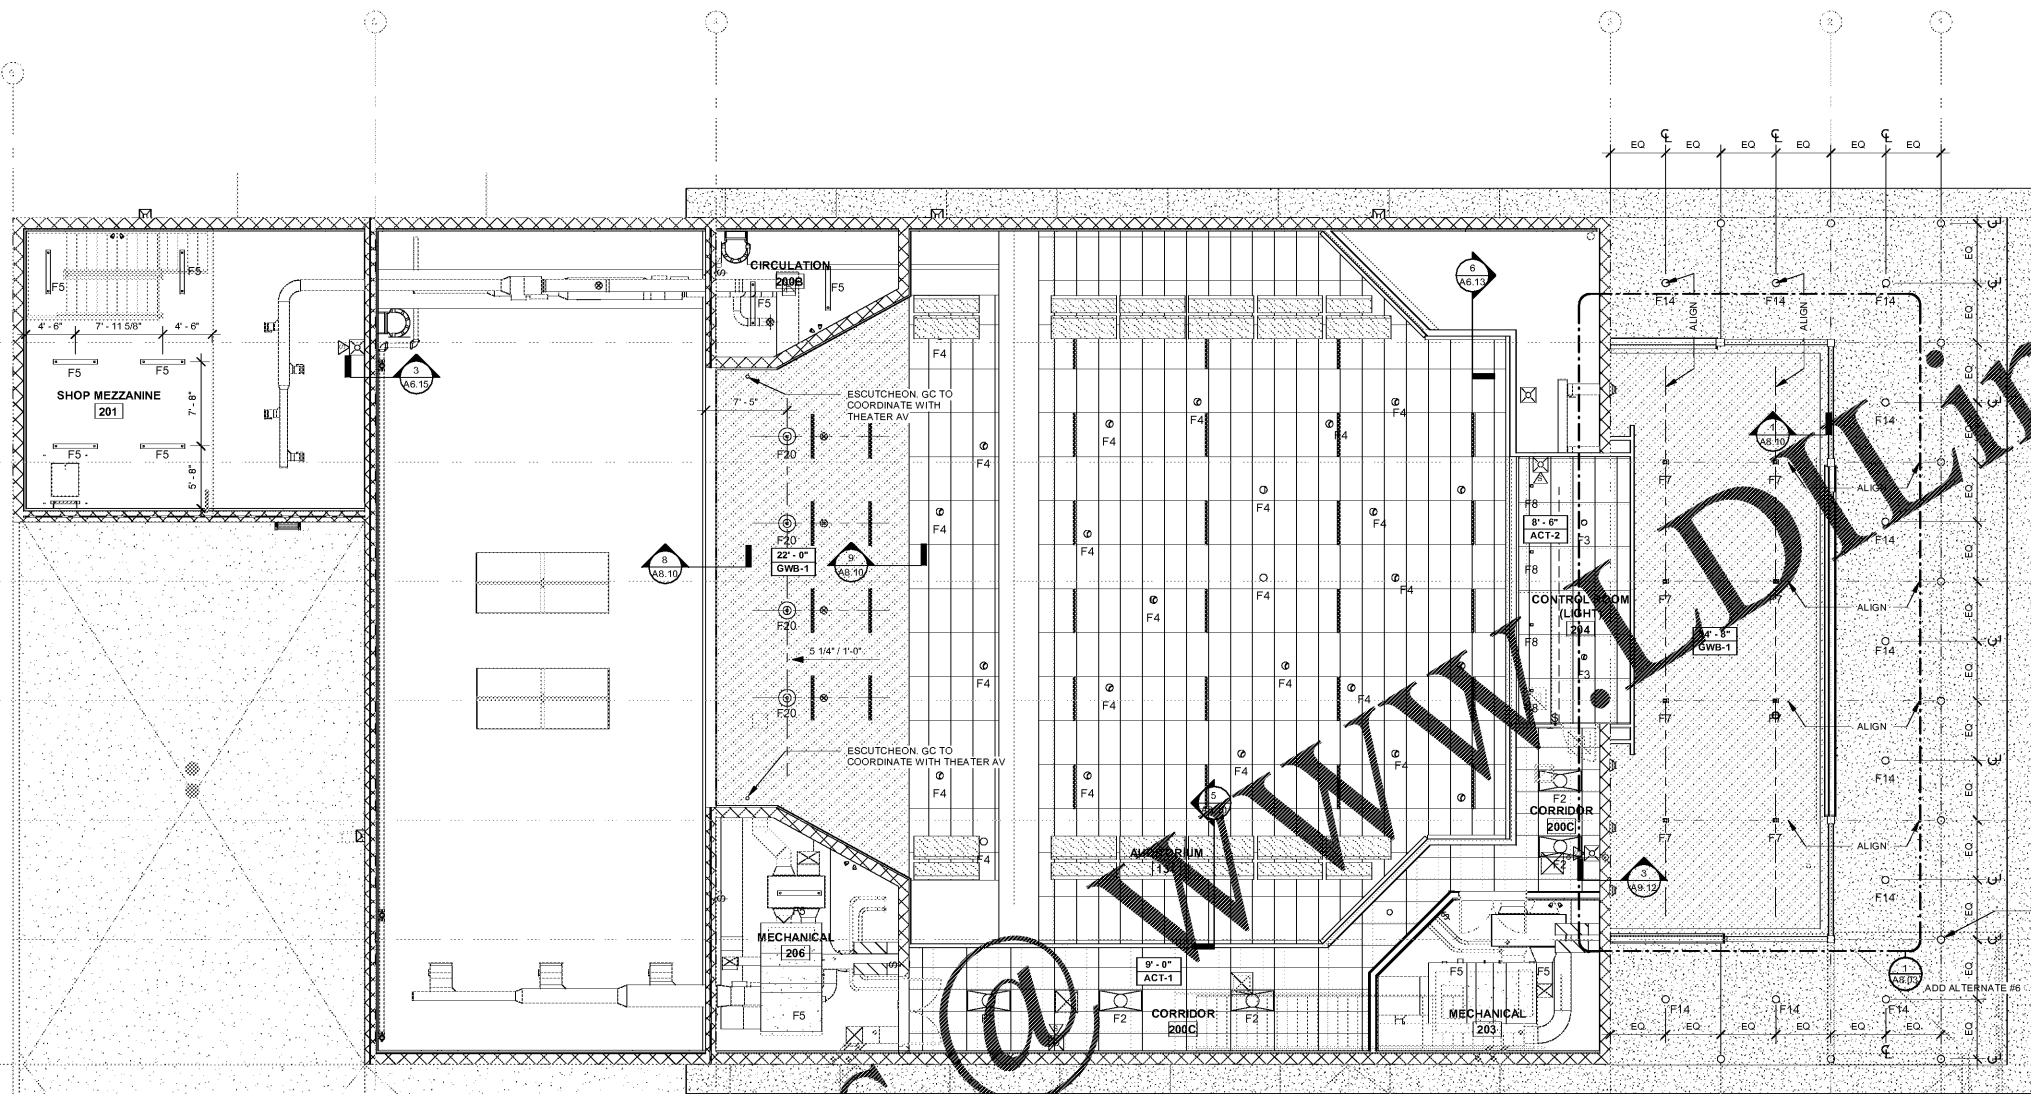

- F1 2' x 2' RECESSED DOWNLIGHT
- F2 4' LIGHT
- F3 2' ROUND RECESSED DOWNLIGHT
- F4 6' ROUND RECESSED DOWNLIGHT
- F5 PENDANT WORK LIGHT
- F6 WALL MOUNTED WORK LIGHT
- F7 CYLINDER PENDANT UP AND DOWN LIGHT
- F8 TRACK DIRECTIONAL LIGHT
- F9 SURFACE MOUNTED WALL SCONCE
- F10 4" RECESSED LINEAR LIGHT - 8' 8" LENGTH
- F11 4" RECESSED LINEAR LIGHT - 10' 3" LENGTH
- F12 4" RECESSED LINEAR LIGHT - 7' 10" LENGTH
- F13 WALL MOUNTED WORK LIGHT
- F14 4" ROUND RECESSED DOWNLIGHT - EXTERIOR
- F15 SURFACE MOUNTED 4" CYLINDER - EXTERIOR
- F16 WALL PACK LIGHT
- F17 JELLY JAR WITH WHITE LAMP
- F18 JELLY JAR WITH BLUE LAMP
- F19 NOT USED
- F20 PENDANT LIGHT
- F21 LED TAPE LIGHT

- WOOD WALLCOVERING: WWC-1
- 2X4 ACOUSTICAL CEILING TILE (WHITE): ACT-1
- 2X4 ACOUSTICAL CEILING TILE (BLACK): ACT-2
- CEMENT PLASTER CEILING: CPC-1
- GYPSON BOARD CEILING: GWB-1
- GYPSON BOARD CEILING (RED): GWB-2
- METAL CANOPY SOFFIT: MCS
- 6" WIDE T&G WOOD PLANK CEILING: WPC
- EXPOSED TO STRUCTURE: PAINT WITH DRY-FALL PAINT IN STAGE, SHOP AND AUDITORIUM: EXP

- SPRINKLER HEAD
GENERAL NOTE:
USE CONCEALED SPRINKLER HEADS IN THE FOLLOWING AREAS: ACT-2, CPC-1, GWB-1, GWB-2, WPC
- EXHAUST FAN
- SPEAKER
- SMOKE DETECTOR
- LIGHTED EXIT SIGN
- RETURN AIR
- SUPPLY DIFFUSER
- ROOF HATCH



REFLECTED CEILING PLAN LEGEND 1/8" = 1'-0"

SECOND FLOOR REFLECTED CEILING PLAN 1/8" = 1'-0" 1

FLEISCHMANGARCIA
ARCHITECTURE : PLANNING : INTERIORS
324 HYDE PARK AVENUE, SUITE 300
MIAMI, FL 33130
PHONE (772) 727-8890
FAX (813) 251-1984
WWW.FLEISCHMANGARCIA.COM

HILLSBOROUGH COUNTY
NEW TAMPA PERFORMING ARTS
CENTER
8550 HUNTERS VILLAGE RD.
TAMPA FL 33647

THIS DESIGN AND DRAWING IS THE SOLE PROPERTY OF FLEISCHMANGARCIA. NO PART OF THIS WORK MAY BE REPRODUCED WITHOUT PRIOR WRITTEN PERMISSION FROM FLEISCHMANGARCIA.

I CERTIFY TO THE BEST OF MY KNOWLEDGE THAT THESE DRAWINGS COMPLY WITH ALL RELEVANT BUILDING CODES.

PERMIT SET



MARCEL MASLOWSKI
AR98182

FGA PROJECT NUMBER
19048

ISSUE DATE
04-15-2020

NO.	DATE	NOTES

SHEET NAME

REFLECTED CEILING PLAN - LEVEL 02

SHEET NUMBER
A8.02