

GENERAL NOTES

- A. ALL WORK SHALL BE COMPLETED IN ACCORDANCE TO ALL LOCAL AND STATE CODES AND STANDARDS.
- B. COORDINATE ROUTING OF CHILLED WATER PIPING WITH ALL OTHER EQUIPMENT AND STRUCTURE.
- C. UNDERGROUND PIPING SHALL BE ROUTED TO AVOID BEING LOCATED UNDER HARDSCAPE AS MUCH AS POSSIBLE. COORDINATE WITH CIVIL PLANS AND UNDERGROUND UTILITIES.
- D. PLAN IS DIAGRAMMATIC IN NATURE. SEE SPECIFICATIONS, DETAILS AND CONTROLS SHEETS OR PIPING SUPPORTS, VALVING AND PIPING ACCESSORIES REQUIREMENTS.
- E. EXPANSION LOOPS SHALL BE COORDINATED DURING THE SHOP DRAWING PHASE.

KEYNOTES

- | NUMBER | NOTES |
|--------|---|
| 1 | ROUTE PIPING UNDERGROUND INSIDE CHILLER FENCING |
| 2 | CHILLER YARD FENCING TO ALLOW FOR REQUIRED FREE AREA. COORDINATE FREE AREA REQUIREMENT WITH MANUFACTURER RECOMMENDATIONS. |

VOLT AIR
 THESE DRAWINGS HAVE BEEN ELECTRICALLY REVISIONED BY DANNY A. CELIS, P.E. IN ACCORDANCE WITH THE REQUIREMENTS OF THE FLORIDA ELECTRICAL CODE. ALL CHANGES ARE INDICATED BY RED LINES AND DIMENSIONS. THIS DOCUMENT IS THE PROPERTY OF VOLT AIR. IT IS TO BE USED ONLY FOR THE PROJECT AND SITE SPECIFICALLY IDENTIFIED ON THESE DRAWINGS. ANY ELECTRIC COPIES ARE UNAUTHORIZED.
 6005 Benjamin Road, Suite A
 Tampa, Florida 33634
 Tel: 888.881.9713
 www.voltaire.com
 COA #27158
 Project #118940
 Engineer of Record:
 DANNY CELIS, P.E. #70642

FLEISCHMANGARCIA
 ARCHITECTURE : PLANNING : INTERIORS
 301 HOBBS AVENUE, SUITE 300
 TAMPA, FLORIDA 33606
 PHONE (727) 725-3000
 FAX (727) 725-3000
 www.fleischmangarcia.com

HILLSBOROUGH COUNTY
NEW TAMPA PERFORMING ARTS CENTER
 8550 HUNTERS VILLAGE RD.
 TAMPA FL, 33647

THIS DESIGN AND DRAWING IS THE SOLE PROPERTY OF FLEISCHMANGARCIA. NO PART OF THIS WORK MAY BE REPRODUCED WITHOUT PRIOR WRITTEN PERMISSION FROM FLEISCHMANGARCIA.

CERTIFY TO THE BEST OF MY KNOWLEDGE THAT THESE DRAWINGS COMPLY WITH ALL RELEVANT BUILDING CODES

PERMIT SET
 05/06/2020


FGA PROJECT NUMBER
19048

ISSUE DATE
04-15-2020

NO.	DATE	NOTES

SHEET NAME
SITE PLAN - HVAC

SHEET NUMBER
M1.0

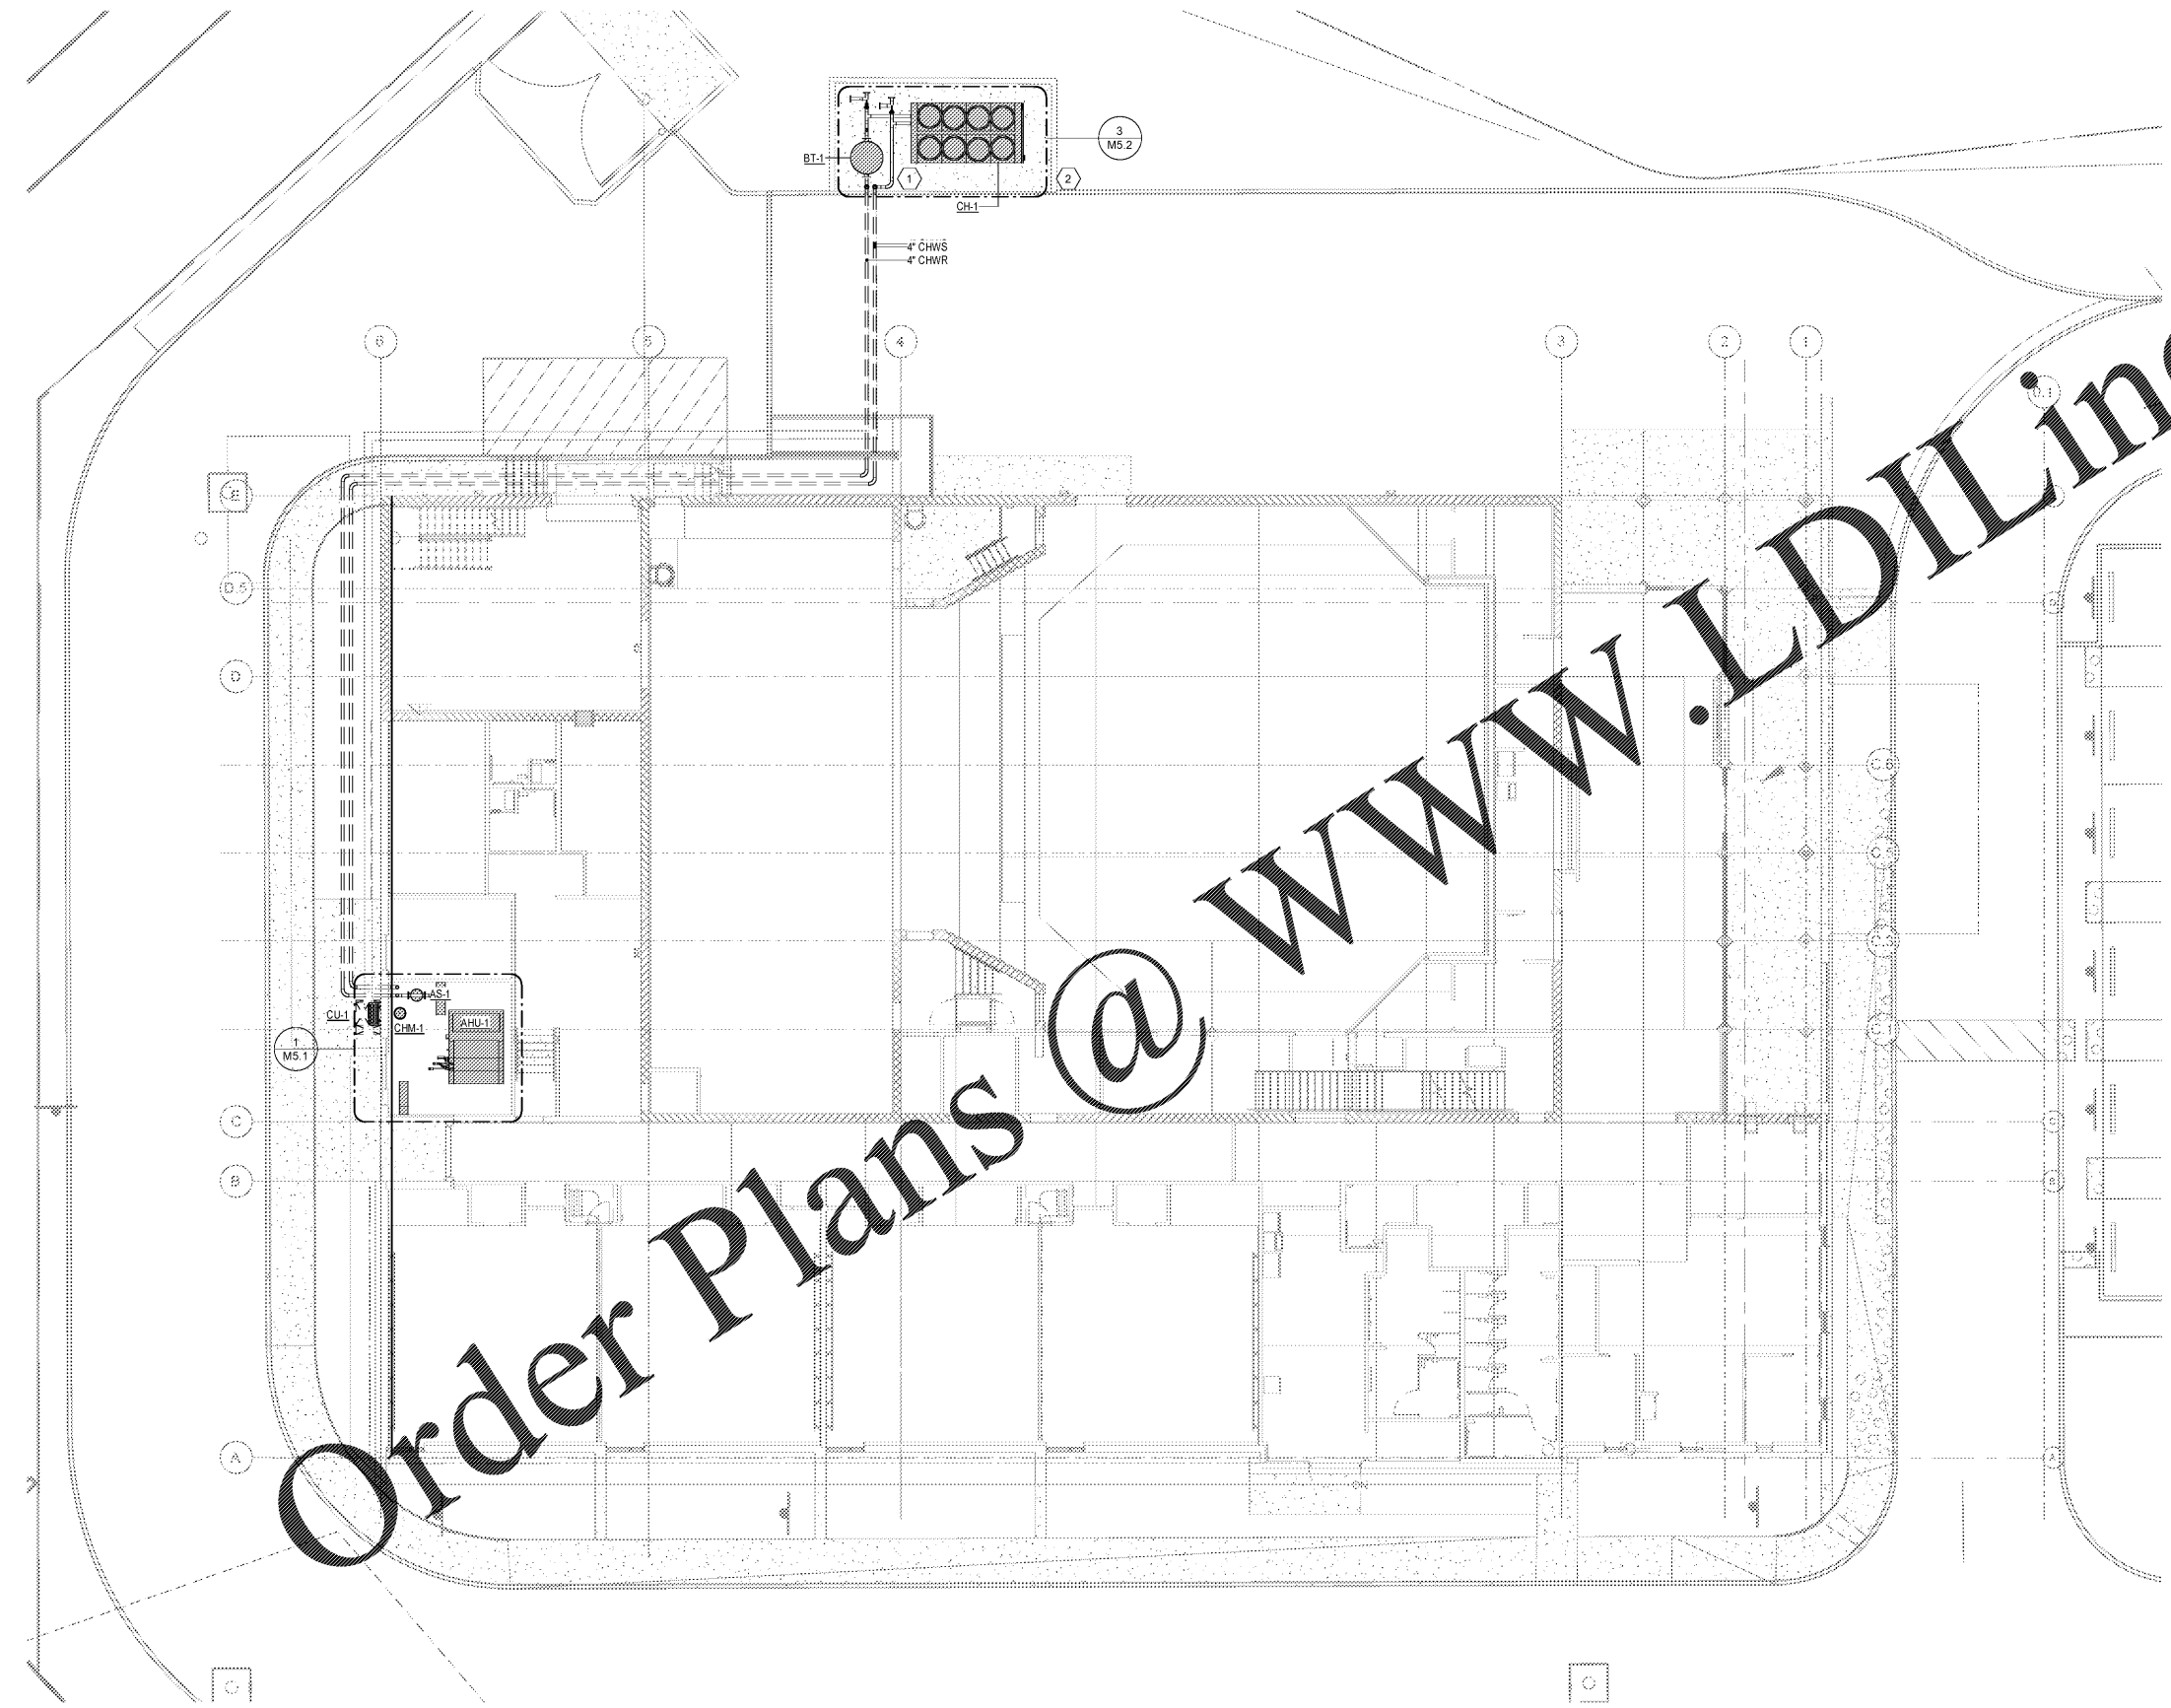

SITE PLAN - HVAC
 3/32" = 1'-0" 1

Order Plans @ www.LDILine.com