


GENERAL NOTES

A. ALL UNSWITCHED LIGHTING CIRCUITS CONTROLLED BY LIGHTING CONTROL PANEL VIA PROGRAMMABLE TIMELOCK U.O.N.

KEYNOTES

NUMBER	NOTES
1	MIRRORS WITH INTEGRAL LIGHTING ILLUMINATOR #6340628. CONFIRM MIRROR LIGHTING WITH ARCHITECT.

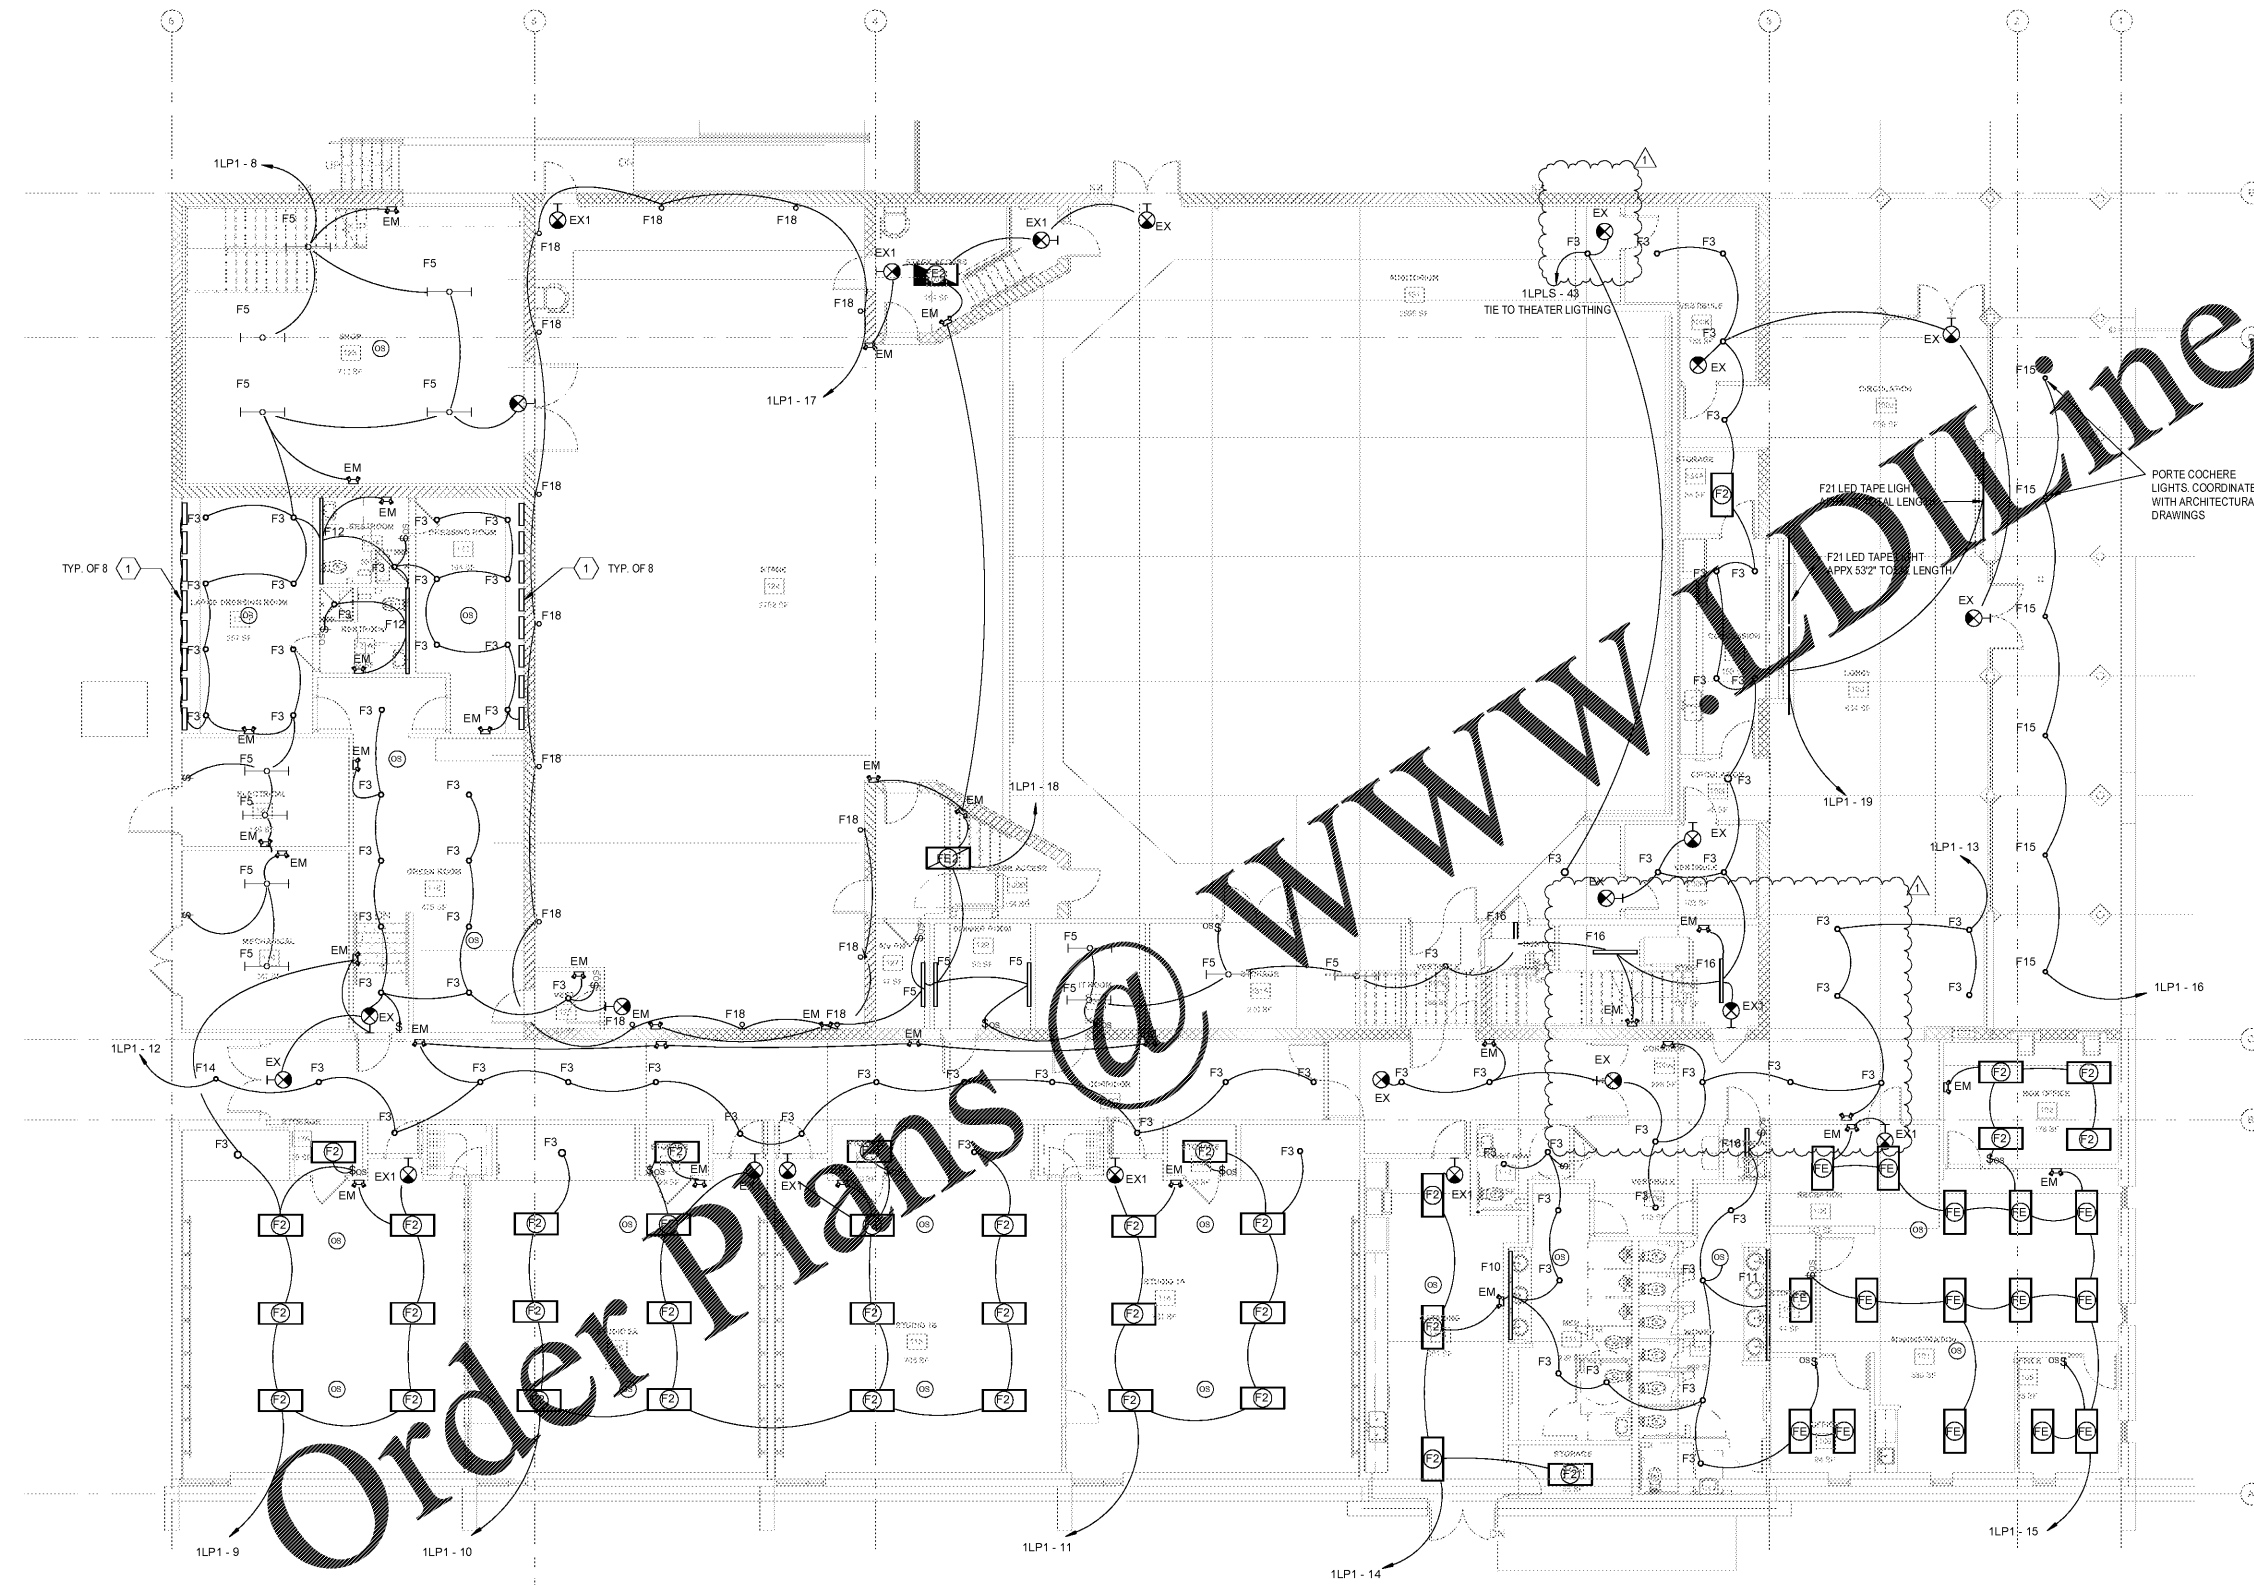

Order Plans @

FIRST FLOOR PLAN - LIGHTING 1


VOLT AIR
 THE FIRM HAS BEEN ELECTRICALLY REGISTERED WITH THE STATE OF FLORIDA UNDER LICENSE NO. 14575. GERALD A. CRIVELLO, P.E. IS THE LICENSED PROFESSIONAL ENGINEER. ALL COPIES OF THIS DOCUMENT ARE UNLESS OTHERWISE SPECIFIED TO BE UNCONTROLLED. THIS DRAWING IS THE PROPERTY OF VOLT AIR. IT IS TO BE USED ONLY FOR THE PROJECT AND SITE SPECIFICALLY IDENTIFIED HEREON. ANY REUSE OR REPRODUCTION OF THIS DRAWING WITHOUT THE WRITTEN PERMISSION OF VOLT AIR IS PROHIBITED.
 6005 Benjamin Road, Suite A
 Tampa, Florida 33634
 Tel: 888.881.8713
 www.voltair.com
 Project # 11.1804
 COA # 27158
 Engineer of Record:
 GERALD A. CRIVELLO, P.E. #42527

FLEISCHMANGARCIA
 ARCHITECTURE & PLANNING : INTERIORS
 3000 W. BOCA RATON AVENUE, SUITE 800
 BOCA RATON, FLORIDA 33433
 PHONE (772) 752-8800
 FAX (772) 752-8800
 www.fleischmangarcia.com

**HILLSBOROUGH COUNTY
 NEW TAMPA PERFORMING ARTS
 CENTER**
 8550 HUNTERS VILLAGE RD.
 TAMPA FL, 33647

THIS DESIGN AND DRAWING IS THE SOLE PROPERTY OF FLEISCHMANGARCIA. NO PART OF THIS WORK MAY BE REPRODUCED WITHOUT PRIOR WRITTEN PERMISSION FROM FLEISCHMANGARCIA.

CERTIFY TO THE BEST OF MY KNOWLEDGE THAT THESE DRAWINGS COMPLY WITH ALL RELEVANT BUILDING CODES.

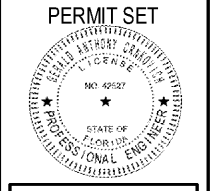

FGA PROJECT NUMBER
19048

ISSUE DATE
04-15-2020

NO.	DATE	NOTES
1	05.26.20	Permit Comments

SHEET NAME

FIRST FLOOR PLAN - LIGHTING

SHEET NUMBER
E3.1