

**VOLT AIR**  
 6005 Benjamin Road, Suite A  
 Tampa, Florida 33634  
 Tel: 888.881.9713  
 www.voltaire.com  
 COA #27156 Project #11.18040  
 Engineer of Record:  
 BRYAN R. ZEMINA, P.E. #7898

**FLEISCHMANGARCIA**  
 ARCHITECTURE  
 251 HUNTERS VILLAGE AVENUE, SUITE 300  
 TAMPA, FLORIDA 33647  
 PHONE (813) 251-1884  
 FAX (813) 251-1884  
 www.fleischmangarcia.com

HILLSBOROUGH COUNTY  
**NEW TAMPA PERFORMING ARTS CENTER**  
 8550 HUNTERS VILLAGE RD.  
 TAMPA FL, 33647

THIS DESIGN AND DRAWING IS THE SOLE PROPERTY OF FLEISCHMANGARCIA. NO PART OF THIS WORK MAY BE REPRODUCED WITHOUT PRIOR WRITTEN PERMISSION FROM FLEISCHMANGARCIA.

PERMIT SET  
 05/06/2020  
 BRYAN R. ZEMINA, P.E.  
 STATE OF FLORIDA  
 PROFESSIONAL ENGINEER

FGA PROJECT NUMBER  
 19048


ISSUE DATE  
 04-15-2020

NO.	DATE	NOTES

SHEET NAME

FIRST FLOOR PLAN - GRAVITY

SHEET NUMBER  
**P2.1**

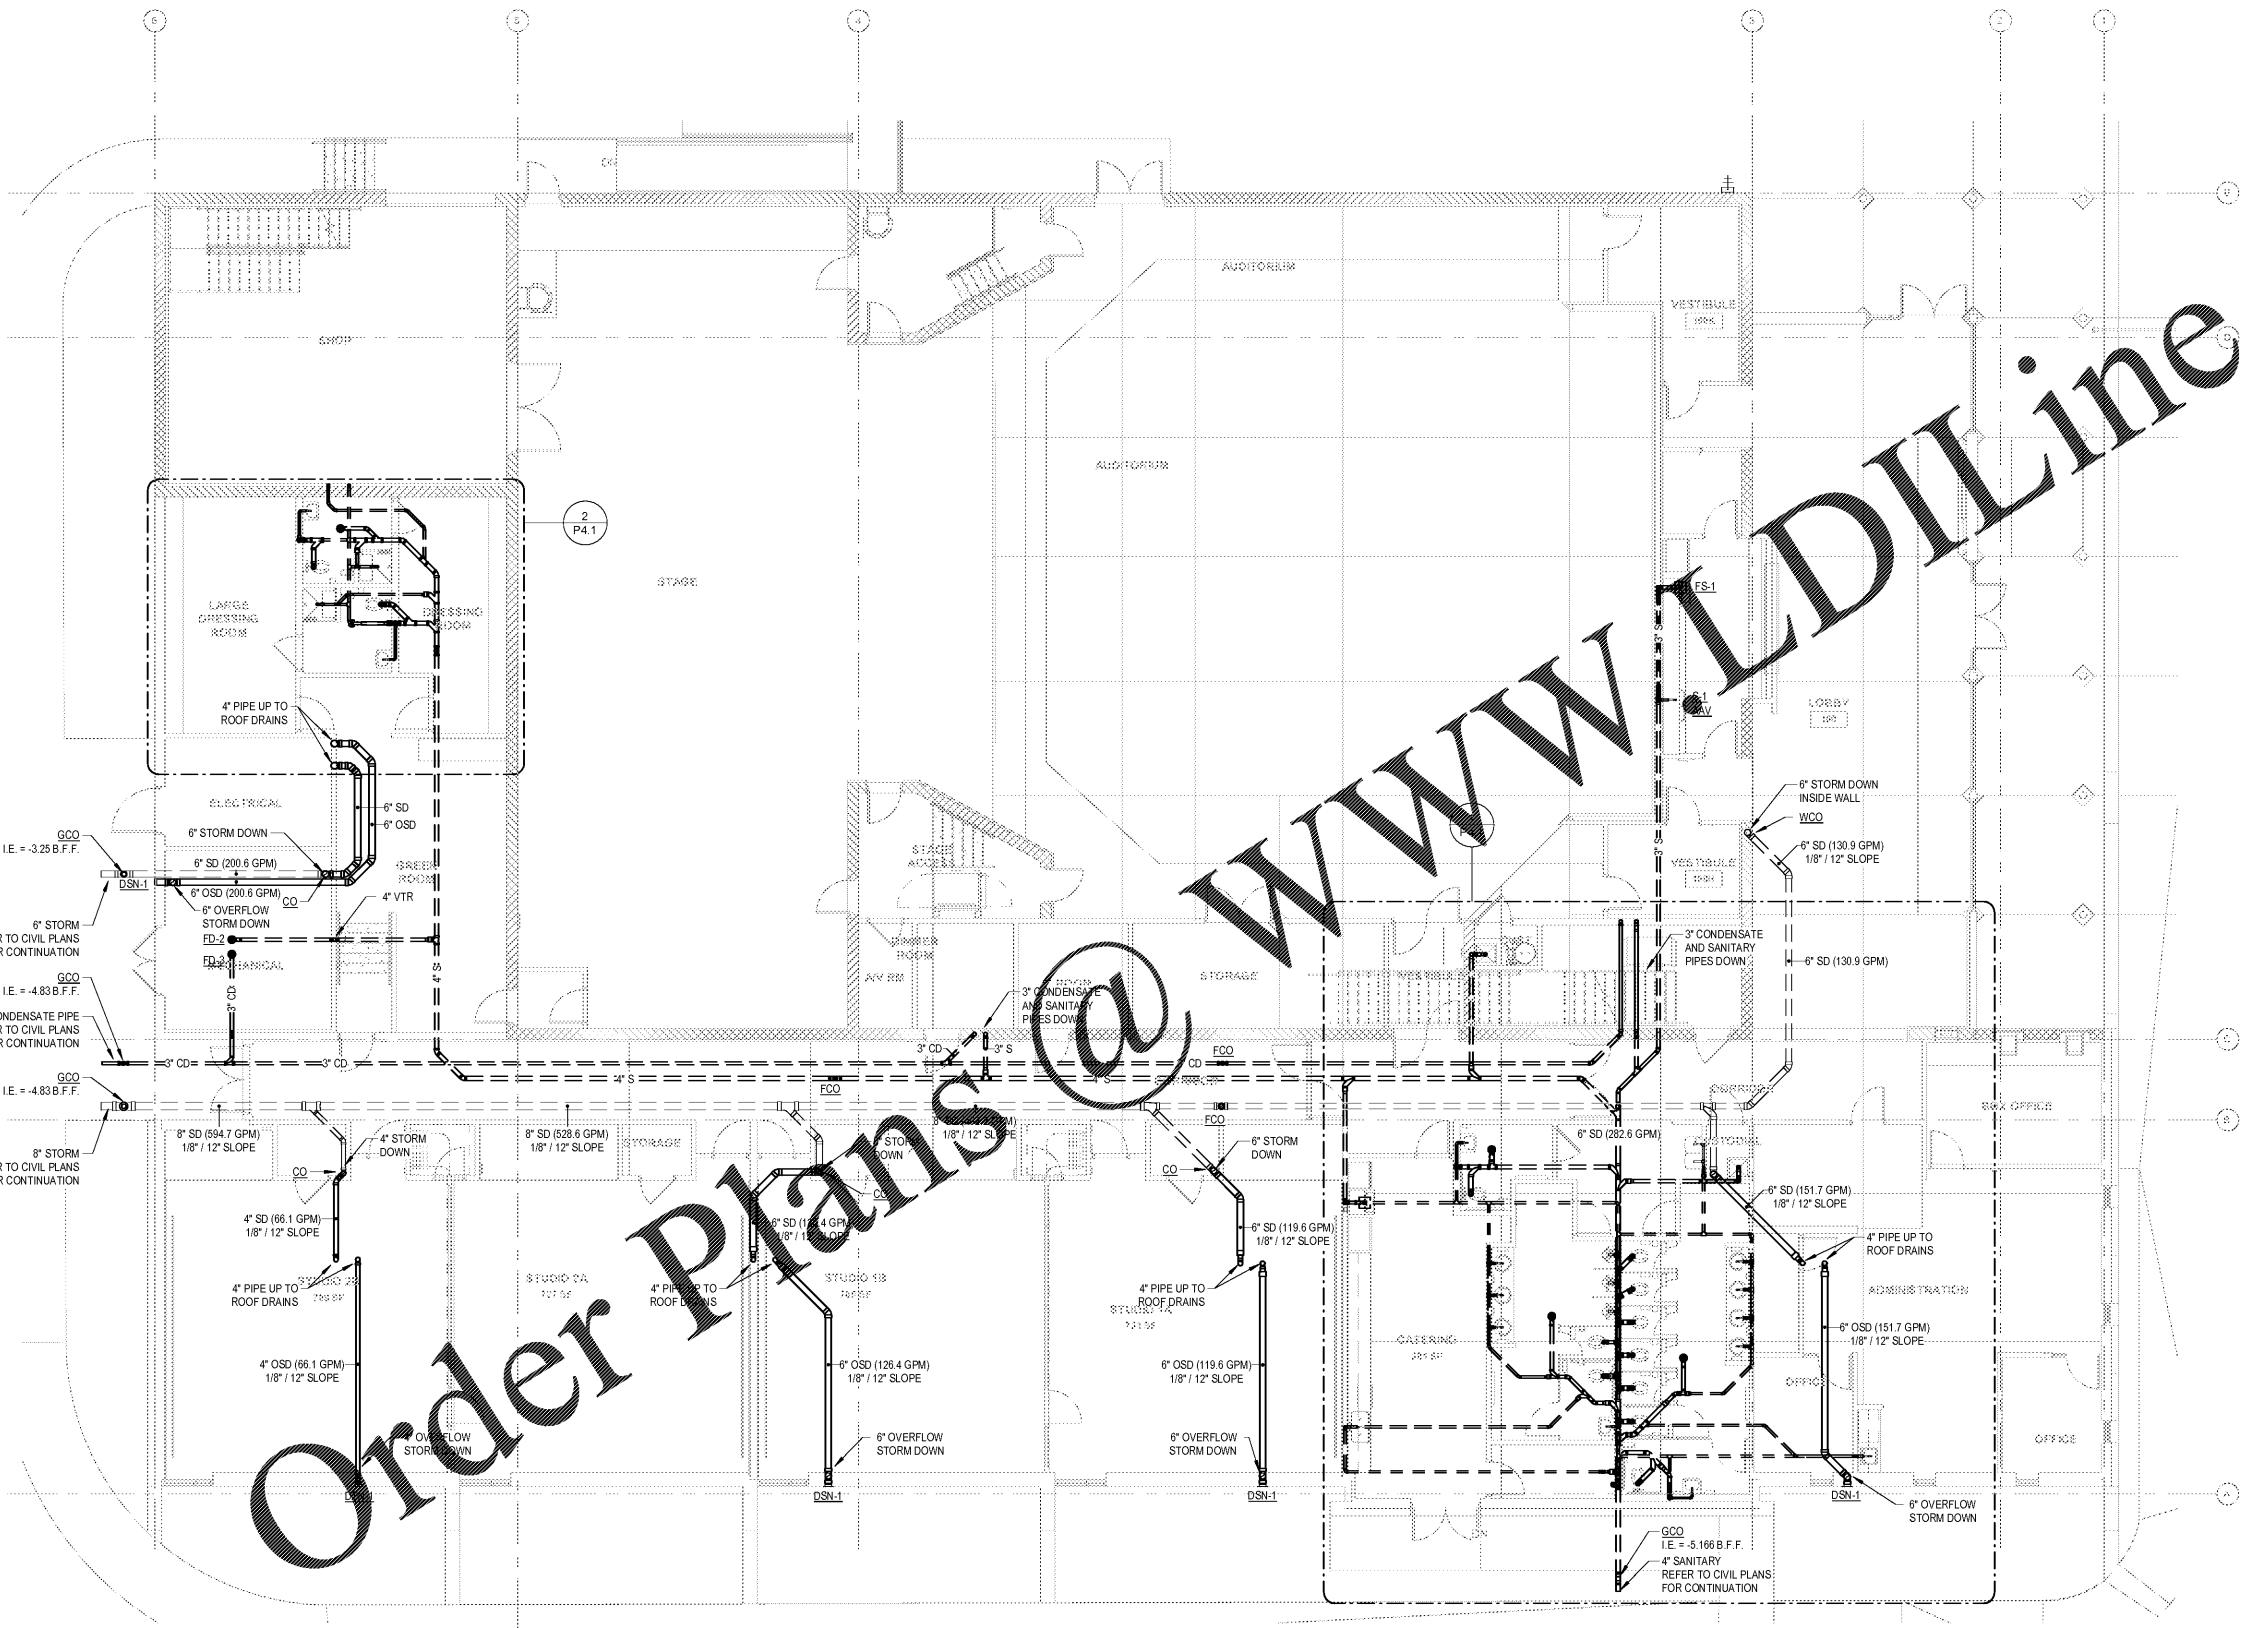

Order Plans @ [www.LDILine.com](http://www.LDILine.com)

[www.LDILine.com](http://www.LDILine.com)