


Order Plans @ [www.LDILine.com](http://www.LDILine.com)

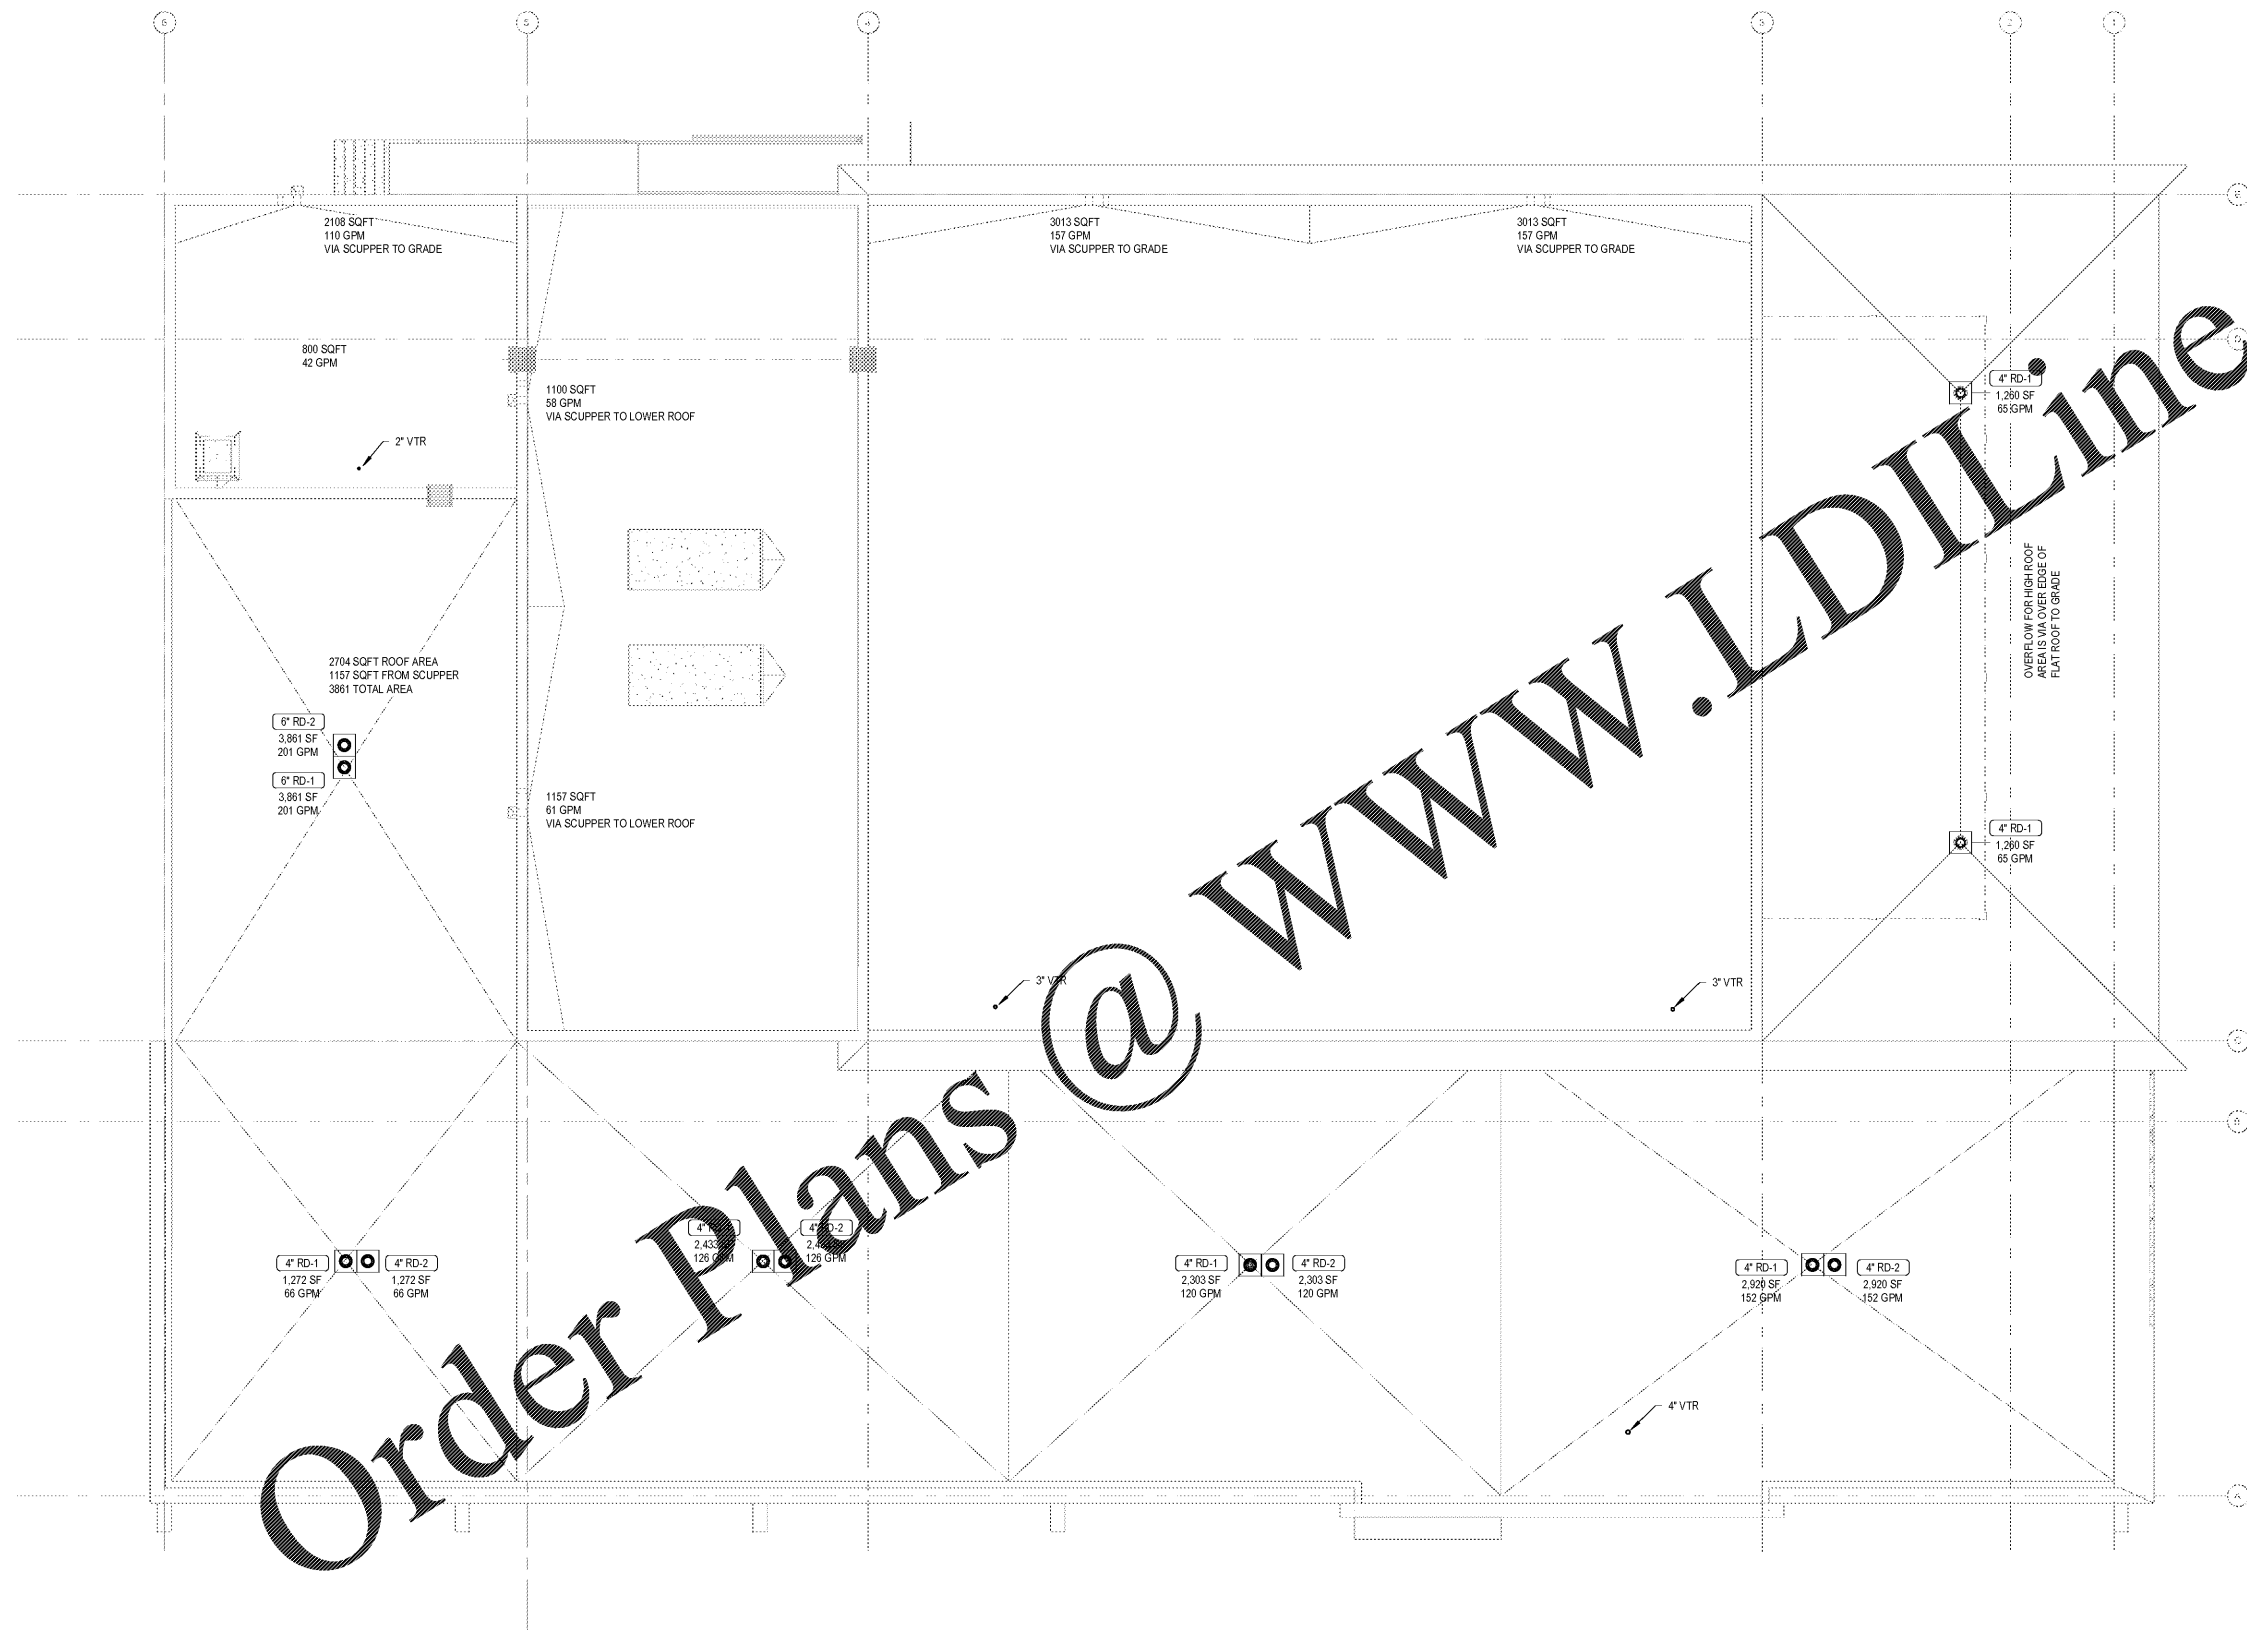

ROOF PLAN - PLUMBING 1  
1/8" = 1'-0"

**VOLT AIR**  
 6002 Benjamin Road, Suite A  
 Tampa, Florida 33634  
 Tel: 888.881.6713  
 www.voltaire.com  
 Project # 1: 1904  
 COA # 27156  
 Engineer of Record:  
 BRYAN R. ZEMINA, P.E. #75988


**FLEISCHMANGARCIA**  
 ARCHITECTURE : PLUMBING : INTERIORS  
 5807 CATALINA LANE, SUITE 400  
 TAMPA, FLORIDA 33634  
 PHONE (772) 726-8900  
 FAX (813) 251-1984  
 www.fleischmangarcia.com

HILLSBOROUGH COUNTY  
**NEW TAMPA PERFORMING ARTS CENTER**  
 8550 HUNTERS VILLAGE RD.  
 TAMPA FL, 33647

THIS DESIGN AND DRAWING IS THE SOLE PROPERTY OF FLEISCHMANGARCIA. NO PART OF THIS WORK MAY BE REPRODUCED WITHOUT PRIOR WRITTEN PERMISSION FROM FLEISCHMANGARCIA.

CERTIFY TO THE BEST OF MY KNOWLEDGE THAT THESE DRAWINGS COMPLY WITH ALL RELEVANT BUILDING CODES

PERMIT SET

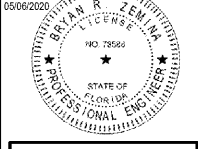

FGA PROJECT NUMBER  
19048

ISSUE DATE  
04-15-2020

NO.	DATE	NOTES

SHEET NAME

ROOF PLAN - PLUMBING

SHEET NUMBER  
**P2.3**

DATE PLOTTED: 04/15/2020