


ENLARGED FIRE RISER ROOM - FIRE PROTECTION
1/4" = 1'-0" ②

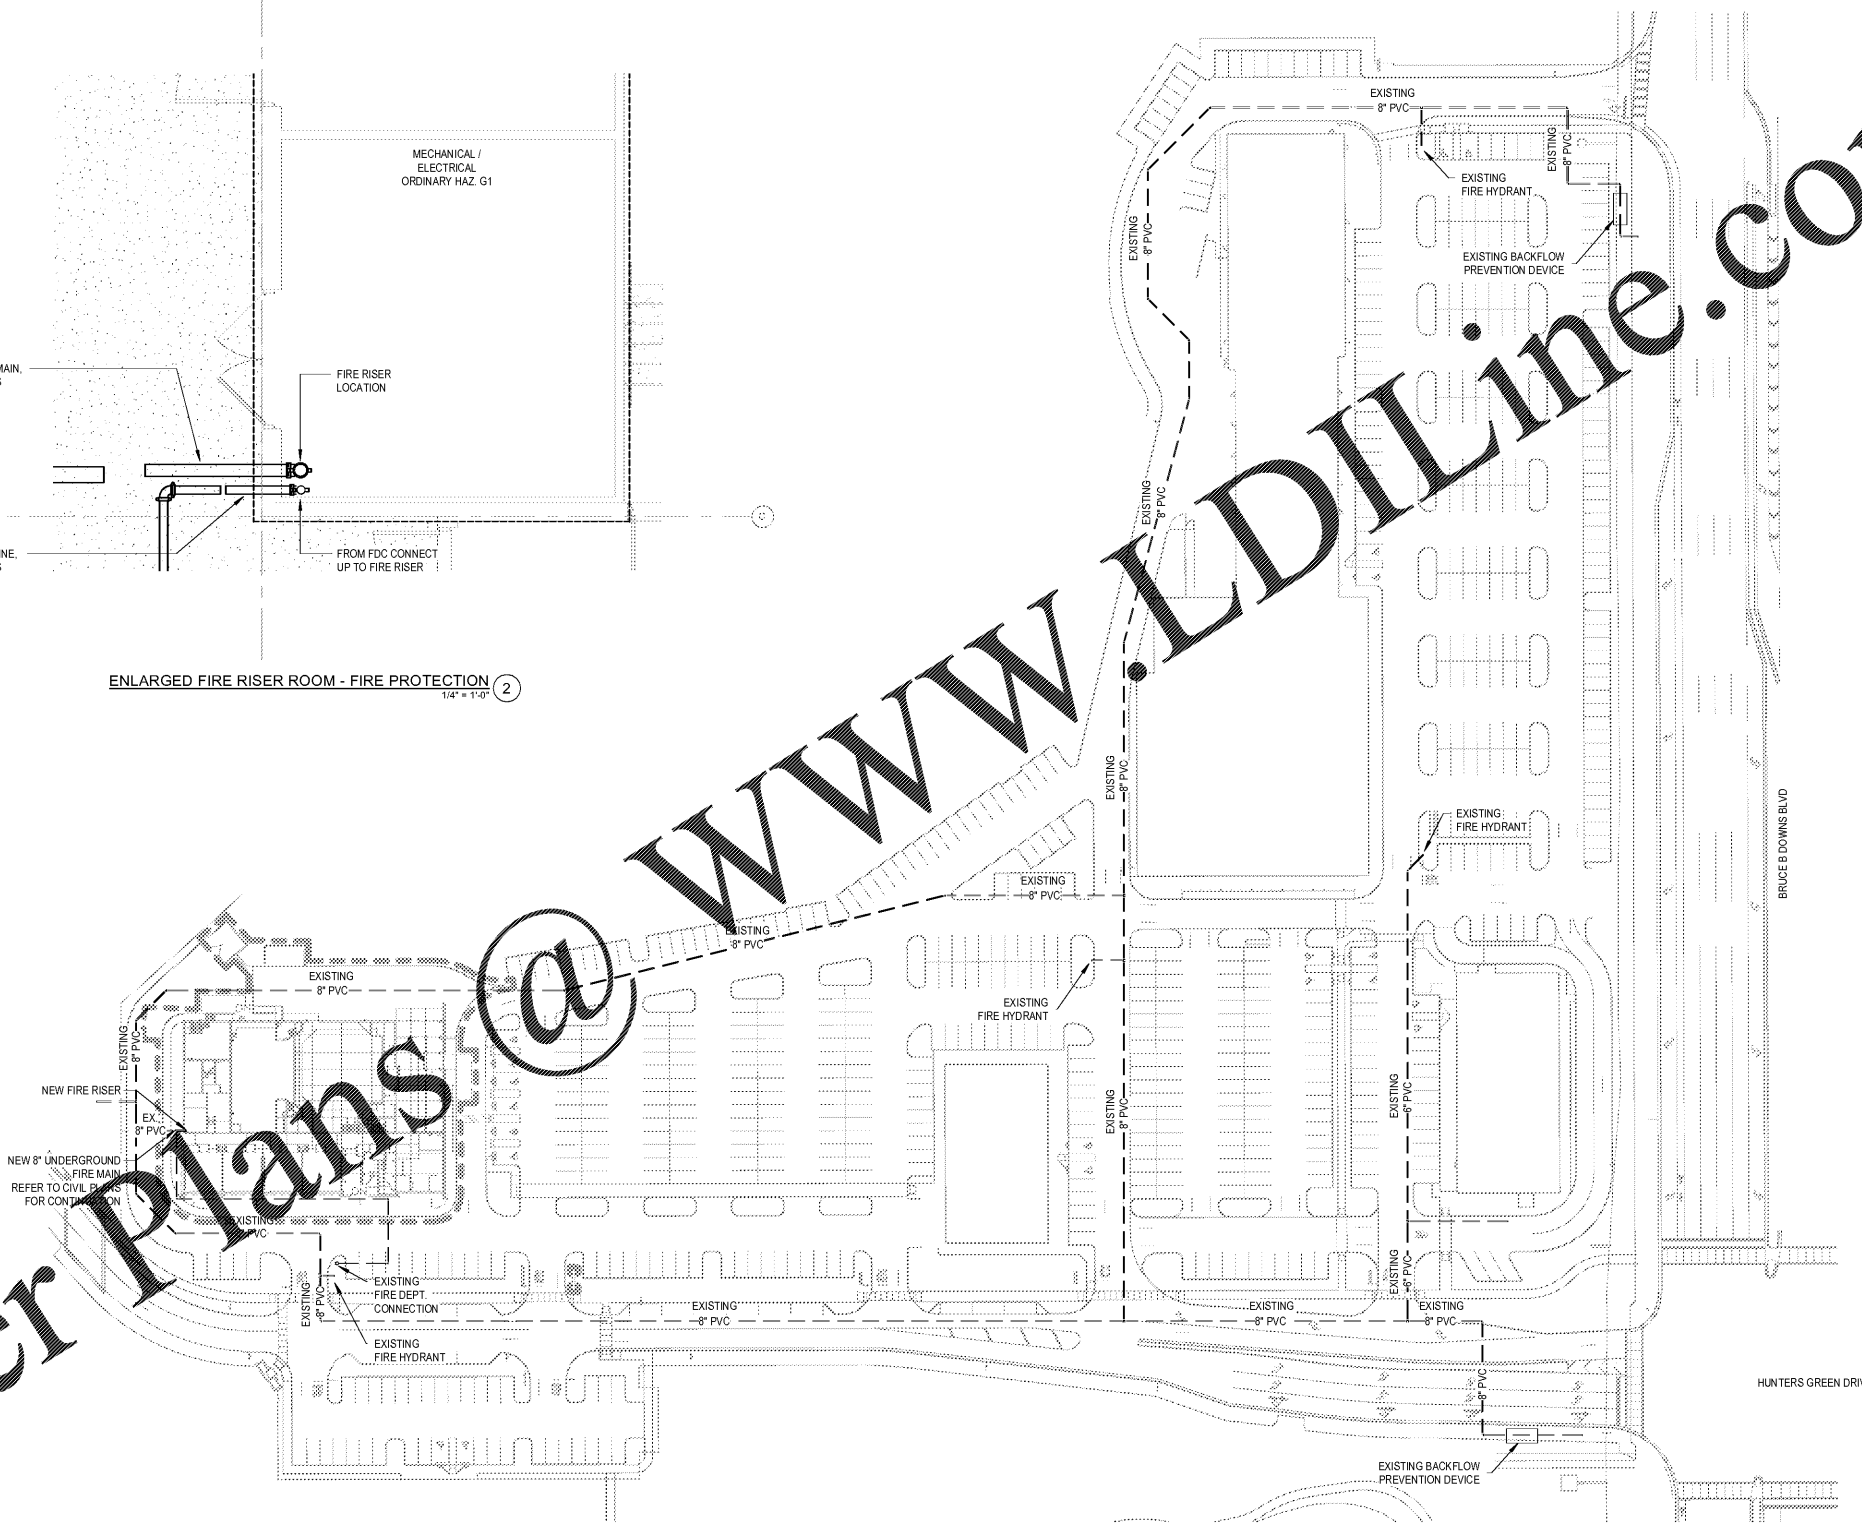

SITE PLAN - FIRE PROTECTION
1" = 60'-0" ①

Order Plans @ www.LDILine.com

VOLT AIR

6005 Benjamin Road, Suite A
Tampa, Florida 33634
Tel: 888.881.9713
www.voltairinc.com
COA #27156 Project #0118940

Engineer of Record:
BRYAN R. ZEMINA, P.E. #7898

THIS DRAWING HAS BEEN ELECTRONICALLY
SIGNED BY BRYAN R. ZEMINA, P.E.
ON 04/15/2020 AT 10:58 AM EST.
COPIES OF THIS DOCUMENT ARE NOT
VALID UNLESS THEY ARE SIGNED OR
STAMPED BY THE ENGINEER OF RECORD OR
ANY ELECTRONIC COPIES

FLEISCHMANGARCIA

ARCHITECT OF RECORD : FLEISCHMANGARCIA ARCHITECTS
301 HOBBS AVENUE, SUITE 200
TAMPA, FLORIDA 33606
PHONE (727) 725-3000
FAX (727) 725-3000
www.fleischmangarcia.com

SAFETY ENGINEER OFFICE
1500 FLORIDA AVENUE, SUITE 1500
TAMPA, FLORIDA 33606
PHONE (727) 725-3000
FAX (727) 725-3000

SAFETY ENGINEER OFFICE
5801 CATTLEMAN LANE, SUITE 100
SARASOTA, FLORIDA 34235
PHONE (941) 342-2525
FAX (941) 342-2525

HILLSBOROUGH COUNTY
NEW TAMPA PERFORMING ARTS
CENTER
8550 HUNTERS VILLAGE RD.
TAMPA FL, 33647

THIS DESIGN AND DRAWING IS THE SOLE PROPERTY OF FLEISCHMANGARCIA. NO PART OF THIS WORK MAY BE REPRODUCED WITHOUT PRIOR WRITTEN PERMISSION FROM FLEISCHMANGARCIA.

CERTIFY TO THE BEST OF MY KNOWLEDGE THAT THESE DRAWINGS COMPLY WITH ALL RELEVANT BUILDING CODES

PERMIT SET
04/15/2020

BRYAN R. ZEMINA, P.E.
PRO. 7898

STATE OF FLORIDA
PROFESSIONAL ENGINEER

FGA PROJECT NUMBER
19048

ISSUE DATE
04-15-2020

NO.	DATE	REVISIONS	NOTES

SHEET NAME

SITE PLAN - FIRE PROTECTION

SHEET NUMBER
F1.0