


Order Plans @

WWW.LDILine.com

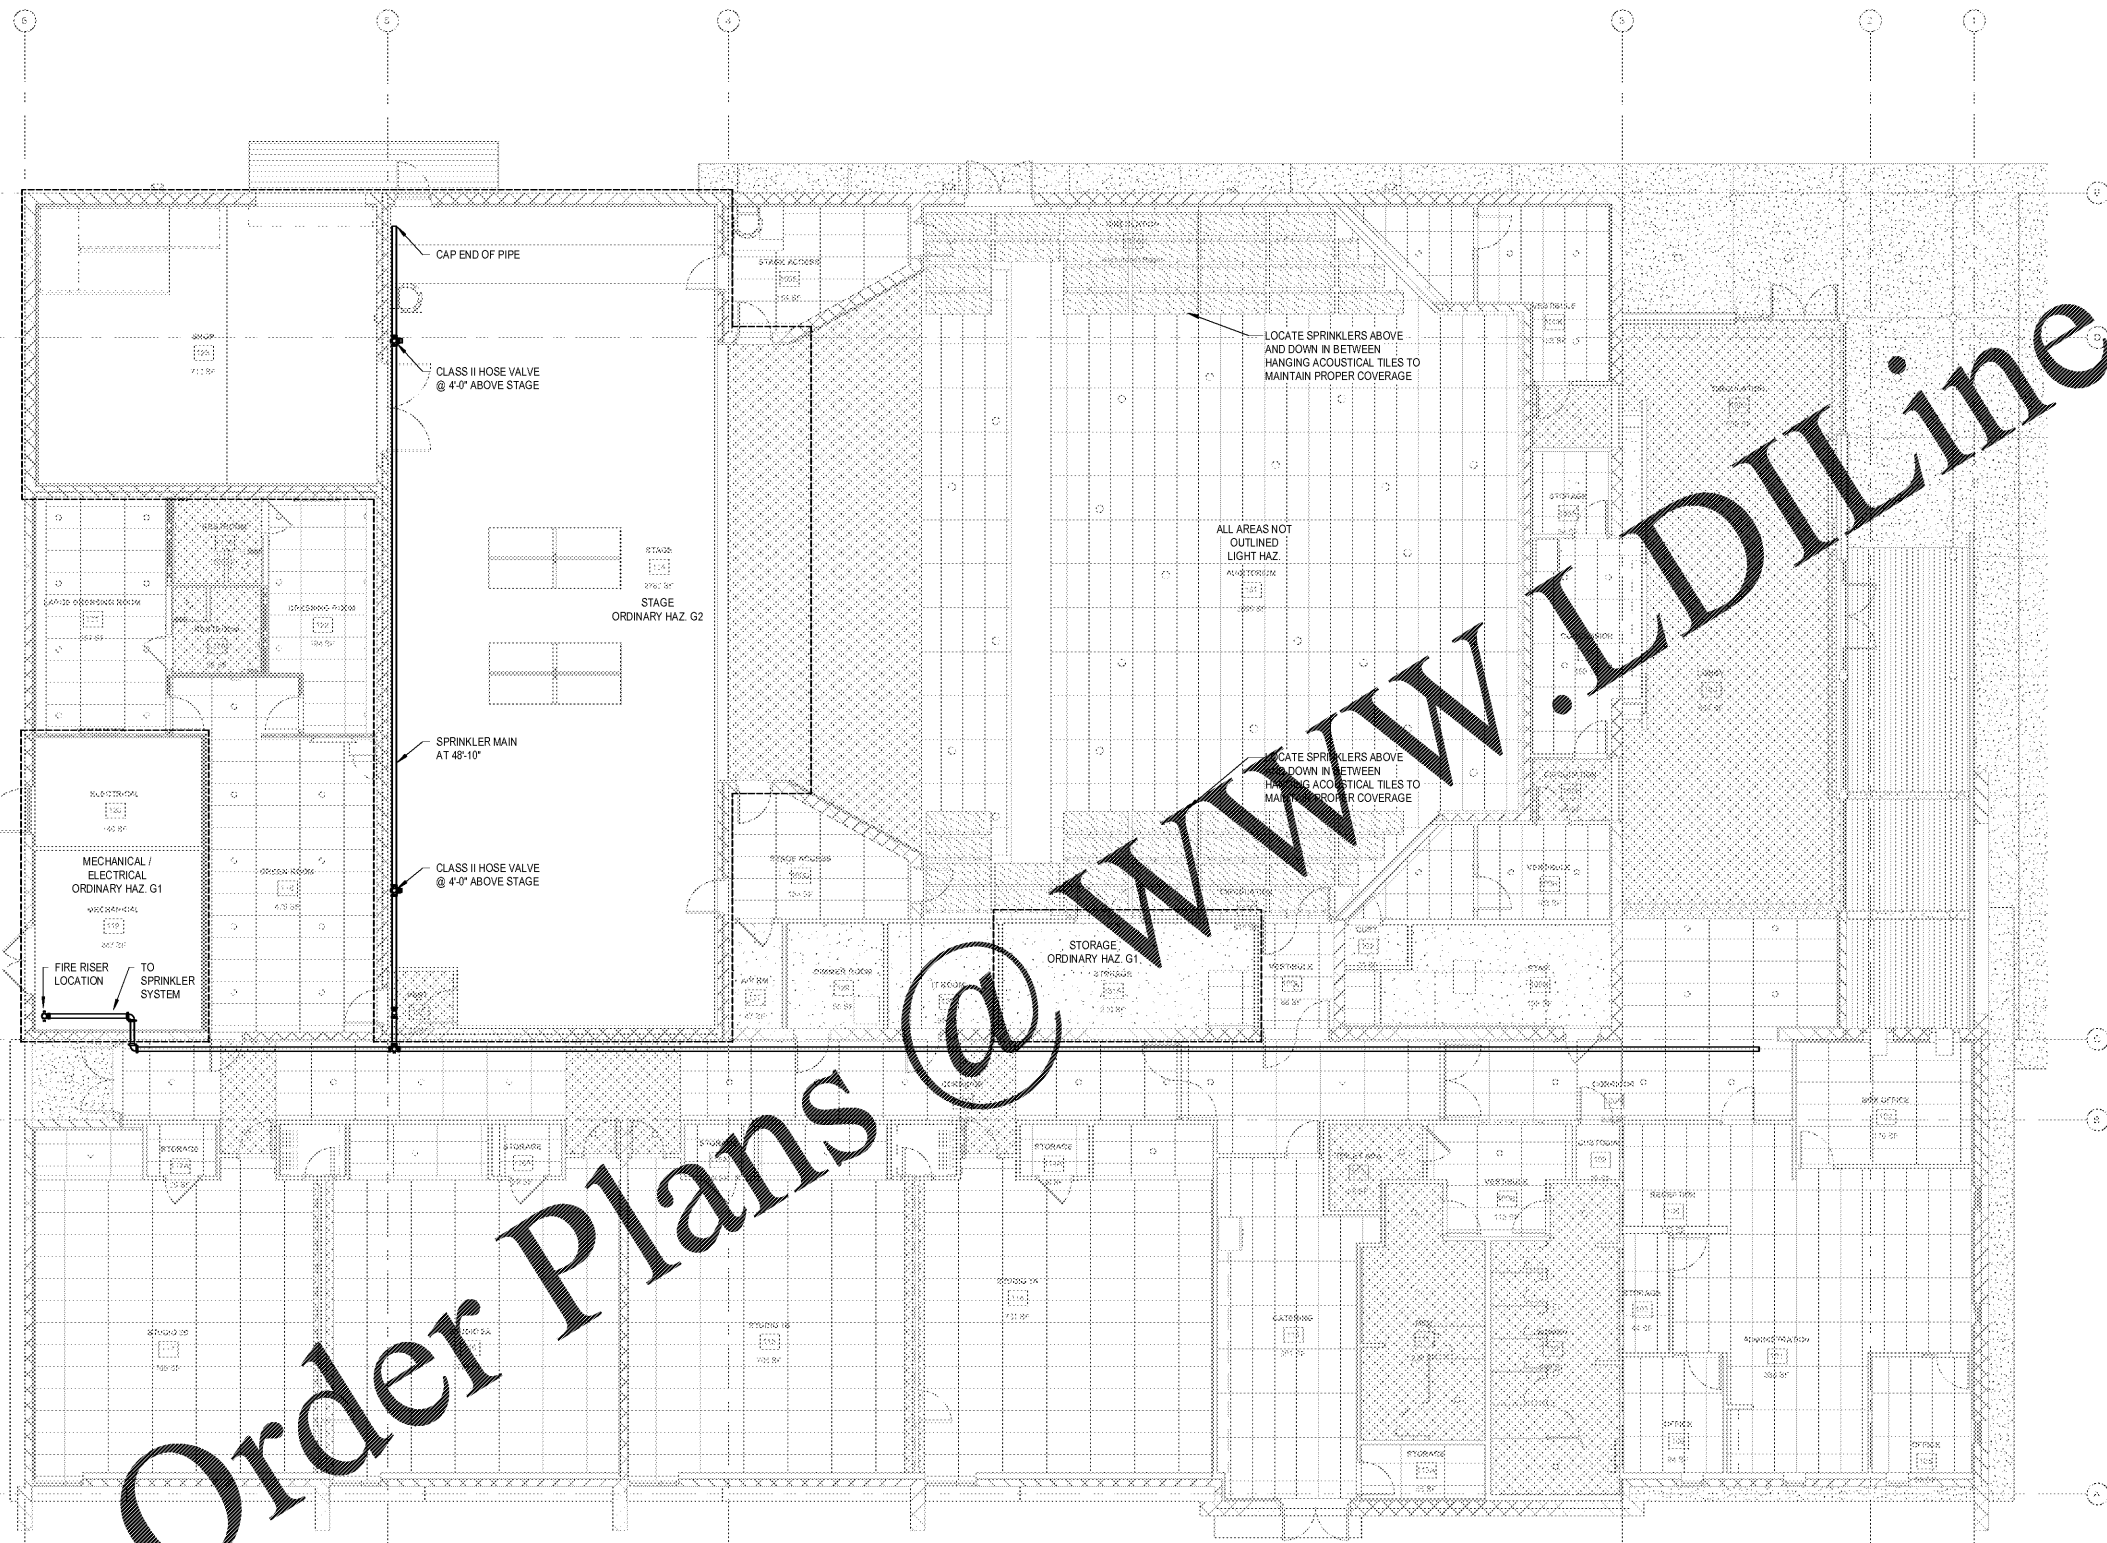

FIRST FLOOR PLAN - FIRE PROTECTION 1

VOLT AIR
 6005 Benjamin Road, Suite A
 Tampa, Florida 33634
 Tel: 888.881.0713
 www.voltafire.com
 Project # 19048
 COA # 27156
 Engineer of Record:
 BRYAN R. ZEMINA, P.E. #7898

FLEISCHMANGARCIA
 ARCHITECTURE & PLANNING : INTERIORS
 231 HOBBS AVENUE, SUITE 300
 TAMPA, FLORIDA 33606
 PHONE (813) 251-1844
 FAX (813) 251-1844
 www.fleischmangarcia.com

HILLSBOROUGH COUNTY
NEW TAMPA PERFORMING ARTS CENTER
 8550 HUNTERS VILLAGE RD.
 TAMPA FL, 33647

THIS DESIGN AND DRAWING IS THE SOLE PROPERTY OF FLEISCHMANGARCIA. NO PART OF THIS WORK MAY BE REPRODUCED WITHOUT PRIOR WRITTEN PERMISSION FROM FLEISCHMANGARCIA.

CERTIFY TO THE BEST OF MY KNOWLEDGE THAT THESE DRAWINGS COMPLY WITH ALL RELEVANT BUILDING CODES

PERMIT SET
 04/15/2020
 BRYAN R. ZEMINA, P.E.
 PROFESSIONAL ENGINEER
 STATE OF FLORIDA
 NO. 72560

FGA PROJECT NUMBER
 19048

ISSUE DATE
 04-15-2020

NO.	DATE	NOTES

SHEET NAME
 FIRST FLOOR PLAN - FIRE PROTECTION

SHEET NUMBER
F2.1