


Order Plans @

WWW.LDILine.com

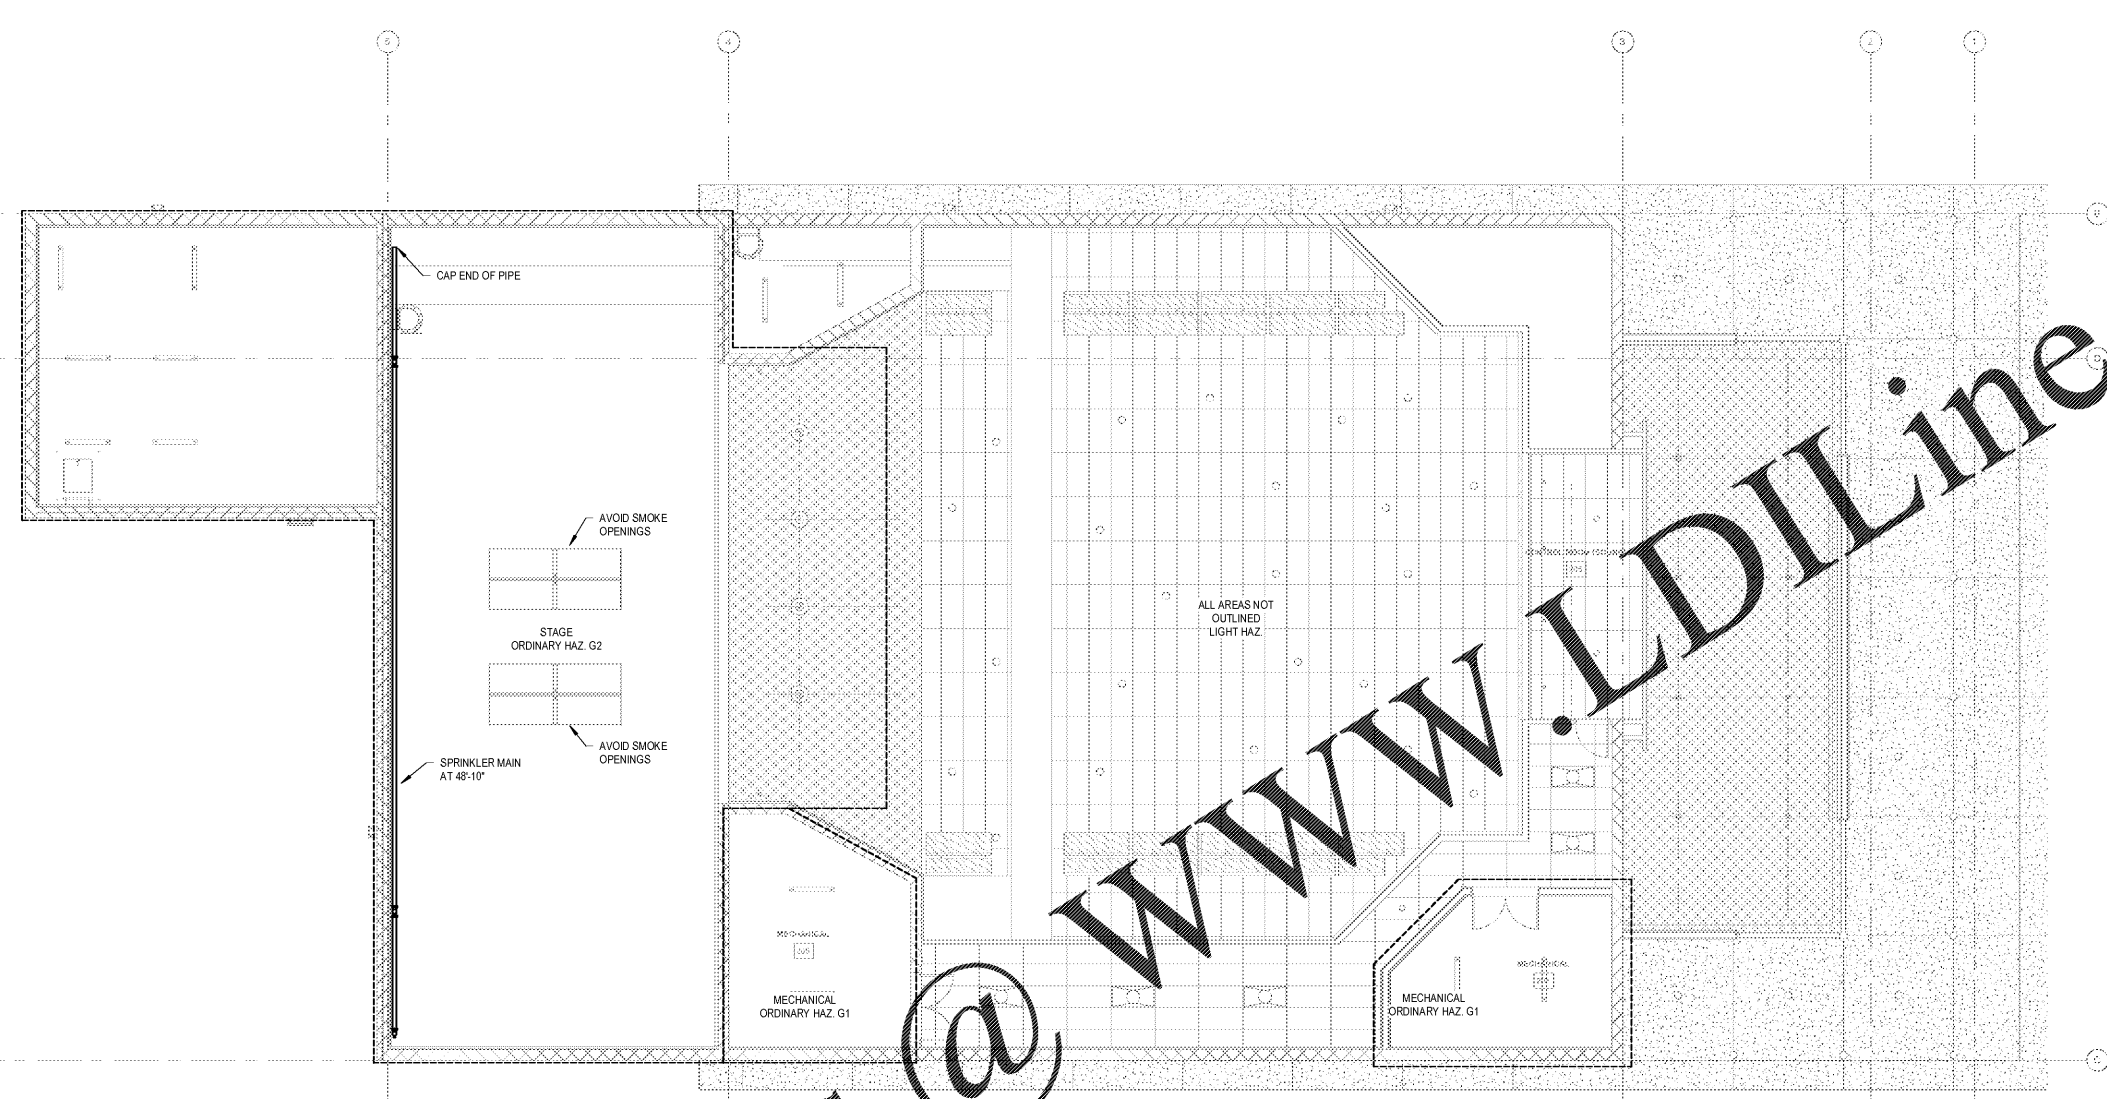

SECOND FLOOR PLAN - FIRE PROTECTION 1


VOLT AIR
 THIS DRAWING HAS BEEN ELECTRONICALLY
 BY: BRYAN R. ZEMINA, P.E.
 COMPANY: VOLT AIR INC.
 COPIES OF THIS DOCUMENT ARE NOT
 VALID UNLESS THEY ARE SIGNED AND
 SEALED BY THE ENGINEER.
 ANY ELECTRONIC COPIES
 6005 Benjamin Road, Suite A
 Tampa, Florida 33634
 Tel: 888.881.6713
 www.voltair.com
 Project # 11-18040
 COA # 27156
 Engineer of Record:
 BRYAN R. ZEMINA, P.E. #75988

FLEISCHMANGARCIA
 ARCHITECTURE
 ARCHITECTS OF RECORD : PLANNING : INTERIORS
 251 HOBBS AVENUE, SUITE 200
 TAMPA, FLORIDA 33606
 PHONE (813) 725-3000
 FAX (813) 251-1884
 www.fleischmangarcia.com
 REGISTERED ARCHITECTS
 STATE OF FLORIDA
 LICENSE NO. 12423
 BRYAN R. ZEMINA, P.E.
 ENGINEER OF RECORD
 LICENSE NO. 75988
 STATE OF FLORIDA
 PROFESSIONAL ENGINEER

HILLSBOROUGH COUNTY
 NEW TAMPA PERFORMING ARTS
 CENTER
 8550 HUNTERS VILLAGE RD.
 TAMPA FL, 33647

THIS DESIGN AND DRAWING IS THE SOLE
 PROPERTY OF FLEISCHMANGARCIA. NO
 PART OF THIS WORK MAY BE
 REPRODUCED WITHOUT PRIOR WRITTEN
 PERMISSION FROM FLEISCHMANGARCIA.

I CERTIFY TO THE BEST OF MY
 KNOWLEDGE THAT THESE DRAWINGS
 COMPLY WITH ALL RELEVANT BUILDING
 CODES

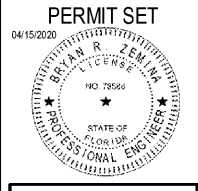

FGA PROJECT NUMBER
 19048

ISSUE DATE
 04-15-2020

NO.	DATE	REVISIONS	NOTES

SHEET NAME
 SECOND FLOOR
 PLAN - FIRE
 PROTECTION

SHEET NUMBER
 F2.2