


PROVIDE A FULL T-WALL TO ACCOMMODATE A TOTAL OF (34) POSSIBLE COUNTERWEIGHT LINESETS.

PROVIDE (30) COUNTERWEIGHT LINESETS.

INSTALL (5) MULTICABLE, ETHERNET CABLE "ELECTRICS" WITH ASSOCIATED CABLE MANAGEMENT AND STRAIN RELIEF.
INSTALL STRAIN RELIEF AT THE FIXED J-BOX (CATWALK LEVEL) AND AT THE PIPE BATTEN. (REFER TO TP SERIES - PERFORMANCE LIGHTING SYSTEM DRAWINGS) (COORDINATE WITH DIV. 116161 AND DIV. 26).

MAIN CURTAIN & MIDSTAGE TRAVELER INSTALLED ON H.D. STRAIGHT TRAVELER TRACKS (OPERATING END, STAGE LEFT)
PROVIDE 3'-0" OVERLAP AT STAGE CENTERLINE.

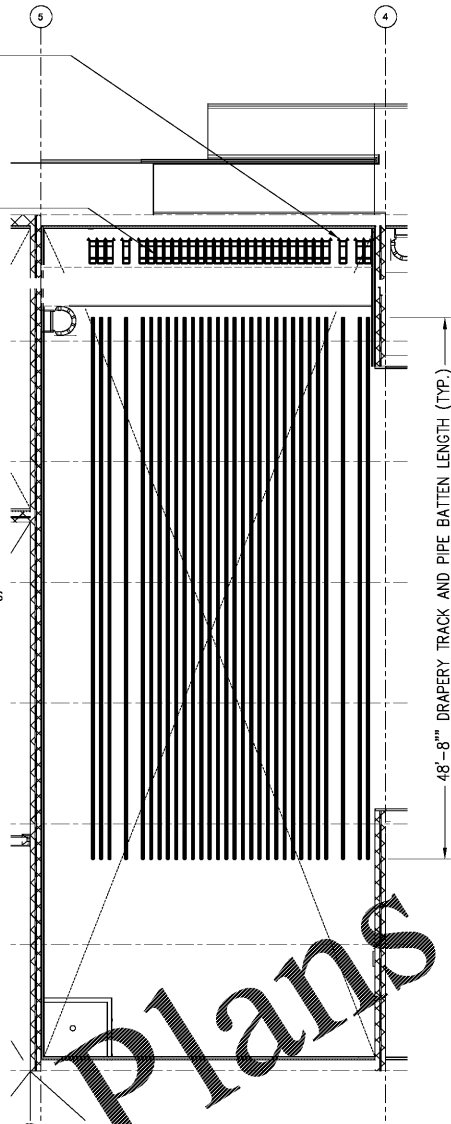

THEATER - LEVEL 02 FLOOR PLAN
SCALE: 1/8" = 1'-0"

DRAPERY SCHEDULE						
DRAPERY	SIZE: FINISHED DIMENSIONS	AMOUNT OF FULLNESS	FABRIC TYPE	LINING TYPE	COLOR NOTES	OTHER NOTES
MAIN BORDER	48'-0"W X 10'-0"H	75% SEWN IN	25 OZ IFR VELOUR	BLACK RANGER CLOTH	CUSTOM COLOR (BY ARCH.)	
MAIN DRAPERY	2 PANELS: EACH 25'-10"W X 23'-0"H	75% SEWN IN	25 OZ IFR VELOUR	BLACK RANGER CLOTH	CUSTOM COLOR (BY ARCH.)	INSTALL THE TRAVELER ON A HEAVY DUTY STRAIGHT TRACK USING THE PIPE BATTEN AS A "STRONG BACK".
BORDER #1	48'-0"W X 8'-0"H	NONE	25 OZ IFR VELOUR	NONE	BLACK	
LEGS	2 PANELS @ 14'-0"W X 23'-0"H	SEE NOTE	25 OZ IFR VELOUR	NONE	BLACK	INSTALL DRAPE TO PROVIDE 7" WIDTH WITH NO FULLNESS; FOLD EXTRA MATERIAL AT ON-STAGE EDGE.
BORDER #2	48'-0"W X 8'-0"H	NONE	25 OZ IFR VELOUR	NONE	BLACK	
MIDSTAGE TRAVELER	2 PANELS: EACH 25'-10"W X 23'-0"H	NONE	25 OZ IFR VELOUR	NONE	BLACK	INSTALL THE TRAVELER ON A HEAVY DUTY STRAIGHT TRACK USING THE PIPE BATTEN AS A "STRONG BACK".
BORDER #3	48'-0"W X 4'-0"H	NONE	25 OZ IFR VELOUR	NONE	BLACK	
LEGS #2	2 PANELS @ 14'-0"W X 23'-0"H	SEE NOTE	25 OZ IFR VELOUR	NONE	BLACK	INSTALL DRAPE TO PROVIDE 7" WIDTH WITH NO FULLNESS; FOLD EXTRA MATERIAL AT ON-STAGE EDGE.
BORDER #4	48'-0"W X 4'-0"H	NONE	25 OZ IFR VELOUR	NONE	BLACK	
LEGS #3	2 PANELS @ 14'-0"W X 23'-0"H	SEE NOTE	25 OZ IFR VELOUR	NONE	BLACK	INSTALL DRAPE TO PROVIDE 7" WIDTH WITH NO FULLNESS; FOLD EXTRA MATERIAL AT ON-STAGE EDGE.
BORDER #5	48'-0"W X 4'-0"H	NONE	25 OZ IFR VELOUR	NONE	BLACK	
LEGS #4	2 PANELS @ 14'-0"W X 23'-0"H	SEE NOTE	25 OZ IFR VELOUR	NONE	BLACK	INSTALL DRAPE TO PROVIDE 7" WIDTH WITH NO FULLNESS; FOLD EXTRA MATERIAL AT ON-STAGE EDGE.
SCRIM	48'-8"W X 23'-0"H	-	SHARKTOOTH	-	BLACK	TIE DRAPERY TO PIPE BATTEN
CYCLORAMA	48'-8"W X 24'-0"H	-	LENO	-	WHITE	TIE DRAPERY TO PIPE BATTEN
BLACKOUT CURTAIN	1 PANEL: 48'-8" W X 23'-0"H	NONE	25 OZ IFR VELOUR	NONE	BLACK	TIE DRAPERY TO PIPE BATTEN

2 DRAPERY SCHEDULE
NO SCALE

NOTES:

- EXPOSED ELEMENTS FINISHED IN FLAT BLACK (UNLESS NOTED OTHERWISE).
- VERIFY FIELD CONDITIONS AND DIMENSIONS.
- PROVIDE ALL FASTENERS WITH SELF LOCKING HARDWARE.

Order Plans @ WWW.DILine.com

FLEISCHMANGARCIA
ARCHITECTURE, INTERIORS & LIGHTING

FLORIDA ARCHITECT NO. 12518
FLORIDA INTERIOR DESIGN NO. 12518
FLORIDA LIGHTING DESIGN NO. 12518

TAMPA OFFICE: 400 N. GULF BLVD., SUITE 300, TAMPA, FLORIDA 33602
TEL: (813) 281-1881 FAX: (813) 281-1881

MIAMI OFFICE: 1101 BAYVIEW BLVD., SUITE 100, MIAMI, FLORIDA 33134
TEL: (305) 371-1881 FAX: (305) 371-1881

REGISTRATION NUMBER: CA 000123
www.fleischmangarcia.com

HILLSBOROUGH COUNTY
NEW TAMPA PERFORMING ARTS
CENTER
8550 HUNTERS VILLAGE RD.
TAMPA, FL 33647

THIS DESIGN AND DRAWING IS THE SOLE PROPERTY OF FLEISCHMANGARCIA. NO PART OF THIS WORK MAY BE REPRODUCED WITHOUT PRIOR WRITTEN PERMISSION FROM FLEISCHMANGARCIA.

I CERTIFY TO THE BEST OF MY KNOWLEDGE THAT THESE DRAWINGS COMPLY WITH ALL RELEVANT BUILDING CODES.

PERMIT SET

FGA PROJECT NUMBER
19048

ISSUE DATE
04-15-2020

REVISIONS		
NO.	DATE	NOTES

SHEET NAME
RIGGING & DRAPERIES 2FP

SHEET NUMBER
TR 1.02