

**X KEYNOTES**

1. ELECTRICAL CONTRACTOR SHALL MAKE CONNECTIONS BETWEEN THE OUTDOOR UNIT (HP-01) AND THE INDOOR UNITS (DFC-01) OF THE MINI-SPLIT SYSTEMS.
  2. EQUIPMENT DISCONNECT SWITCHES SHALL BE SUPPLIED AND PRE-WIRED FOR CONNECTION TO COOLER/FREEZER/STORAGE PACKAGE. E.C. SHALL MAKE ALL FINAL CONNECTIONS.
  3. PROVIDE ALL INTERLOCKING BETWEEN EVAPORATOR AND CONDENSER FOR A COMPLETE AND OPERATIONAL SYSTEM AS REQUIRED.
  4. PROVIDE CIRCUITRY FOR ELECTRIC DEFROST FROM COOLING UNIT TO FREEZER EVAPORATOR. REFERENCE POWER PLAN FOR COOLING REQUIREMENTS.
- REFER TO MANUFACTURER'S REQUIREMENTS FOR ICE MACHINE WIRING. CONNECT TO EXISTING EQUIPMENT.

**HFA**  
HARRISON FRENCH & ASSOCIATES, LTD.  
1705 S. Walton Blvd., Suite 3  
Bentonville, Arkansas 72712  
t 479.273.7780  
f 888.520.9685  
www.hfa-ae.com

STIPULATION FOR REUSE  
THIS DRAWING WAS PREPARED FOR USE ON A SPECIFIC SITE AT CLANTON, AL. THE DATE ON THIS DRAWING IS NOT TO BE USED FOR ANY OTHER PROJECTS. ANY REUSE OF THIS DRAWING FOR ANY OTHER PROJECTS WITHOUT THE WRITTEN PERMISSION OF HARRISON FRENCH & ASSOCIATES, LTD. IS PROHIBITED. REPRODUCTION OF THIS DRAWING FOR ANY OTHER PROJECTS WITHOUT THE WRITTEN PERMISSION OF HARRISON FRENCH & ASSOCIATES, LTD. IS PROHIBITED. UNAUTHORIZED REUSE OF THIS DRAWING IS PROHIBITED AND MAY BE CONTRARY TO THE LAW.

**REMODEL**  
STORE NUMBER: 369  
JOB NUMBER: 03-19-10368

ISSUE BLOCK

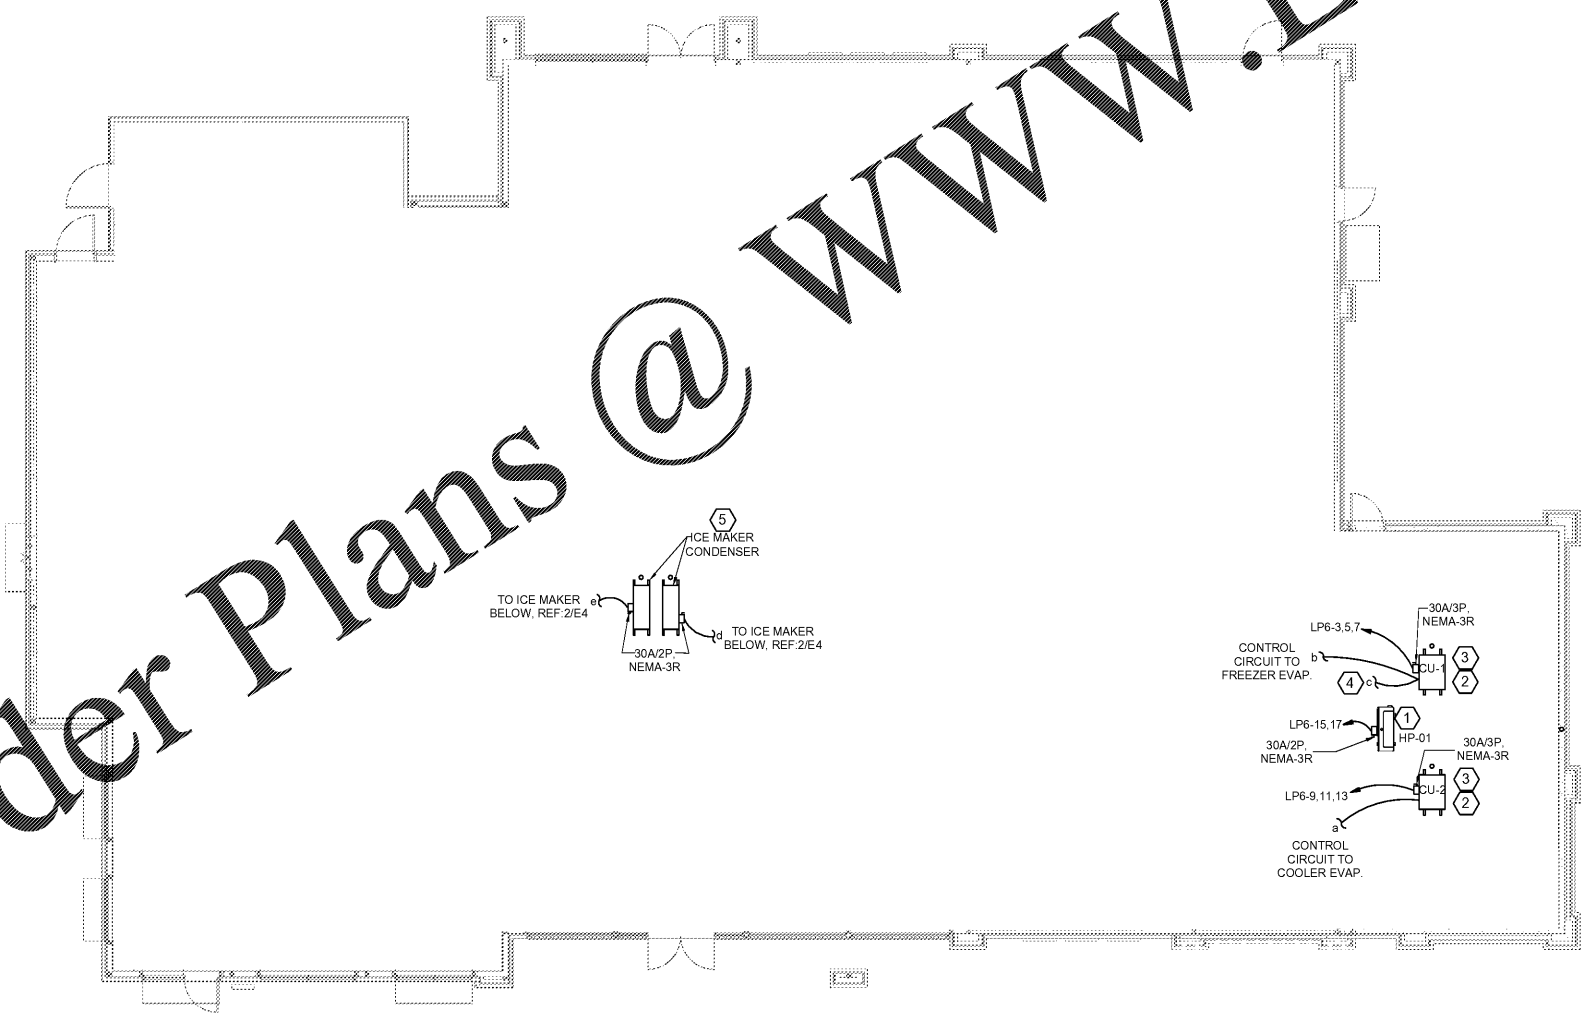

CHECKED BY: CAR  
DRAWN BY: DFF  
DOCUMENT DATE: 8/17/20



ROOF PLAN

SHEET: **E5**

Order Plans @ [www.LDILine.com](http://www.LDILine.com)



COORDINATE THE EXTENT OF ALL REQUIRED ELECTRICAL DEMOLITION WITH CONSTRUCTION MANAGER

EXISTING CONDITIONS WERE TAKEN FROM ORIGINAL DRAWINGS AND MAY NOT REFLECT EXACT "AS-BUILT" CONDITIONS. CONTRACTOR SHALL FIELD VERIFY ALL EXISTING CONDITIONS PRIOR TO SUBMITTING FINAL BIDS. CONTRACTOR SHALL CAREFULLY COORDINATE NEW WORK AND DEMOLITION WITH ALL OTHER DISCIPLINES AND EXISTING CONDITIONS.

EACH SUBCONTRACTOR IS RESPONSIBLE FOR HAVING A THOROUGH KNOWLEDGE OF ALL DRAWINGS AND SPECIFICATIONS IN THEIR RELATED FIELD. THE FAILURE TO ACQUAINT HIMSELF WITH THIS KNOWLEDGE DOES NOT RELIEVE THE RESPONSIBILITY OF PERFORMING HIS WORK PROPERLY. NO ADDITIONAL COMPENSATION SHALL BE ALLOWED BECAUSE OF CONDITIONS THAT OCCUR DUE TO FAILURE TO FAMILIARIZE WORKERS WITH THIS KNOWLEDGE.

**1 ROOF POWER PLAN**  
SCALE: 1/8" = 1'-0"

Aug 16, 2020, 1:04pm - User: Alex Fields  
M:\0303-19-10368-Clanton, AL\_369\CNDCCSMEP\_420 E5 ROOF PLAN.dwg