


POTABLE WATER PIPING NOTES:

- 1 - 3/4\"/>
- 2 - 1 1/2\"/>
- 3 - 2\"/>
- 4 - 1/2\"/>
- 5 - 3/4\"/>
- 6 - 1/2\"/>
- 7 - 3/4\"/>
- 8 - 1/2\"/>
- 9 - 3/4\"/>
- 10 - 1\"/>
- 11 - 3/4\"/>
- 12 - 1/2\"/>
- 13 - 1/2\"/>
- 14 - 1/2\"/>
- 15 - 1 1/4\"/>
- 16 - 3/4\"/>
- 17 - POTABLE WATER & GAS PIPING IS LOCATED IN CEILING SPACE. (TYPICAL U.N.O.)
- 18 - ROUTE POTABLE WATER PIPING AS HIGH AS POSSIBLE
- 19 - 3/4\"/>
- 20 - ROUTE GAS PIPING AS HIGH AS POSSIBLE
- 21 - 1 1/4\"/>
- 22 - 3/4\"/>
- 23 - 3/4\"/>
- 24 - 1\"/>
- 25 - 2\"/>
- 26 - 2\"/>
- 27 - 1 1/4\"/>
- 28 - 1 1/4\"/>
- 29 - 3/4\"/>
- 30 - 1 1/4\"/>

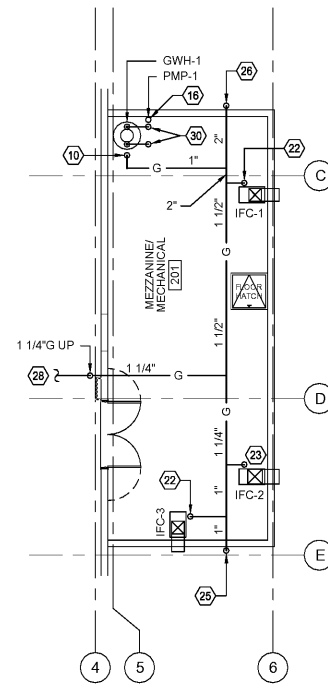


2 MEZZANINE POTABLE WATER AND GAS PIPING PLAN
P-201 SCALE: 1/8" = 1'-0"

Order Plans

www.LDILine.com

NOTE:
SEE PLUMBING FIXTURE SCHEDULE
FOR INDIVIDUAL FIXTURE RUN-OUT SIZES.


1 POTABLE WATER AND GAS PIPING PLAN
P-201 SCALE: 1/8" = 1'-0"

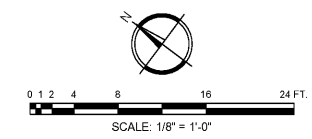

Stewart-Cooper-Newell
Architects
704.865.6311
www.scn-architects.com

Since 1980
Architects • Engineers • Landscape Architects
JOHNSON, LASCHOBER &
ASSOCIATES, P.C.
AUGUSTA, GA • MT. PLEASANT, SC
TEL (706) 724-5756 • TEL (843) 619-4656
FAX (706) 724-3935
WWW.THEJLAGROUP.COM

CLIENT: CITY OF NORTH AUGUSTA, SC
100 GEORGIA AVENUE, NORTH AUGUSTA, SC 29841
PROJECT NAME: NORTH AUGUSTA
FIRE STATION 1 RELOCATION
PROJECT LOCATION: 311 W. MARTINTOWN ROAD, NORTH AUGUSTA, SC 29841

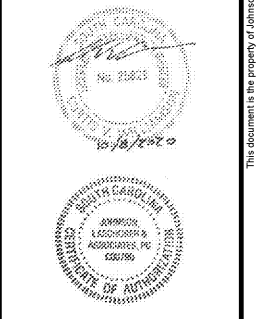

REV	DATE	BY	DESCRIPTION
0	10/08/20	CVW	ISSUED FOR BID

PROJECT NO. 3057.2003
DRAWN BY: WBR
CHECKED BY: CVW
DATE: 10/08/2020

SHEET TITLE:
**POTABLE WATER
AND GAS PIPING
PLANS**

SCALE: AS NOTED
DRAWING NO. **P-201**
REV: 0

This document is the property of Johnson, Laschober & Associates, P.C. The unauthorized reproduction, copying or otherwise use of this document is strictly prohibited and any infringement thereupon may be subject to legal action.