

METRO TRANSITION CENTER BATHROOM RENOVATIONS
 BUILDING A & C



GA DEPARTMENT OF CORRECTIONS
 300 PATROL DRIVE
 PO BOX 1529
 FORSYTH, GA 31029



CERTIFICATIONS

CONSULTANT		
------------	--	--

DATE	NO.	BY

REVISIONS

DATE	NO.	DESCRIPTION
5/26/20	1	FOR CONSTRUCTION

RELEASES

COPYRIGHT ©2019 RAYMOND ENGINEERING GA, INC
 ALL RIGHTS RESERVED. THIS DRAWING AND ITS REPRODUCTIONS ARE THE PROPERTY OF RAYMOND ENGINEERING GEORGIA, INC & MAY NOT BE REPRODUCED, PUBLISHED, OR USED IN ANY WAY WITHOUT THE PERMISSION OF RAYMOND ENGINEERING GEORGIA, INC. RETURN PRINTS TO RAYMOND ENGINEERING GEORGIA, INC UPON COMPLETION OF USE FOR WHICH THEY WERE ISSUED.

PROJECT NO.:	1080.022
DESIGN BY:	---
DRAWN BY:	EB
CHECKED BY:	---

BATHROOM 360 FLOOR PLAN - BUILDING C

P103

DEMOLITION NOTES

- DEMOLITION / CONSTRUCTION NOTES
- REMOVE ALL EXISTING SANITARY LINES UPSTREAM FROM THIS POINT. PREPARE FOR NEW CONNECTION (PLUMBING)
 - REMOVE ALL EXISTING SANITARY VENT LINES UPSTREAM FROM THIS POINT. PREPARE FOR NEW CONNECTION (PLUMBING)
 - REMOVE ALL EXISTING DOMESTIC WATER LINES DOWNSTREAM FROM THIS POINT. PREPARE FOR NEW CONNECTION (PLUMBING)
 - REMOVE ALL EXISTING PLUMBING FIXTURES. REPLACE WITH NEW. SEE SPECS FOR DETAILS. ** DENOTES RELOCATION OF FIXTURE/PIPEING AS INDICATED (PLUMBING).
 - REMOVE ALL EXISTING DUCTS AND REGISTERES DOWNSTREAM FROM THIS POINT. PREPARE FOR NEW CONNECTION. ** REMOVE ALL PRODUCT (MECHANICAL).
 - REPLACE EXISTING R.F. WITH NEW ROOF MOUNTED UNIT. SEE SCHEDULE FOR DETAILS. (MECHANICAL).

GENERAL PLUMBING NOTES


- INSTALL CLEANOUTS AT BOTTOM OF ALL DRAIN STACKS.
- INSTALL HAMMER ARRESTORS AT ALL FIXTURE SUPPLY LINES (BOTH HOT & COLD).
- LINE LOCATIONS AND SIZES ARE APPROXIMATED. CONTRACTOR MUST VERIFY ON SITE.
- INSTALL SHUT-OFF VALVES AT ALL FIXTURES
- PIPE SIZE AND SLOPES

PIPE O.D. & PITCH	F.U.
2" (1/4" / LIN.FT.)	21 F.U.
3"ø (1/8" / LIN.FT.)	36 F.U.
3"ø (1/4" / LIN.FT.)	42 F.U.
4"ø (1/8" / LIN.FT.)	180 F.U.


● CONNECTION POINT OF NEW WORK

FIXTURE LEGEND


ITEM	DESCRIPTION	PIPE SIZE		MANUF./MODEL
		SUPPLY	DRAIN	
WC	TOILET	1"	4"	WILLOUGHBY BETF-1459/M/A-12-TS-128-FV-SLL WITH FLUSH 128 GPF VALVE
LAV	LAVATORY	1/2"	2"	WILLOUGHBY HS-1014-98-HC-W-ACC-RPT-SS LAV. WALL MOUNTED
FCT	FAUCET	1/2"	-	KOHLER TRITON BOWE K-400120-484L-GP (CDE) ALL LAVATORIES
FD	FLOOR DRAIN	-	2"	ZURN (OR EQUIV. SELECTION BY CONTRACTOR)
SHR-1	SHOWER	1/2"	2"	WILLOUGHBY WBIS-FA-TPV-UBJ
SHR-2	SHOWER	1/2"	2"	WILLOUGHBY ADA WBIS-FA-TPV-UBJ

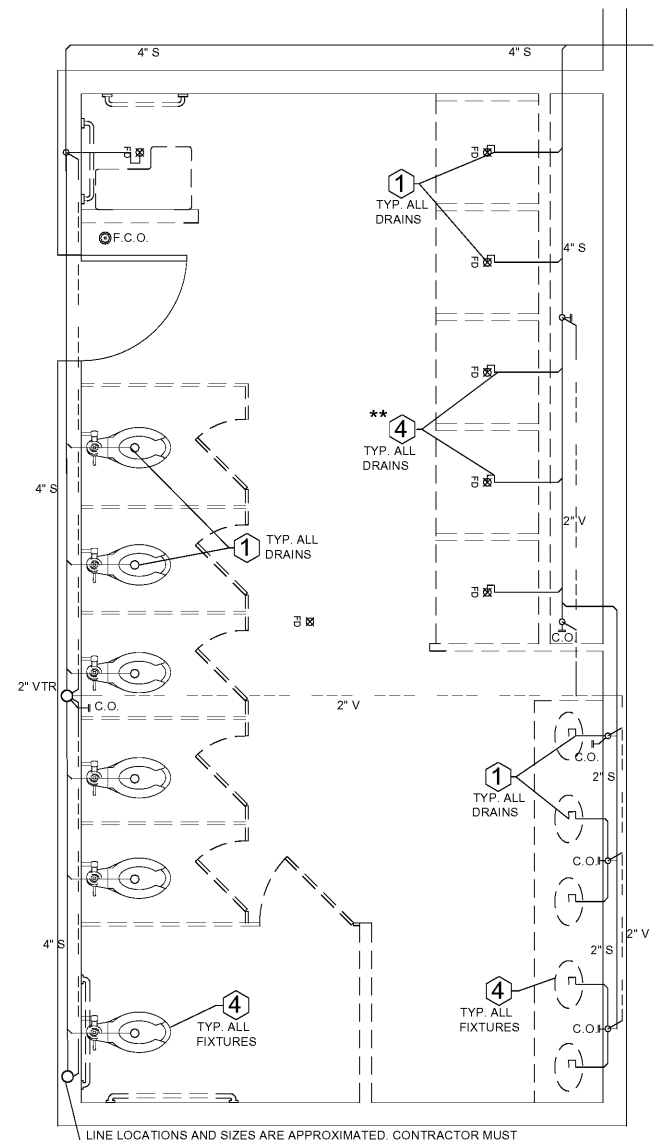


1 EXISTING BATHROOM 360 PLUMBING PLAN - BUILDING C
 SCALE: 1/2" = 1'-0"

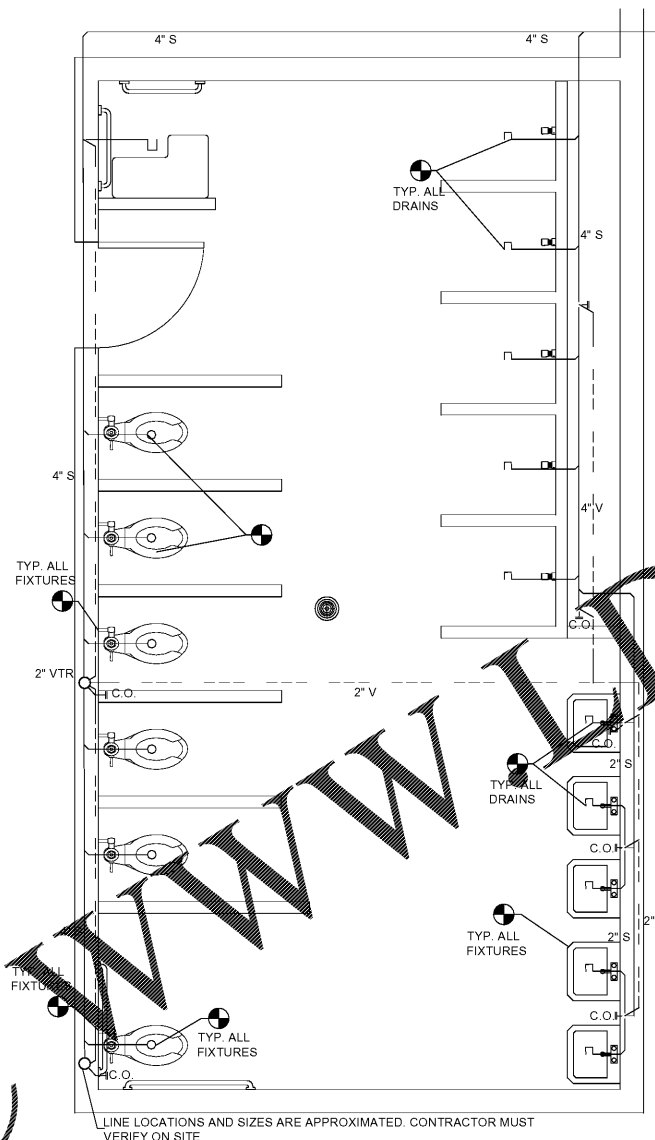

2 NEW BATHROOM 360 PLUMBING PLAN - BUILDING C
 SCALE: 1/2" = 1'-0"

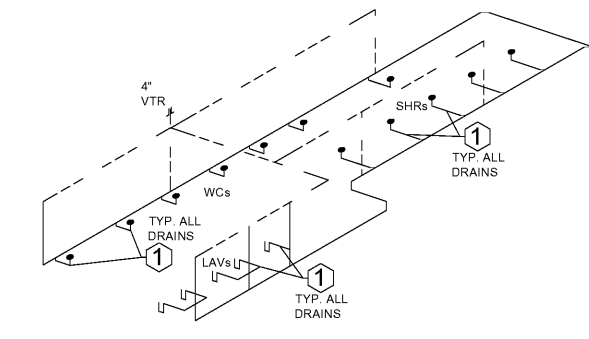

3 SEWER ISOMETRIC PLAN
 N.T.S.

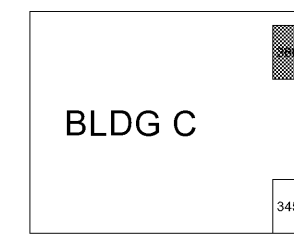

4 KEY PLAN
 NO SCALE

Order Plans @



www.DIline.com