

METRO TRANSITION CENTER BATHROOM RENOVATIONS  
 BUILDING A & C



GA DEPARTMENT OF CORRECTIONS  
 300 PATROL DRIVE  
 PO BOX 1529  
 FORSYTH, GA 31029



CERTIFICATIONS

CONSULTANT

DATE	NO.	BY

REVISIONS

DATE	NO.	DESCRIPTION
5/26/20	1	FOR CONSTRUCTION

RELEASES

COPYRIGHT ©2019 RAYMOND ENGINEERING-GA, INC  
 ALL RIGHTS RESERVED. THIS DRAWING AND ITS REPRODUCTIONS ARE THE PROPERTY OF RAYMOND ENGINEERING-GA, INC & MAY NOT BE REPRODUCED, PUBLISHED, OR USED IN ANY WAY WITHOUT THE PERMISSION OF RAYMOND ENGINEERING-GA, INC. RETURN PRINTS TO RAYMOND ENGINEERING-GA, INC UPON COMPLETION OF USE FOR WHICH THEY WERE ISSUED.

PROJECT NO.:	1080.022
DESIGN BY:	---
DRAWN BY:	EB
CHECKED BY:	---

BATHROOM 345 FLOOR PLAN - BUILDING C

**P104**

DEMOLITION NOTES

- DEMOLITION / CONSTRUCTION NOTES
- REMOVE ALL EXISTING SANITARY LINES UPSTREAM FROM THIS POINT. PREPARE FOR NEW CONNECTION (PLUMBING)
  - REMOVE ALL EXISTING SANITARY VENT LINES UPSTREAM FROM THIS POINT. PREPARE FOR NEW CONNECTION (PLUMBING)
  - REMOVE ALL EXISTING DOMESTIC WATER LINES DOWNSTREAM FROM THIS POINT. PREPARE FOR CONNECTION (PLUMBING)
  - REMOVE ALL EXISTING PLUMBING FIXTURES AND REPLACE WITH NEW. SEE SPECS FOR DETAILS. \*\* DENOTES RELOCATION OF FIXTURE/PIPING AS INDICATED (PLUMBING).
  - REMOVE ALL EXISTING SUCRS AND REGISTERS DOWNSTREAM FROM THIS POINT. PREPARE FOR NEW CONNECTION. \*\* REMOVE ALL EXIST DUCT (MECHANICAL).
  - REPLACE EXISTING ROOF WITH NEW ROOF MOUNTED UNIT. SEE SCHEDULE FOR DETAILS. (MECHANICAL).

GENERAL PLUMBING NOTES


- INSTALL CLEANOUTS AT BOTTOM OF ALL DRAIN STACKS.
- INSTALL HAMMER ARRESTORS AT ALL FIXTURE SUPPLY LINES (BOTH HOT & COLD).
- LINE LOCATIONS AND SIZES ARE APPROXIMATED. CONTRACTOR MUST VERIFY ON SITE.
- INSTALL SHUT-OFF VALVES AT ALL FIXTURES
- PIPE SIZE AND SLOPES
 

PIPE O.D. & PITCH	F.U.
2" (1/4" / LIN.FT.)	21 F.U.
3" (1/8" / LIN.FT.)	36 F.U.
3" (1/4" / LIN.FT.)	42 F.U.
4" (1/8" / LIN.FT.)	180 F.U.


➔ CONNECTION POINT OF NEW WORK

FIXTURE LEGEND


ITEM	DESCRIPTION	PIPE SIZE		MANUF./MODEL
		SUPPLY	DRAIN	
WC	TOILET	1"	4"	WILLOUGHBY BET-1490-FM-FA-12-TS-128-FV-SLL WITH FLUSH 128 OFF VALVE
LAV	LAVATORY	1/2"	2"	WILLOUGHBY HS-1014-96-HC-NV-ACC-RPT-SS-LAV. WALL MOUNTED
FCT	FAUCET	1/2"	-	KOHLER TRITON ROWE K-400120-4NKL-CP (OME) ALL LAVATORIES
FD	FLOOR DRAIN	-	2"	ZURN (OR EQUIV. SELECTION BY CONTRACTOR)
SHR-1	SHOWER	1/2"	2"	WILLOUGHBY WBS-FA-TPV-UBJ
SHR-2	SHOWER	1/2"	2"	WILLOUGHBY ADA WBS-FA-TPV-UBJ

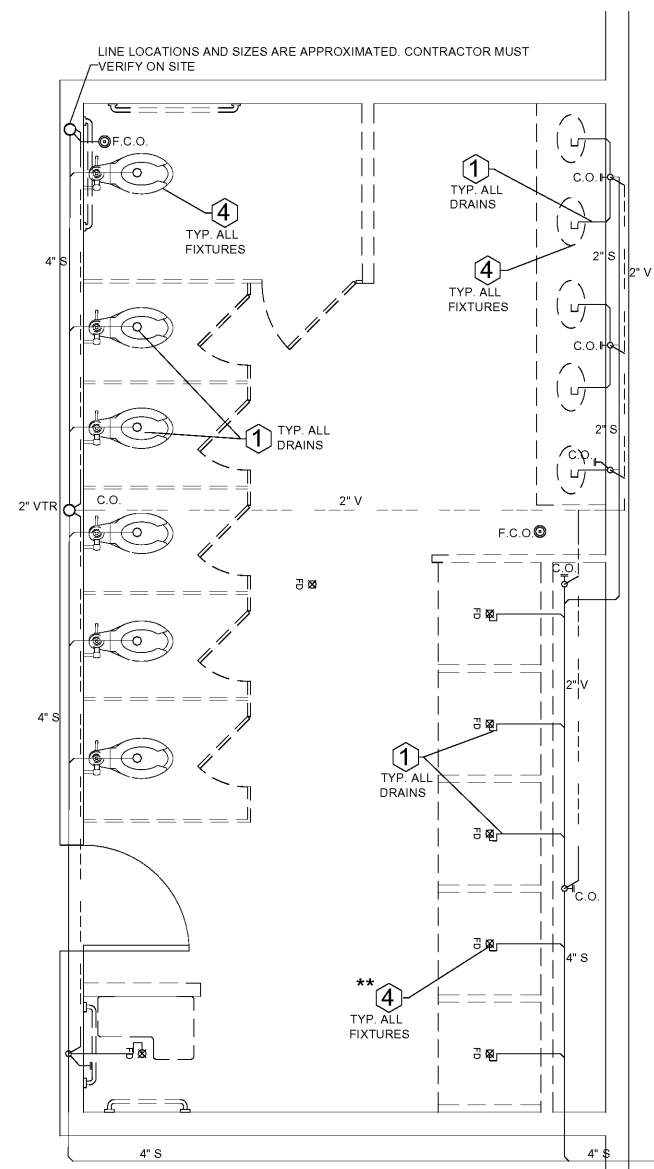


1 EXISTING BATHROOM 345 PLUMBING PLAN - BUILDING C  
 SCALE: 1/2" = 1'-0"

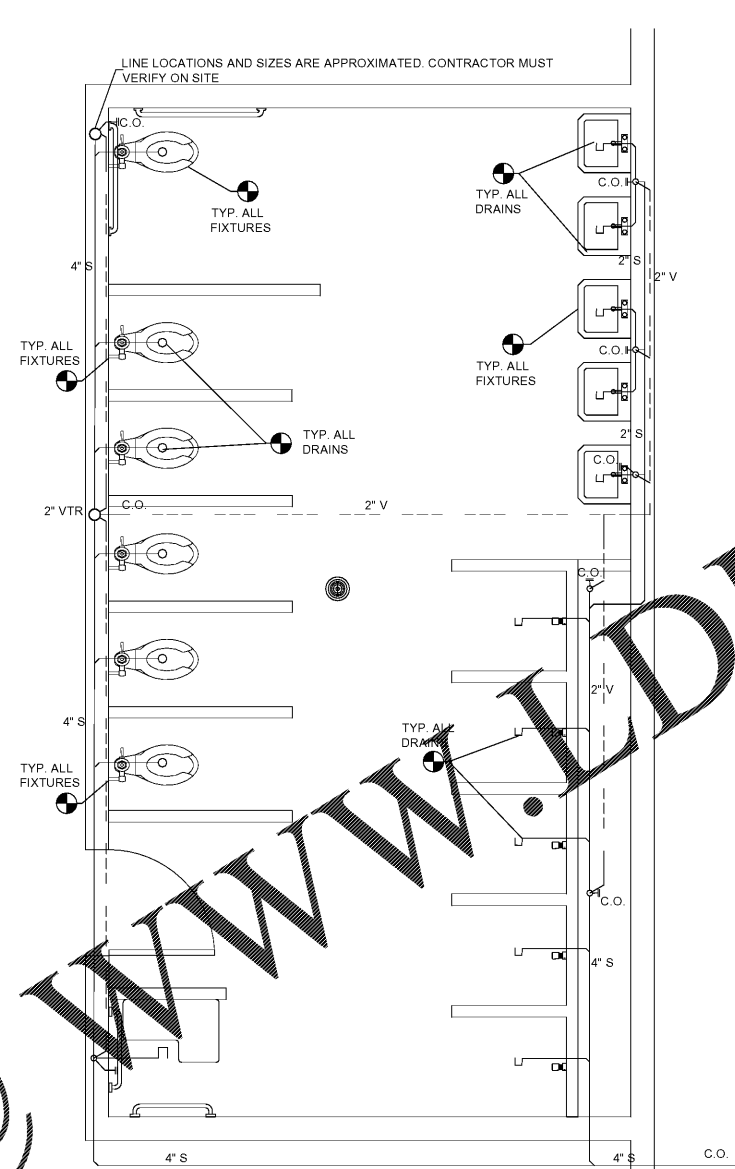

2 NEW BATHROOM 345 PLUMBING PLAN - BUILDING C  
 SCALE: 1/2" = 1'-0"

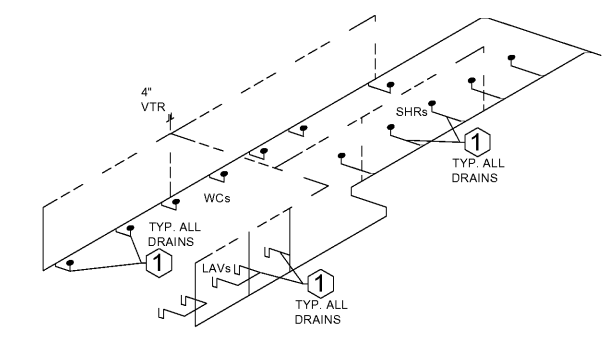

3 SEWER ISOMETRIC PLAN  
 N.T.S.

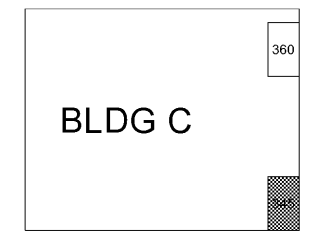

4 KEY PLAN  
 NO SCALE

Order Plans @

www.LDILine.com