




THIS DRAWING IS THE PROPERTY OF FIRESTONE RETAIL OPERATIONS, LLC AND IS LOANED TO THE EXPRESS CONDITION THAT IT IS TO BE USED ONLY FOR THE PROJECT AND SITE SPECIFICALLY IDENTIFIED HEREIN. THE ACCEPTANCE OF THIS DRAWING WILL BE CONSIDERED AS AN ACCEPTANCE OF THE FOREGOING CONDITION AND AS ADMISSION TO THE EXCLUSIVE OWNERSHIP IN AND TO THE DRAWING BY FIRESTONE RETAIL OPERATIONS, LLC.


NEW FCAC STORE
 2020 I
 283 DAWSONVILLE HIGHWAY SW
 GAINESVILLE, GA 30501

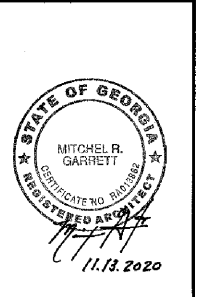


ISSUE BLOCK	
10/02/20	REV #2
11/13/20	IFC

PROPERTY NO.: 160109
 6 DIGIT NO.: 908074
 4 DIGIT NO.: 78H3
 AOR PROJECT NUMBER: 1955B55
 TO PERMIT DATE: 04/08/20
 TO BID DATE: ###-##-##
 KMP

SHEET TITLE:
REFLECTED CEILING PLAN
 SHEET NUMBER:
A2

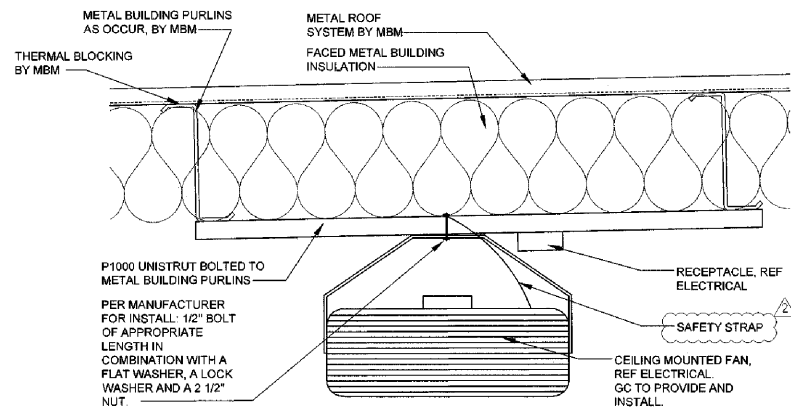


1 CEILING MOUNTED FAN
 SCALE: 1 1/2"=1'-0"

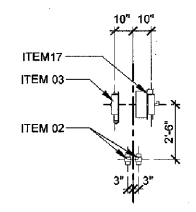

2 ENLARGED EQUIPMENT DETAIL
 SCALE: 1/4"=1'-0"

REFLECTED CEILING PLAN NOTES:
 1. LOCATE LIGHT FIXTURES CENTERED IN THE ROOM UNLESS OTHERWISE APPLIES, UNLESS DIMENSIONS NOTE OTHERWISE.
 2. SEE MECHANICAL AND ELECTRICAL SHEETS FOR SYMBOL SPECIFICATION.

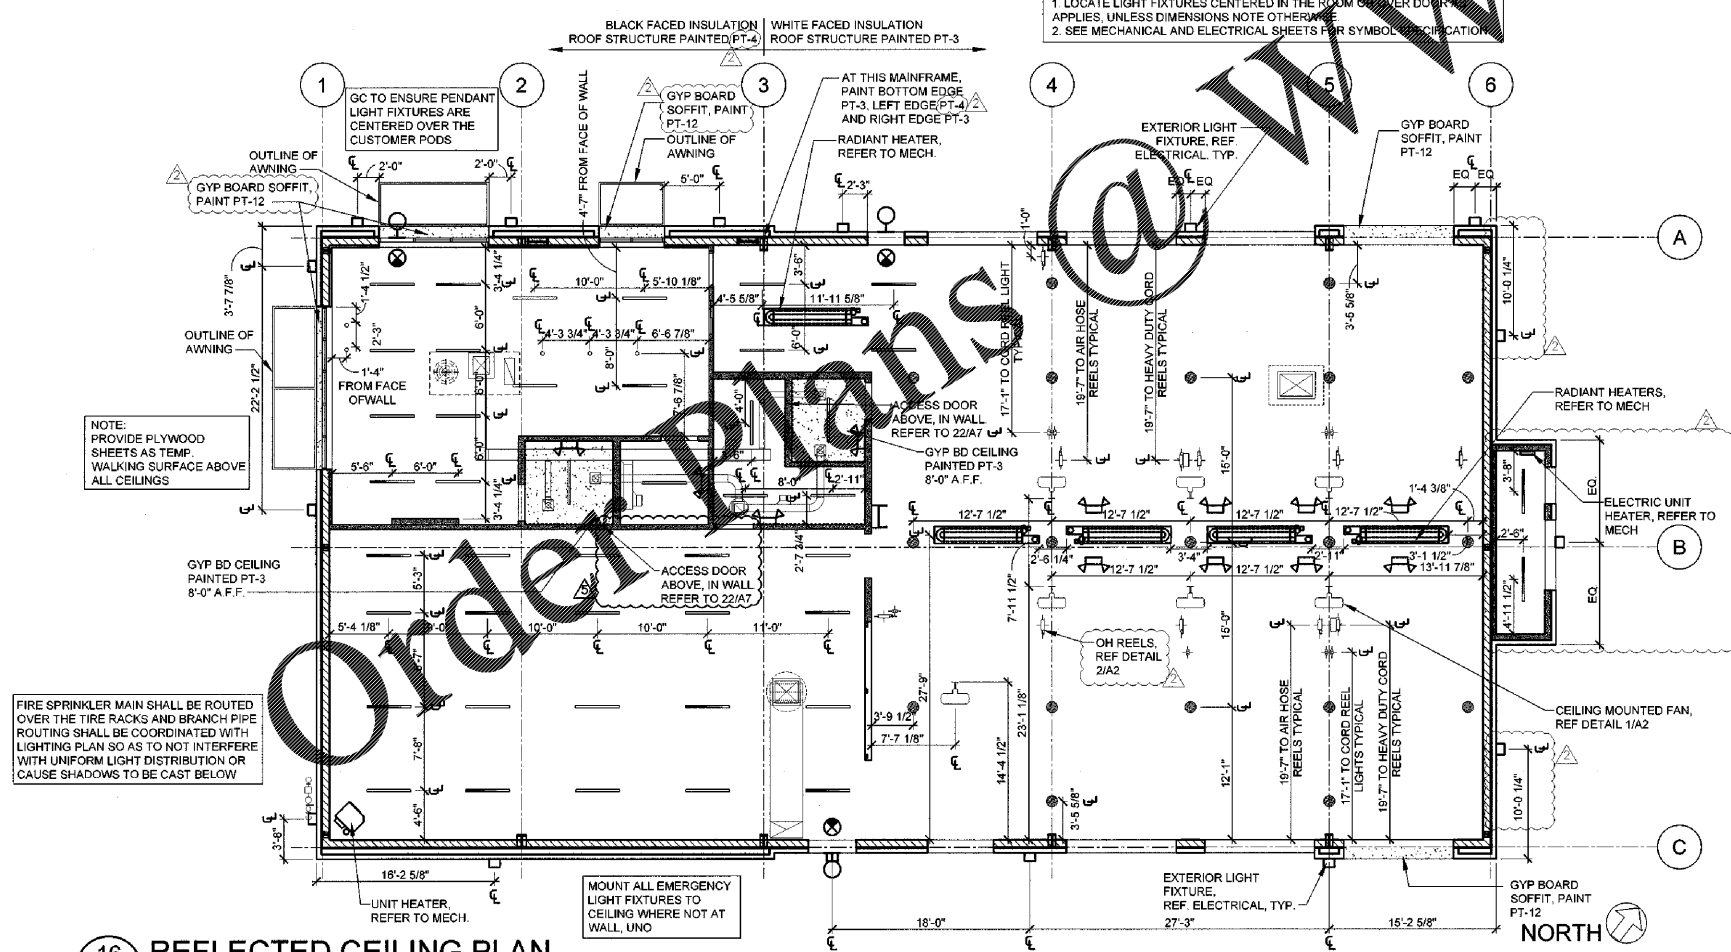

16 REFLECTED CEILING PLAN
 SCALE: 1/8"=1'-0"

11/13/2020 2:07pm - US73 arrow
 C:\Users\mgarrett\OneDrive\Documents\Projects\2020\2020 I\2020 I.dwg