


SITE LIGHTING PLAN GENERAL NOTES

- FURNISH AND INSTALL ALL CONDUIT, WIRE AND DEVICES REQUIRED FOR MONUMENT SIGN. VERIFY LOCATION AND REQUIREMENTS WITH SIGN MANUFACTURER PRIOR TO ROUGH-IN.
- PROVIDE ALL GROUNDING FOR MONUMENT SIGN PER MANUFACTURER'S AND LOCAL CODE REQUIREMENTS.
- REFERENCE PHOTOMETRIC SITE LIGHTING SHEET FOR THE FOLLOWING INFORMATION:
 - POLE SPECIFICATIONS
 - LIGHTING FIXTURE MOUNTING HEIGHT
 - LIGHTING FIXTURE SPECIFICATIONS
 - LIGHTING FIXTURE DESIGNATIONS
- REFER TO SHEET E2 FOR BUILDING MOUNTED LIGHT FIXTURE LOCATIONS AND DESIGNATIONS.
- ALL LIGHTING TO BE LOW LEVEL AND NON-SPILL.

Ⓢ SITE LIGHTING PLAN KEYNOTES

- REFERENCE SHEET E5 FOR CONTACTOR DIAGRAM AND PANELBOARD SCHEDULES.

SITE LIGHTING LAYOUT IS TO BE COORDINATED WITH CIVIL AND PHOTOMETRIC REQUIREMENTS.

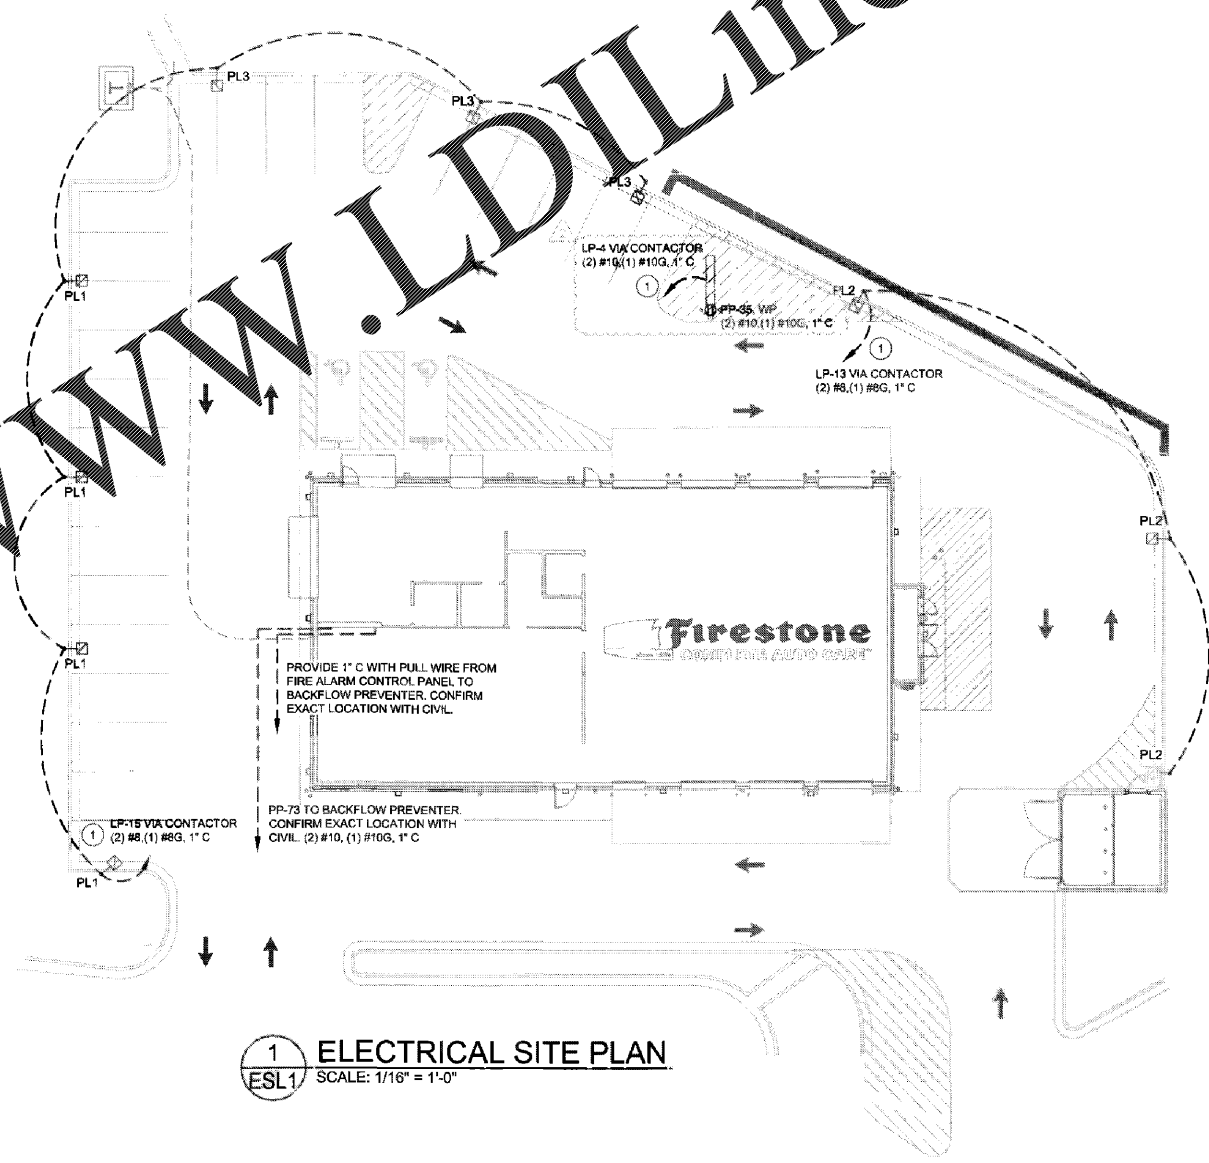

1 ELECTRICAL SITE PLAN
ESL1 SCALE: 1/16" = 1'-0"

Order Plans @ www.LDILine.com

Nov 12, 2020 1:26pm - USER: logcaline
G:\Projects\Firestone (Engineering)\2020\03\harr..._gainesville_gp\Sheet\ESL1_Site_Lighting_Plan.dwg



THIS DRAWING IS THE PROPERTY OF BRIDGESTONE RETAIL OPERATIONS, LLC AND IS LOANED ON THE EXPRESS CONDITION THAT IT IS NOT TO BE USED IN ANY MANNER WITHOUT THE WRITTEN PERMISSION OF BRIDGESTONE RETAIL OPERATIONS, LLC. ANY REPRODUCTION OR TRANSMISSION OF THIS DRAWING WITHOUT THE WRITTEN PERMISSION OF BRIDGESTONE RETAIL OPERATIONS, LLC IS STRICTLY PROHIBITED. BRIDGESTONE RETAIL OPERATIONS, LLC ASSUMES NO LIABILITY FOR ANY ERRORS OR OMISSIONS IN THIS DRAWING. THE DRAWING IS FOR INFORMATION ONLY AND IS NOT TO BE USED FOR CONSTRUCTION.

NEW FCAC STORE
2020 1
283 DAWSONVILLE HIGHWAY SW
GAINESVILLE, GA 30501



ISSUE BLOCK		
1	07/20/20	REV #1
2	10/02/20	REV #2
3	10/16/20	REV #4
4	11/13/20	IFC

PROPERTY NO.: 160109
8 DIGIT NO.: 908074
4 DIGIT NO.: 78H3
ACR PROJECT NUMBER: 1955865
TO PERMIT: DATE: 04/08/20
TO BID: DATE: ##-##-##

SHEET TITLE
SITE LIGHTING PLAN
SHEET NUMBER:
ESL1