

D·Z·A
ASSOCIATES, INC.

IL REG. # 104-001714
2625 Butterfield Road Suite 233N
Oak Brook, Illinois 60523
Phone 630 239 1020 www.dzarch.com

© 2019 D-Z-A ASSOCIATES, INC.
THE ARCHITECT SHALL BE DEEMED THE AUTHOR OF THESE DOCUMENTS AND SHALL BE RESPONSIBLE FOR ANY STATUTORY AND OTHER NOTICES, INCLUDING COPYRIGHT.


No.	Description	Date
▲	ISSUED FOR BID AND PERMIT	03/29/19
▲	ISSUED FOR BID	05/30/19
▲	RE-ISSUED FOR BID AND PERMIT	10/18/20

GENERAL NOTES:

- COORDINATE MECHANICAL WORK WITH ALL TRADES.

KEYED NOTES:

- SEE SCHEDULE AND DETAILS, SHEET M0.1.
- EQUIPMENT SHOWN FOR GENERAL REFERENCE ONLY. REFER TO NORTHERN TOOL+EQUIPMENT CONSTRUCTION DOCUMENTS FOR EQUIPMENT SCHEDULE AND HVAC REQUIREMENTS.

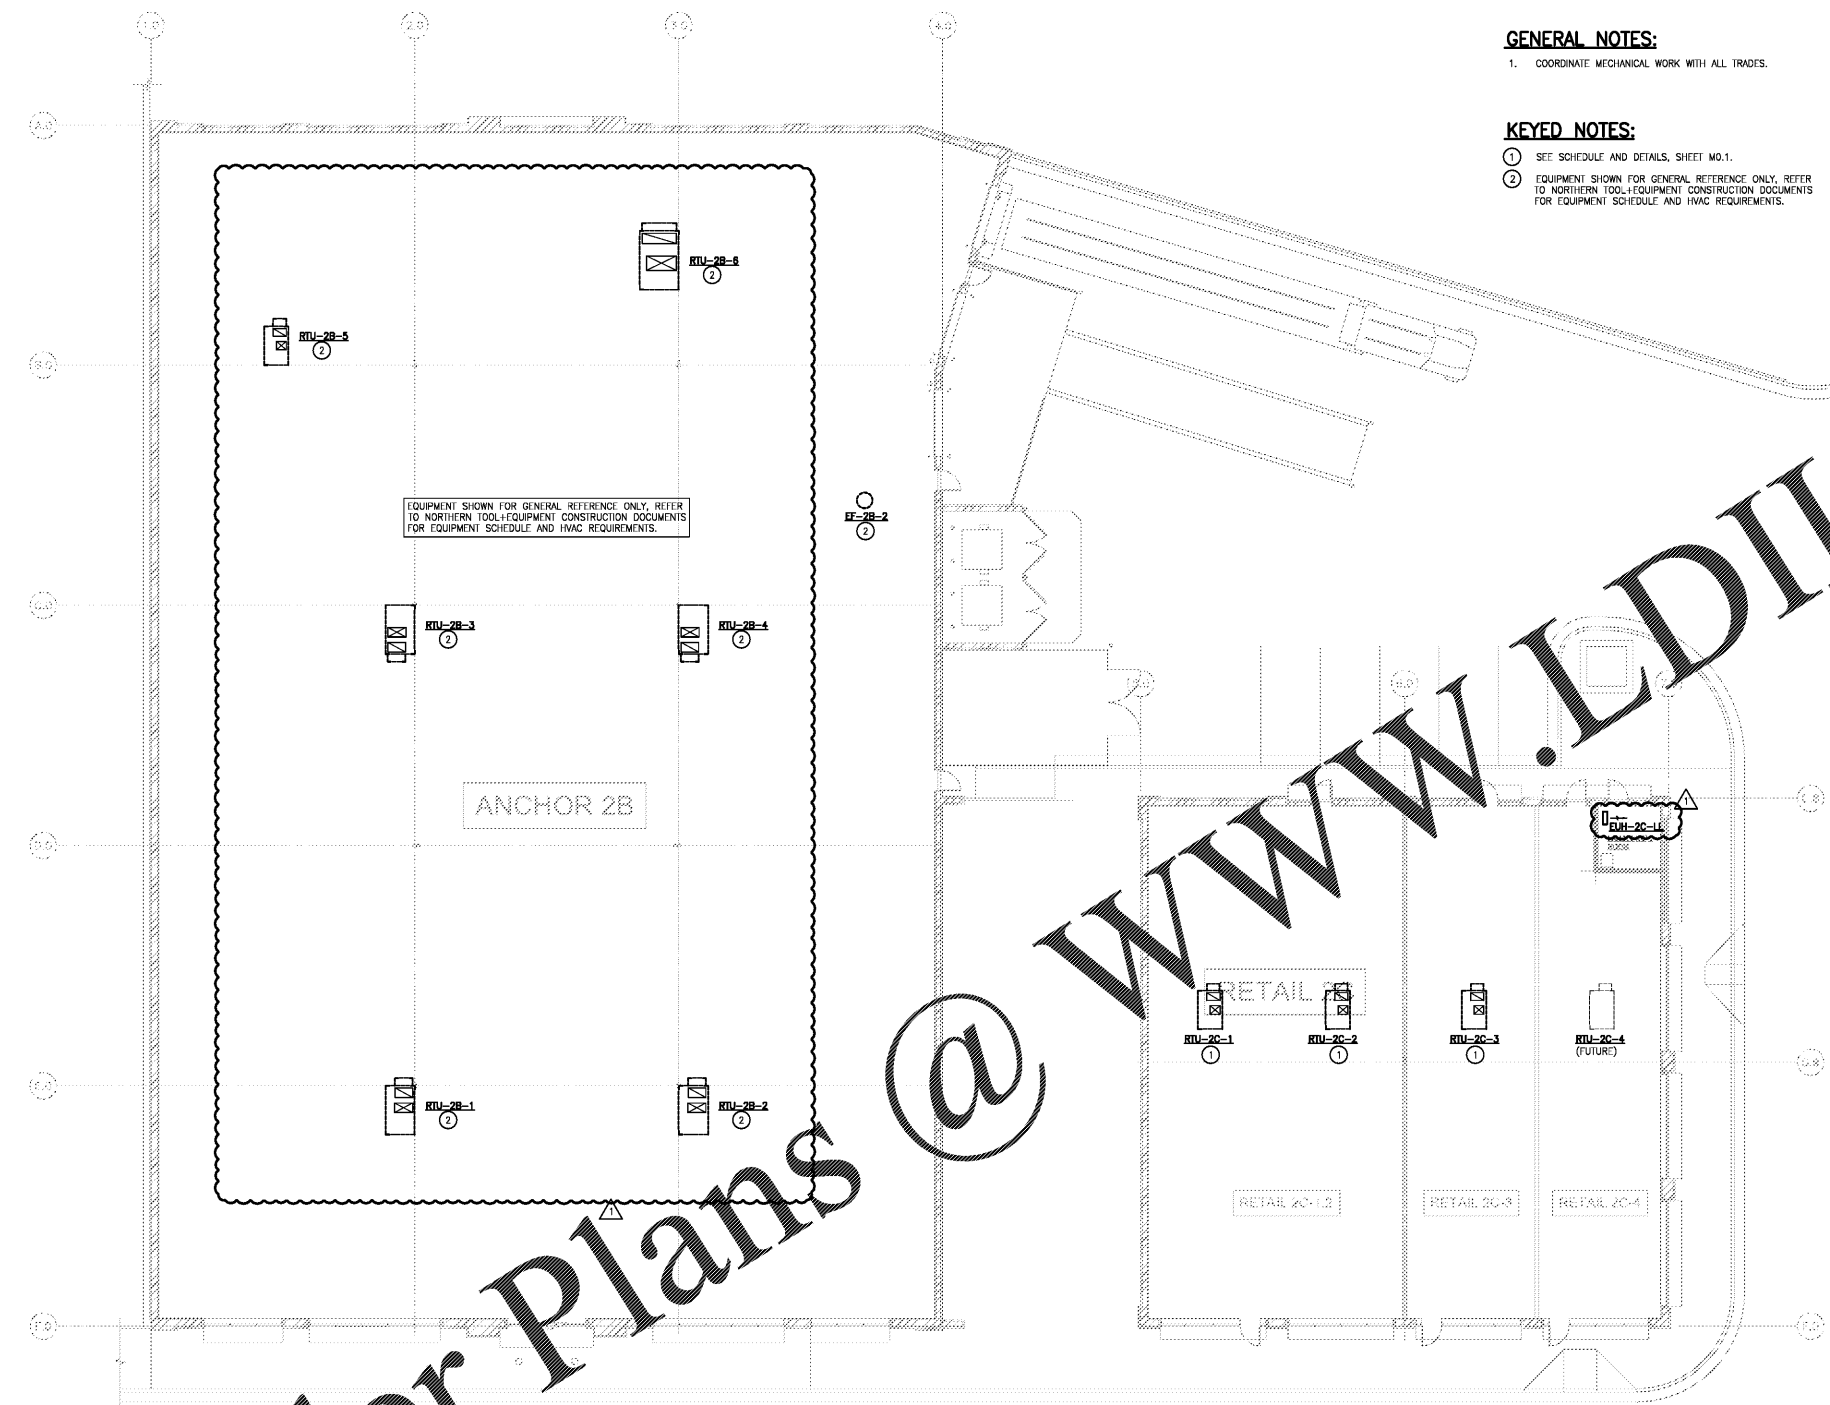

HVAC PLAN - ANCHOR 2B & RETAIL 2C
M1.1
SCALE: 3/32" = 1'-0"

Order Plans @

 
WWW.LDILine.com

Salem Gate Market

ANCHOR 2B AND RETAIL 2C

1454 AND 1460
OLD SALEM ROAD
CONYERS, GEORGIA

HVAC PLAN



Ray Group Consulting Engineers, Inc.
1877 Powers Ferry Road
Building 80, Suite 100
Atlanta, Georgia 30339
Tel. (770) 953-1448
Fax. (770) 953-9523

Date:	3/29/19	Drawn by:	SL	Sheet No.:	M1.1
Project No.:	18.110	Checked by:	KSM		(2)