


D·Z·A
ASSOCIATES, INC.

IL REG. # 104-001714
2625 Butterfield Road Suite 233N
Oak Brook, Illinois 60523
Phone 630 239 1020 www.dzarch.com

© 2019 D-Z-A ASSOCIATES, INC.
THE ARCHITECT SHALL BE DEEMED THE AUTHOR OF
THIS DOCUMENT AND SHALL BE RESPONSIBLE FOR
REVISIONS AND OTHER MATTER, INCLUDING EQUIPMENT.

No.	Description	Date
▲	ISSUED FOR BID AND PERMIT	03/29/19
▲	ISSUED FOR BID	05/30/19
▲	RE-ISSUED FOR BID AND PERMIT	10/16/20

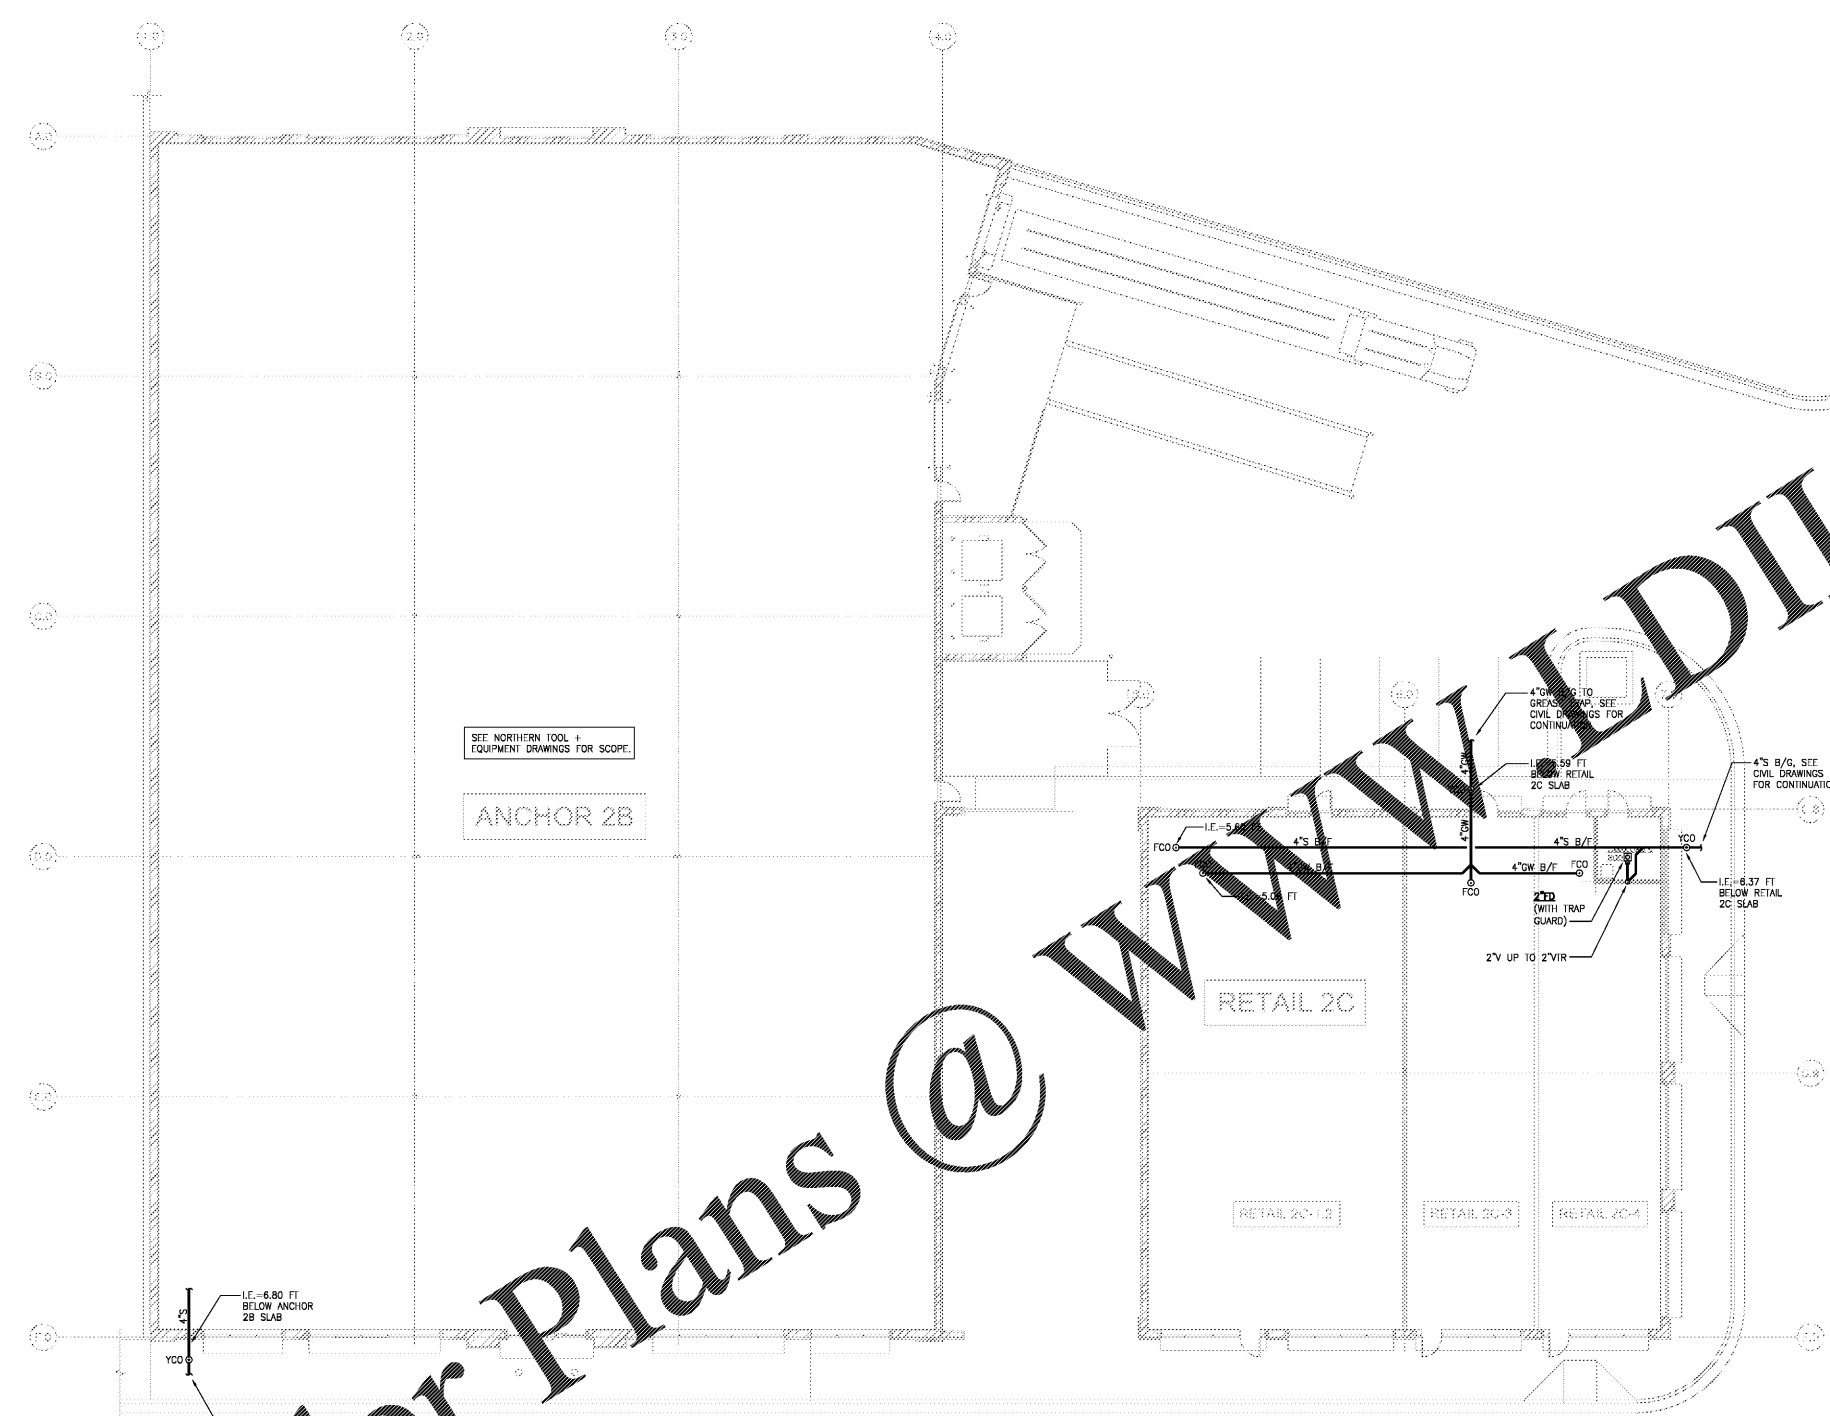

Order Plans @ WWW.DILine.com

1 SANITARY PLAN - ANCHOR 2B AND RETAIL 2C
P2.1 SCALE: 3/32" = 1'-0"

Salem Gate Market

ANCHOR 2B AND RETAIL 2C

1454 AND 1460
OLD SALEM ROAD
CONYERS, GEORGIA

PLUMBING SANITARY PLAN

CRAY Ray Group Consulting Engineers, Inc.
1877 Powers Ferry Road
Building 80, Suite 100
Atlanta, Georgia 30329
Tel. (770) 953-1448
Fax. (770) 953-4023

Date:	3/29/19	Drawn by:	MA	Sheet No.:	P2.1
Project No.:	18.110	Checked by:	KSM		(2)