


**D-Z-A**  
ASSOCIATES, INC.

IL REG. # 104-001714  
2625 Waterfield Road Suite 233N  
Oak Brook, Illinois 60523  
Phone 630 239 1020 www.dzarch.com

© 2019 D-Z-A ASSOCIATES, INC.  
THE ARCHITECT SHALL BE DEEMED THE AUTHOR OF  
THIS DOCUMENT AND SHALL BE RESPONSIBLE FOR  
REVISIONS AND OTHER MATTER, INCLUDING EQUIPMENT.

Rev. No.	Description	Date
▲	ISSUED FOR BID AND PERMIT	03/29/19
▲	ISSUED FOR BID	05/30/19
▲	RE-ISSUED FOR BID AND PERMIT	10/16/20

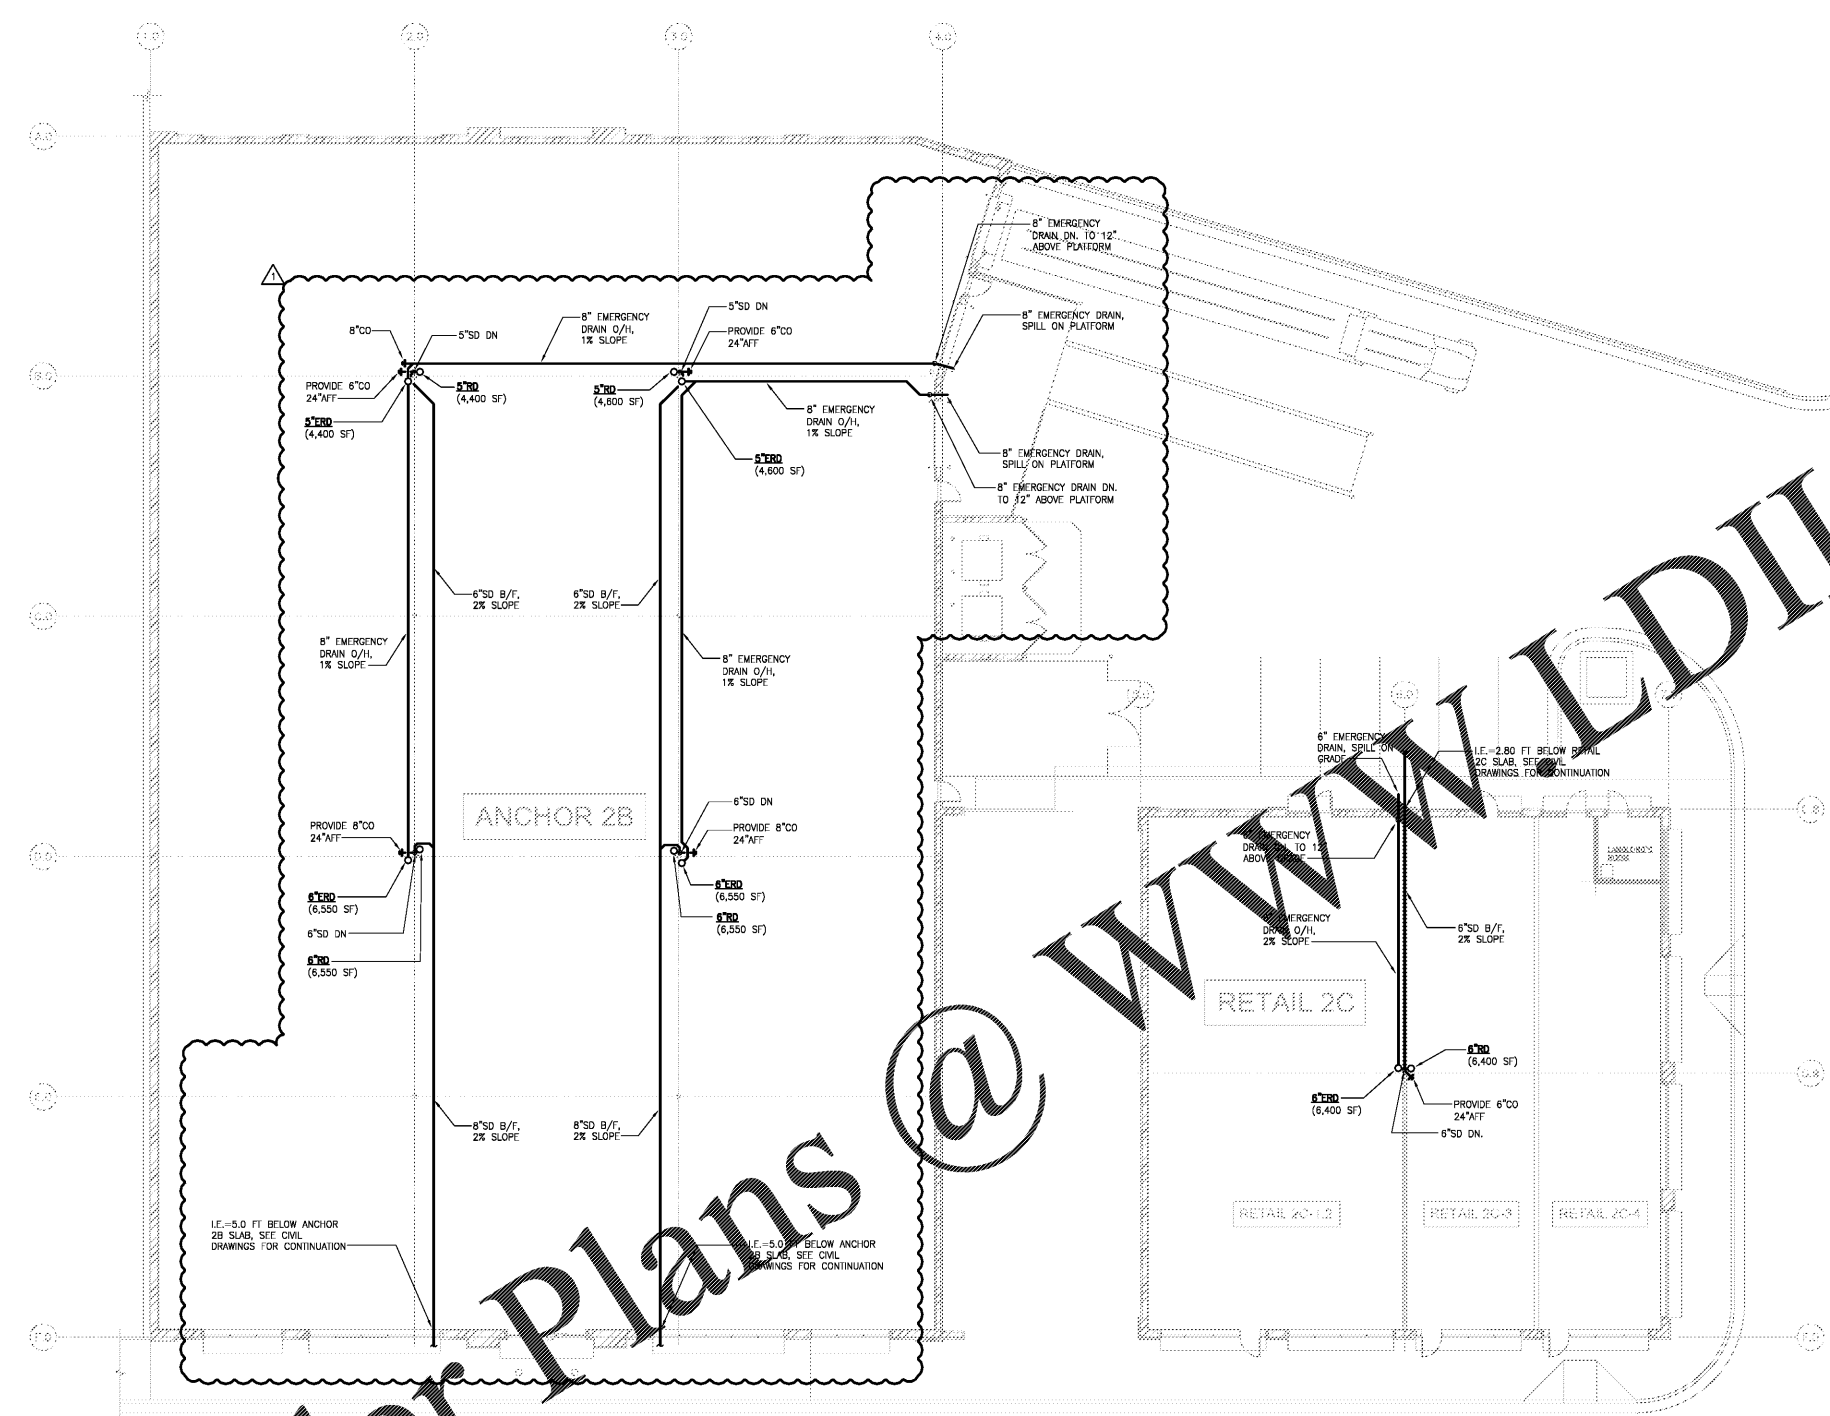

**ROOF DRAINAGE PLAN - ANCHOR 2B AND RETAIL 2C**  
P3.1 SCALE: 3/32" = 1'-0"


Order Plans @ WWW.LDILine.com

**Salem Gate Market**

 **ANCHOR 2B AND RETAIL 2C**

1454 AND 1460  
OLD SALEM ROAD  
CONYERS, GEORGIA

PLUMBING ROOF DRAINAGE PLAN



Date: 3/29/19  
Drawn by: SL  
Project No.: 18.110  
Rev: KSM  
Sheet No.: P3.1 (2)

Ray Group Consulting Engineers, Inc.  
1877 Powers Ferry Road  
Building 80, Suite 100  
Atlanta, Georgia 30329  
Tel: (770) 953-1448  
Fax: (770) 953-4023