


NORTHERN TOOL + EQUIPMENT  
ANCHOR 2B  
AT

Salem Gate  
Market

1454 OLD SALEM ROAD  
CONYERS, GEORGIA

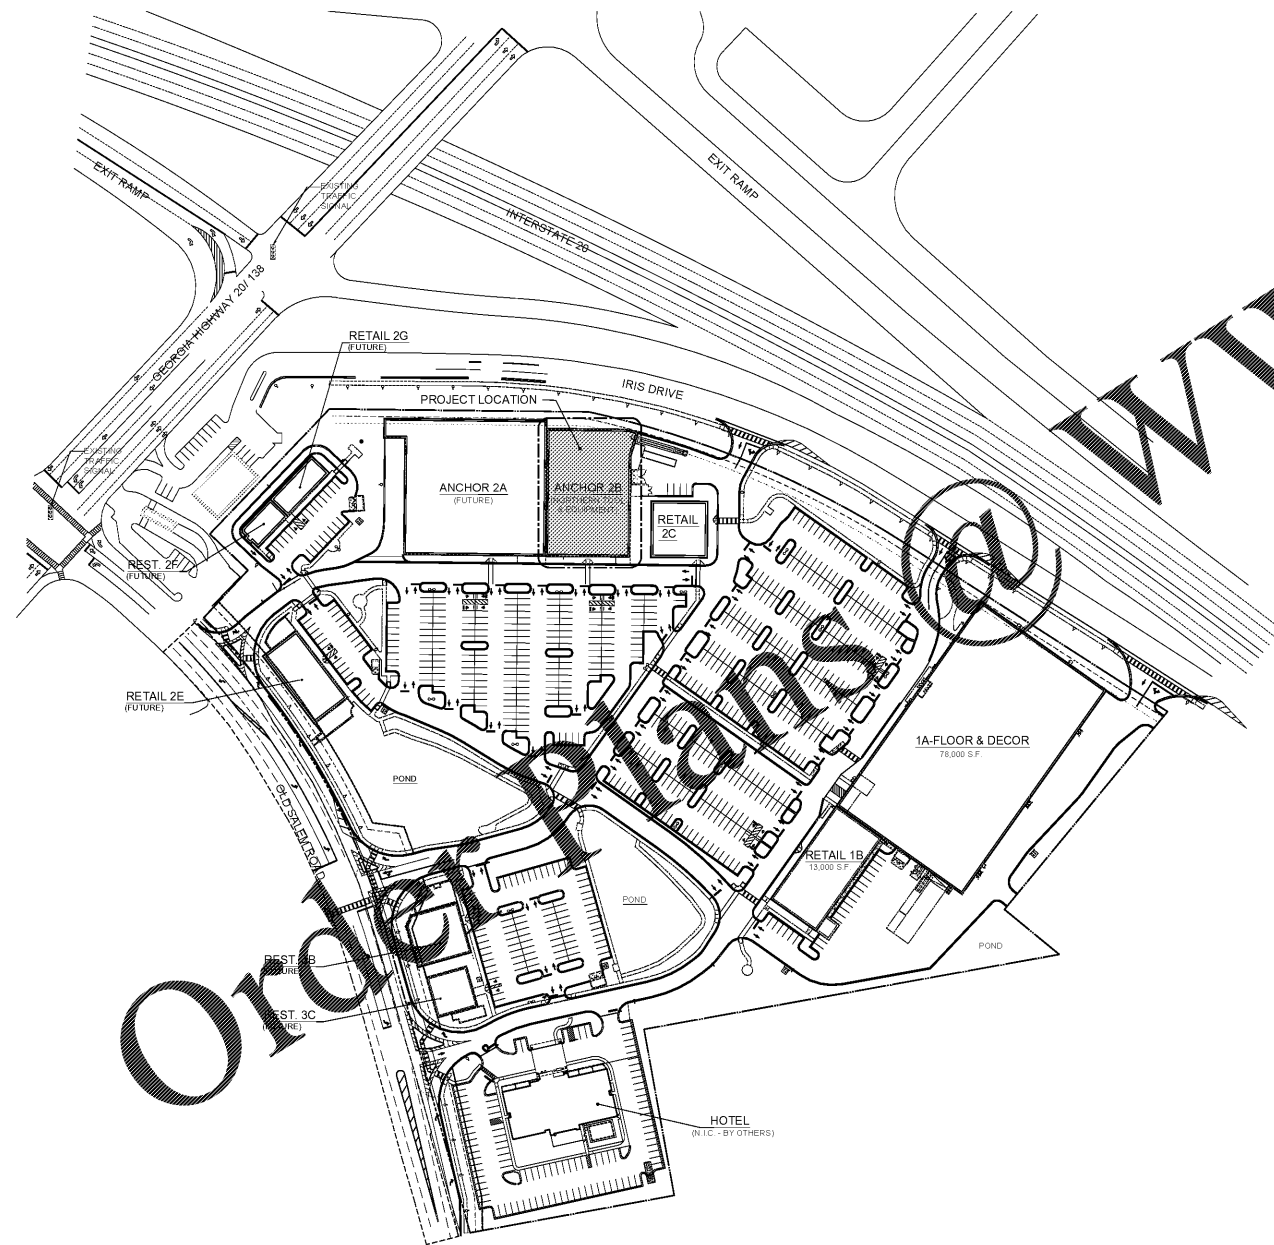


SITE PLAN  
SCALE: 1"=100'-0"



A SIGN PERMIT IS REQUIRED FOR EACH PROPOSED SIGN AND A SEPARATE REVIEW WILL BE COMPLETED WITH EACH SIGN PERMIT APPLICATION. ALL SIGNAGE SHALL COMPLY WITH CHAPTER 5 OF THE CONYERS MUNICIPAL CODE OF ORDINANCES.

THIS DRAWING PREPARED TO LOCATE THE "PROJECT" AND INDICATE SITE ORIENTATION ONLY (NOT FOR CONSTRUCTION) AND MAY NOT DEPICT ACTUAL PARKING STALLS, DRIVES, CURBS, ETC. SEE CIVIL DRAWINGS FOR DESIGN OF SITE IMPROVEMENTS.


Rycon Construction, Inc.  
Jessica Cisneros  
jicisneros@ryconinc.com  
Office: 770-771-0830

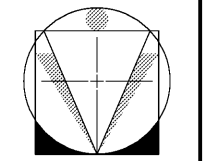

D.Z.A.  
ASSOCIATES, INC.

L. REG. # 184-001714 Suite 233N  
2625 Butterfield Road Oak Brook, Illinois 60523  
Phone: 630-230-1070 www.dzarch.com

LOCATION MAP

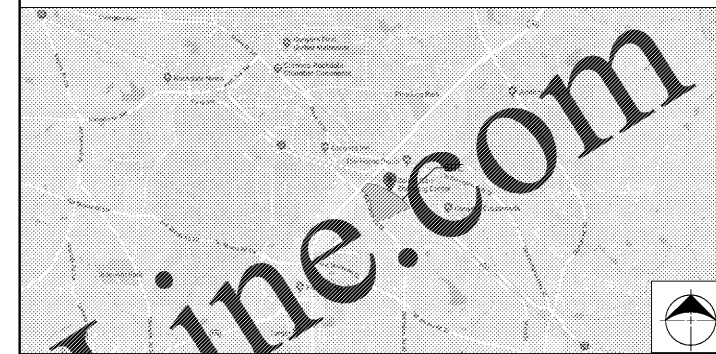

LOCAL AUTHORITIES

**CITY OF CONYERS**  
PLANNING AND INSPECTION SERVICES  
1174 1/2 Street S.E.  
Conyers, GA 30012  
(770) 929-4280

**FIRE DEPARTMENT - ROCKLAND COUNTY**  
14496 Rockbridge Road NW  
Conyers, GA 30012  
(770) 278-8401  
Jerry Wainwright - Fire Prevention Fire Marshal

ABBREVIATIONS

AFF	above finished floor	DAM	diameter	INCL	include (d), (ing)	PLT	plate
ACJUS	accusatorial	DM	dimension	ID	inside diameter	QT	quarry tile
ALI	alternans	DS	downspout	INSUL	insulate (d), (ing)	RAD	radius
ALUM	aluminum	DWG	drawings	INT	interior	RA	return air
A.S.	anchor bolt	DF	drinking fountain	INVT	inset	RCV	return air
ANOD	anodized	ELEC	electric	JC	janitor's closet	RD	roof drain
ARCH	architect (ural)	ELEV	elevation	LAM	laminated	RO	rough opening
BRG	bearing	EQ	equal	LAV	lavatory	SCD	schedule
BIT	bituminous	EXIST	existing	LH	left hand	SECT	section
BLK	block	EXTI	exterior	MFR	manufacture (or)	SM	similar
BLKG	blocking	FT	foot/feet	MIS	masonry	SC	solid core
BS	both sides	FTG	footing	MO	masonry opening	SPEC	specification (s)
SOI	bottom	FND	foundation	MAT	material (s)	SQ	square
B/	bottom of	GA	gage, gauge	MCH	mechanical	SIL	steel
BLDG	building	GALV	galvanized	MEI	metal	STRUC	structural
BRK	brick	GL	glass, glazing	MET	metal	SUSP	suspended
CLG	ceiling	GC	general contract (or)	MIS	miscellaneous	TOP	top of
CT	ceramic tile	GB	grab bar	MIN	minimum	TYP	typical
CLR	clear (once)	OP. BD.	operating board	NOM	nominal	VB	vapor barrier
COL	column	HCP	handicap	NOT IN CONTRACT	not in contract	VCI	vinyl composite tile
CONC	concrete	HVAC	heating/ventilation/air conditioning	NIS	not to scale	VERT	vertical
CMU	concrete masonry unit	OC	opening	ON CENTER (s)	on center (s)	WC	water closet
CONST	construction	OP	opposite	OP	opening	WWF	welded wire fabric
CONTR	contract (or)	OD	outside diameter	OPH	overhead	WO	wire
CONTR	contract (or)	OH	overhead	PAN	panel	WO	wood
C.J.	control joint	HORIZ	horizontal	PART	partition	WH	water heater
CONT	continuous	HS	hose bibb	PLA. LAM.	plastic laminate		

SYMBOLS LEGEND

MARK	DESCRIPTION	MARK	DESCRIPTION
	DETAIL NUMBER SHEET NUMBER		DOOR NUMBER
	ELEVATION SHEET NUMBER		ROOM NUMBER
	WALL SECTION NUMBER SHEET NUMBER		PARTITION TYPE
	COLUMN/GRID LINE		BEARING HEIGHT
			BEARING (EXISTING) HEIGHT

DRAWING INDEX

ARCHITECTURAL	MECHANICAL
T-1 TITLE SHEET	PM-000 MECHANICAL TITLE SHEET
A-100 FLOOR PLAN, KEYNOTES AND CODE DATA	M-100 HVAC PLAN
A-101 REFLECTED CEILING PLAN, GENERAL NOTES, DETAILS AND VENDOR LIST	M-200 HVAC DETAILS
A-300 ENLARGED TOILET PLAN, ELEVATIONS AND DETAILS	M-300 HVAC SCHEDULES
A-301 DETAILS	M-400 HVAC SPECIFICATIONS
A-400 DOOR SCHEDULE & TYPES, HARDWARE GROUPS	
A-401 ROOM & MISCELLANEOUS FINISH SCHEDULES AND PARTITION TYPES	
	PLUMBING
	P-100 PLUMBING WATER SUPPLY AND WASTE PLANS
	P-200 PLUMBING GAS PLAN
	P-300 PLUMBING DETAILS, SCHEDULES AND RISER DIAGRAMS
	P-400 PLUMBING SPECIFICATIONS
	ELECTRICAL
	E-000 ELECTRICAL SYMBOLS AND GENERAL NOTES
	E-100 LIGHTING PLAN
	E-200 POWER PLAN
	E-300 PANEL SCHEDULE & RISER DIAGRAM
	E-400 ELECTRICAL DETAILS
	EMS-1 EMS SPECIFICATIONS & DETAILS

© 2019 D.Z.A. ASSOCIATES, INC. THE ARCHITECT SHALL BE DEEMED THE AUTHOR OF THESE DOCUMENTS AND SHALL RETAIN ALL COMMON LAW, STATUTORY AND OTHER RIGHTS, INCLUDING COPYRIGHT.

Rev. No.	Description	Date
▲	ISSUED FOR BID AND PERMIT	03/29/19
▲	ISSUED FOR BID	05/30/19
▲	REISSUED FOR BID AND PERMIT	10/16/20



NORTHERN TOOL + EQUIPMENT



ANCHOR 2B  
1454 OLD SALEM ROAD  
CONYERS, GEORGIA

TITLE SHEET

Date	Drawn	Sheet No.
03/29/19	L.P.	T1.1
Project No.:	Scale:	
18.112	H.Z.	