


RETAIL 1B

AT

Salem Gate Market

CONYERS, GEORGIA

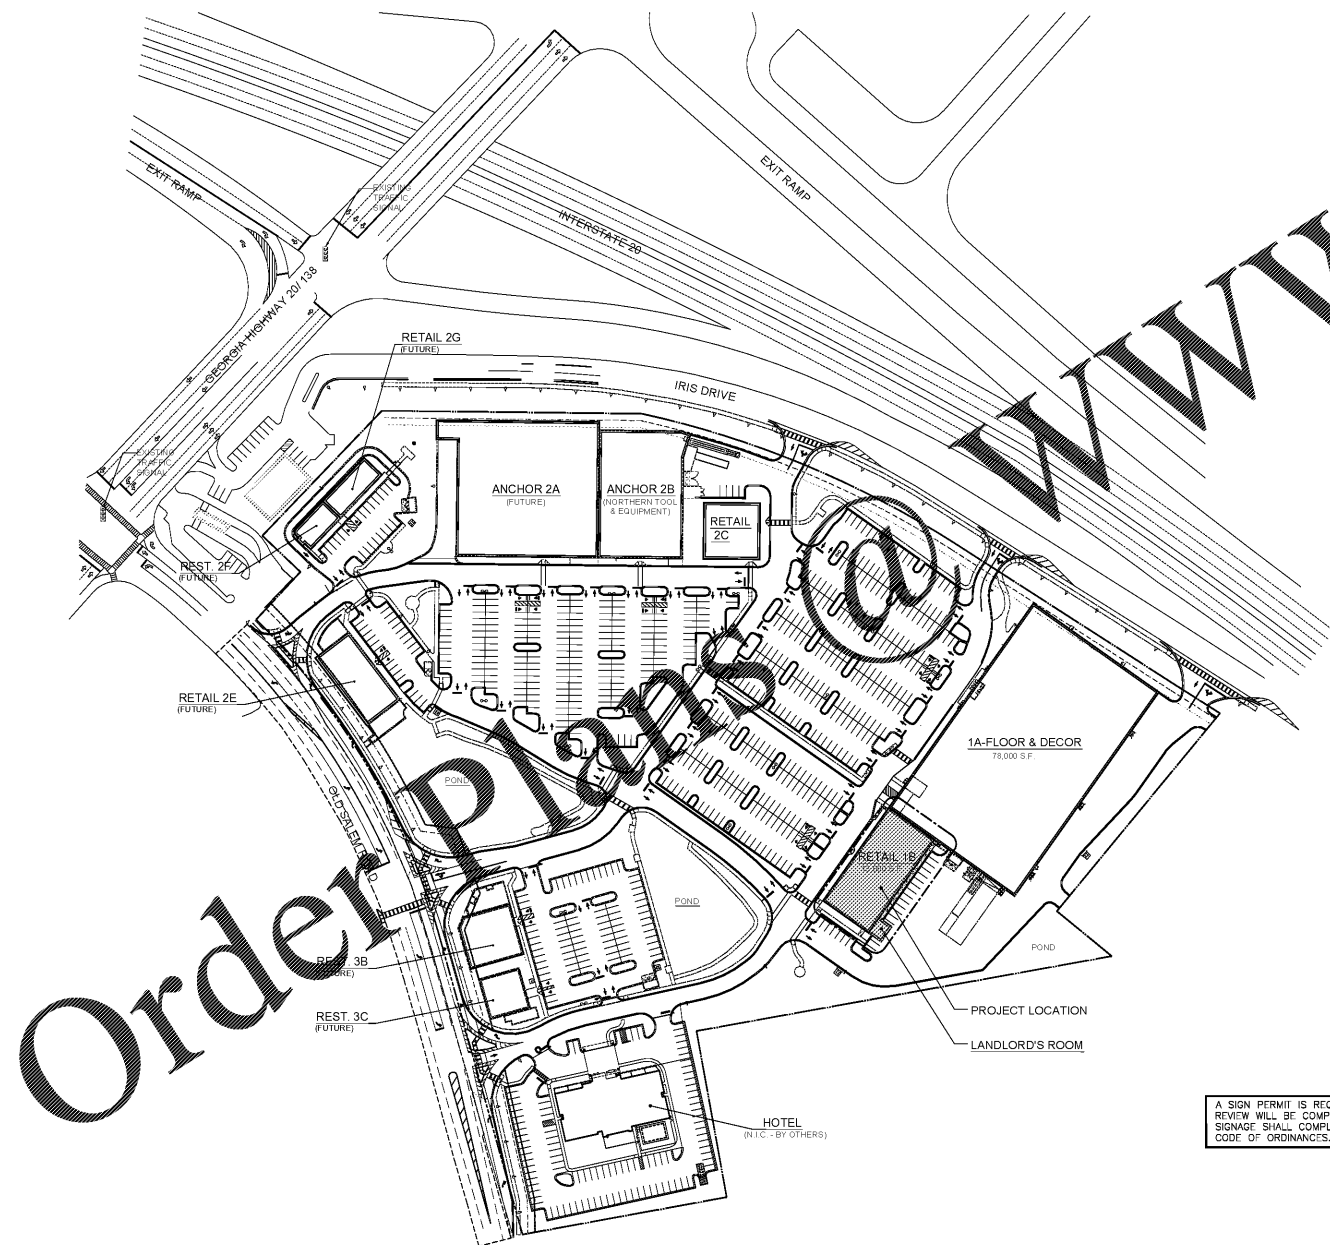

SITE PLAN

SCALE: 1"=100'-0"



A SIGN PERMIT IS REQUIRED FOR EACH PROPOSED SIGN AND A SEPARATE REVIEW WILL BE COMPLETED WITH EACH SIGN PERMIT APPLICATION. ALL SIGNAGE SHALL COMPLY WITH CHAPTER 5 OF THE CONYERS MUNICIPAL CODE OF ORDINANCES.

THIS DRAWING PREPARED TO LOCATE THE "PROJECT" AND INDICATE SITE ORIENTATION ONLY (NOT FOR CONSTRUCTION) AND MAY NOT DEPICT ACTUAL PARKING STALLS, DRIVES, CURBS, ETC. SEE CIVIL DRAWINGS FOR DESIGN OF SITE IMPROVEMENTS.

Rycon Construction, Inc.
Jessica Cisneros
 jcisneros@ryconinc.com
 Office: 770-771-0830

LOCATION MAP



LOCAL AUTHORITIES

CITY OF CONYERS
 PLANNING AND INSPECTION SERVICES
 1174 North Street, S.E.
 Conyers, GA 30012
 (770) 929-4280

FIRE DEPARTMENT - ROCKLAND COUNTY
 1498 Rockledge Road NW
 Conyers, GA 30012
 (770) 278-8401
 Jerry Wainwright - Fire Prevention Fire Marshal

ABBREVIATIONS


AFF	above finished floor	DWM	diameter	INCL	include (d), (ing)	PLT	plate
ACQUS	occupational	DM	dimension	ID	inside diameter	QI	quarry tile
ALT	alterrete	DS	downspout	INSUL	insulate (d), (ing)	RAD	radius
ALUM	aluminum	SWG	drinking fountain	INT	interior	RA	return air
A.B.	anchor bolt	DF	drinking fountain	INV	invert	REV	return air
ANOD	anodized	ELEC	electric	JC	junior's closet	RO	rough opening
ARCH	architect (oral)	ELEV	elevation	LAM	laminide	RO	rough opening
BRG	bearing	EQ	equal	LAV	lavatory	SCHED	schedule
BT	bituminous	EXIST	existing	LH	left hand	SECT	section
BLK	block	EXT	exterior	MFR	manufacture (or)	SIM	similar
BLKG	blocking	FT	foot/feet	MSS	masonry	SN	solid core
BS	both sides	FTG	footing	MO	masonry opening	SPEC	specification (s)
BOI	bottom	IND	foundation	MT	material (s)	SQ	square
B/	bottom of (specify material)	GALV	galvanized	MECH	mechanical	SIL	steel
BRK	brick	GL	glass, glazing	MET	metal	SIRUC	structural
BLDG	building	GC	general contract (or)	MINT	minimum	SUSP	suspended
C.C.	ceiling	GB	grab bar	MISC	miscellaneous	SUSP	suspended
CI	ceramic tile	GYP. BD.	gypsum board	NOM	nominal	T/	top of (specify material)
C.F.R	clear (ance)	HCP	handicap	NC	not in contract	TOP	top of (specify material)
COL	column	HWAC	heating/ventilation/air conditioning	NIS	not to scale	TYP	typical
CONC	concrete	HT	height	OC	on center (s)	VB	vapor barrier
CMU	concrete masonry unit	HC	hollow core	OPP	opposite	VCI	vinyl composite tile
CONST	construction	HM	hollow metal	ORP	opening	VERT	vertical
CONTR	contract (or)	HORIZ	horizontal	PH	partition	WC	water closet
CONT	control joint	HB	hose bib	PHL	partition	WIF	welded wire fabric
				PLA. LAM.	plastic laminate	WO	without
						WD	wood
						WH	water heater

SYMBOLS LEGEND

MARK	DESCRIPTION	MARK	DESCRIPTION
(#/A#)	DETAIL NUMBER	(#)	DOOR NUMBER
(#/S#)	SHEET NUMBER	(101)	ROOM NUMBER
(#/E#)	ELEVATION	(P-1)	PARTITION TYPE
(#/W#)	WALL SECTION NUMBER	T/OF EL. +0'-0"	BEARING HEIGHT
(#/S#)	SHEET NUMBER	T/OF EL. +0'-0"	BEARING (EXISTING) HEIGHT
(A)	COLUMN/GRID LINE		

DRAWING INDEX

ARCHITECTURAL		MECHANICAL	
T1.1	TITLE SHEET	MP0.1	HWAC, PLUMBING, AND FIRE PROTECTION SPECIFICATIONS
A1.1	FLOOR PLAN, GENERAL NOTES AND KEYNOTES	MO.1	HWAC GENERAL NOTES AND DETAILS
A1.2	SIDEWALK PLAN, KEYNOTES, AND DETAILS	M1.1	HWAC PLAN
A2.1	EXTERIOR ELEVATIONS		
A3.1	ROOF PLAN, DETAILS AND NOTES	PLUMBING	
A4.1	WALL SECTIONS	PO.1	PLUMBING AND FIRE PROTECTION GENERAL NOTES AND DETAILS
A4.2	WALL SECTIONS	P1.1	PLUMBING SUPPLY PLAN
A4.3	WALL SECTIONS	P2.1	PLUMBING SANITARY PLAN
A4.4	WALL SECTIONS	P3.1	PLUMBING ROOF DRAINAGE PLAN
A5.1	DETAILS		
A5.2	DETAILS	ELECTRICAL	
A5.3	ENLARGED TOILET ROOM PLAN, SCHEDULES AND DETAILS	EO.1	ELECTRICAL GENERAL
		EO.2	ELECTRICAL SITE PLAN
STRUCTURAL		E1.1	ELECTRICAL POWER PLAN
S1.1	GENERAL NOTES AND TYPICAL DETAILS	E2.1	ELECTRICAL LIGHTING PLAN
S1.2	SPECIAL INSPECTIONS	E3.1	ELECTRICAL RISERS AND PANEL BOARD SCHEDULES
S2.1	FOUNDATION PLAN AND PLAN NOTES	E4.1	ELECTRICAL LEGEND, NOTES AND ABBREVIATIONS
S3.1	FOUNDATION DETAILS		
S3.2	FOUNDATION DETAILS		
S4.1	TYPICAL C.M.U. DETAILS		
S5.1	TYPICAL C.M.U. DETAILS		
S6.1	ROOF FRAMING DETAILS		
S6.2	ROOF FRAMING DETAILS		

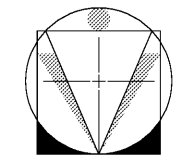

D.Z.A.
 ASSOCIATES, INC.

ILL. REG. # 184-001714 Suite 233N
 7025 Butterfield Road Oak Brook, Illinois 60521
 Phone: 630-230-1020 www.dzarc.com

© 2020 D-Z-A ASSOCIATES, INC. THE PROJECT SHALL BE DEEMED THE AUTHOR OF THIS DOCUMENT AND SHALL REMAIN UNDER THE EXCLUSIVE AND OTHER RIGHTS, INCLUDING COPYRIGHT.

Rev. No.	Description	Date
▲	ISSUED FOR BID AND PERMIT	10/16/20

Salem Gate Market

RETAIL 1B

CONYERS, GEORGIA

TITLE SHEET

Date	Drawn	Check No.
10/16/20	L.P.	
	H.Z.	
Project No.:	T1.1 (1)	
20.062		