


**D·Z·A**  
ASSOCIATES, INC.

IL REG. # 104-001714  
2625 Butterfield Road Suite 233N  
Oak Brook, Illinois 60523  
Phone 630-220-1020 www.dzainc.com

© 2010 D-Z-A ASSOCIATES, INC.  
THE ARCHITECT SHALL BE DEEMED THE AUTHOR OF  
THESE DOCUMENTS AND SHALL BE RESPONSIBLE FOR  
REVISIONS AND OTHER MATTERS, INCLUDING PERMITS.

Rev. No.	Description	Date
▲	ISSUED FOR BID AND PERMIT	10/16/20

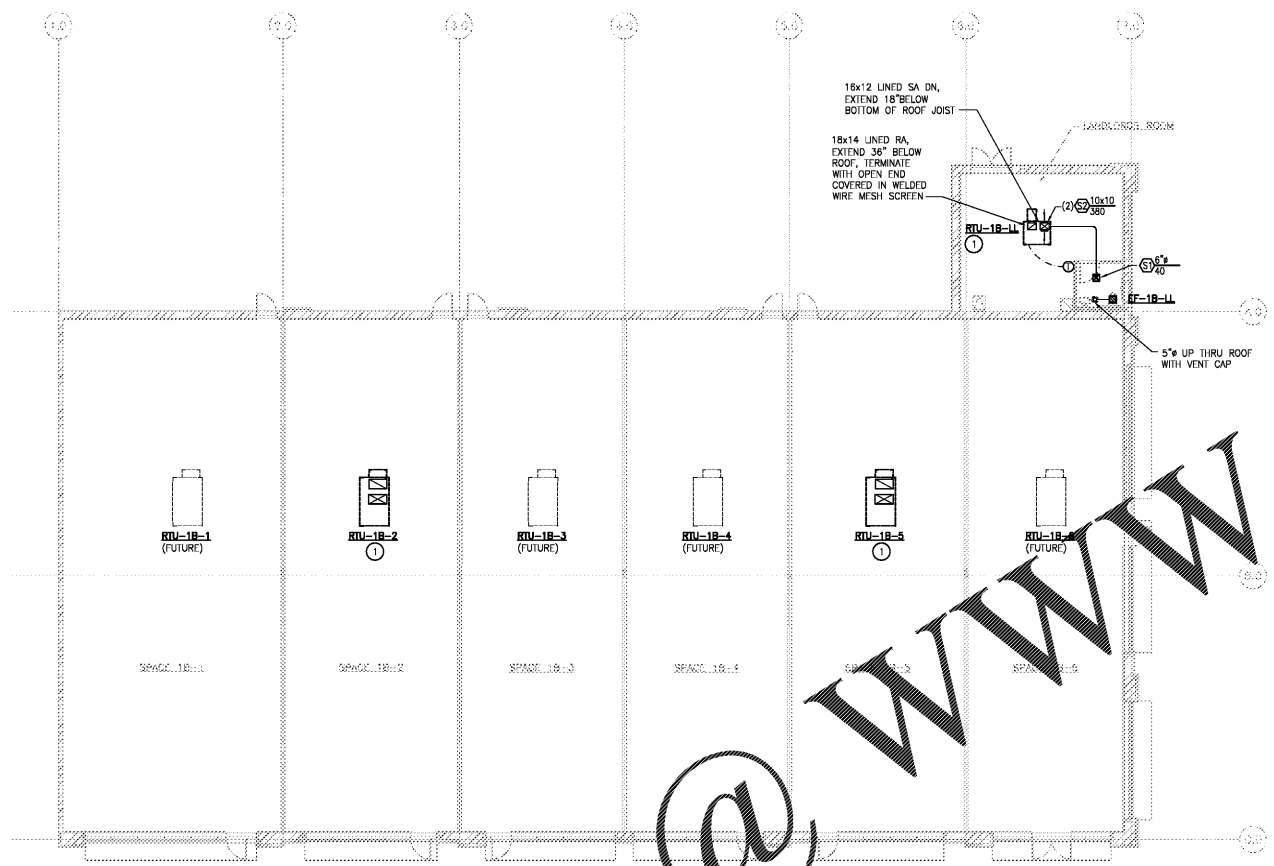

**GENERAL NOTES:**  
1. COORDINATE MECHANICAL WORK WITH ARCHITECT'S.

**KEYED NOTES:**  
① SEE SCHEDULE AND DETAILS FOR EQUIPMENT.

N  
HVAC PLAN - RETAIL 1B  
SCALE: 1/2" = 1'-0"

Order Plans @ [www.LDILine.com](http://www.LDILine.com)

**Salem Gate Market**

RETAIL 1B

CONYERS, GEORGIA

HVAC PLAN

**RAY** Ray Group Consulting Engineers, Inc.  
1877 Powers Ferry Road  
Building 20, Suite 100  
Atlanta, Georgia 30329  
Tel. (770) 963-1448  
Fax. (770) 963-4023

Date:	10/16/20	Drawn by:	SL	Sheet No.:	M1.1
Project No.:	20.062	Checked by:	KSM		(1)