


D·Z·A
ASSOCIATES, INC.

IL REG. # 104-001714
2625 Butterfield Road Suite 233N
Oak Brook, Illinois 60523
Phone 630-220-1020 www.dzai.com

© 2009 D-Z-A ASSOCIATES, INC.
THE ARCHITECT SHALL BE DEEMED THE AUTHOR OF
THESE DOCUMENTS AND SHALL BE RESPONSIBLE FOR
REVISIONS AND OTHER MATTERS, INCLUDING EQUIPMENT.

Rev. No.	Description	Date
▲	ISSUED FOR BID AND PERMIT	10/16/20

Order Plans @ www.LDILine.com

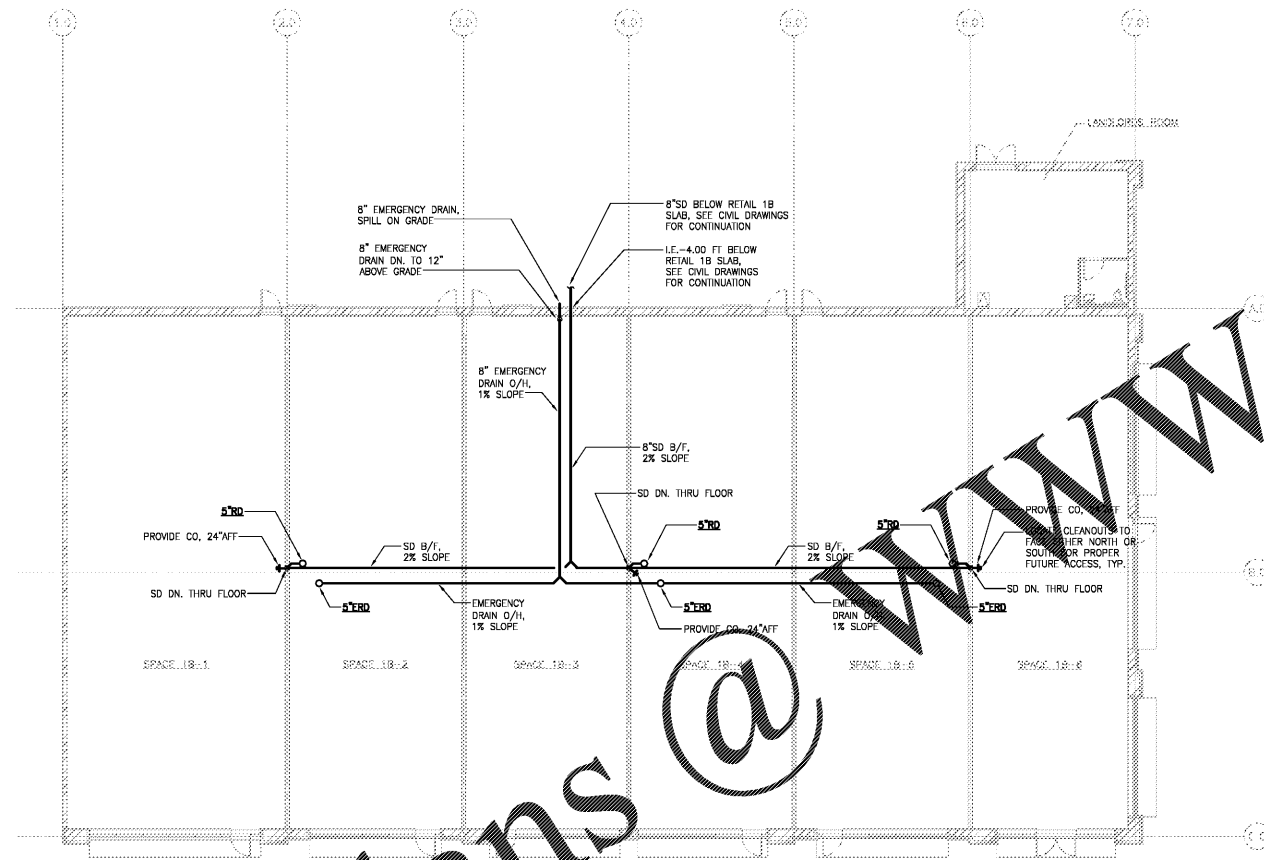

GENERAL NOTES:

- EMERGENCY DRAIN PIPING SHALL BE INSTALLED IN ROOF FRAMING SYSTEM

ROOF DRAINAGE PLAN - RETAIL 1B
SCALE: 3/32" = 1'-0"

Salem Gate Market

RETAIL 1B

CONYERS, GEORGIA

PLUMBING ROOF DRAINAGE PLAN

CRAY Ray Group Consulting Engineers, Inc.
1877 Powers Ferry Road
Building 80, Suite 100
Atlanta, Georgia 30339
Tel. (770) 953-1448
Fax. (770) 953-4023

Date:	10/16/20	Drawn by:	MA	Sheet No.:	P3.1
Project No.:	20.062	Checked by:	KSM		(1)