


Architect:
archSTUDIO7, PLLC
301 N. MAIN STREET, SUITE 1201
Winston-Salem, NC 27101
Tel. 336.793.9900
www.archstudio7.com
Copyright Reserved

The Contractor shall verify and be responsible for all dimensions. DO NOT scale the drawing - any errors or omissions shall be reported to archSTUDIO7, PLLC without delay. The Copyright to all designs and drawings are the property of archSTUDIO7, PLLC. Reproduction or use for any purpose other than that authorized by archSTUDIO7, PLLC is forbidden.

Consultants:

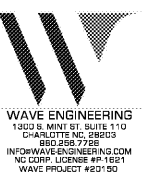

WAVE ENGINEERING
1300 S. MAIN ST., SUITE 110
CHARLOTTE, NC 28203
INFO@WAVEENGINEERING.COM
NC CORP. LICENSE #P-1821
WAVE PROJECT #201-20

Permit - Seal:

PRELIMINARY
NOT FOR CONSTRUCTION
OR PRICING

10/20/2020

NOT FOR
CONSTRUCTION

Issued / Revisions: Appd. Date

Client:




Project:
Storage Facility
Country Club Rd.
Winston-Salem, NC

Title:

**PLUMBING
FIRST FLOOR
PLAN**

Date:
Project No.: Drawn by:
Sheet:

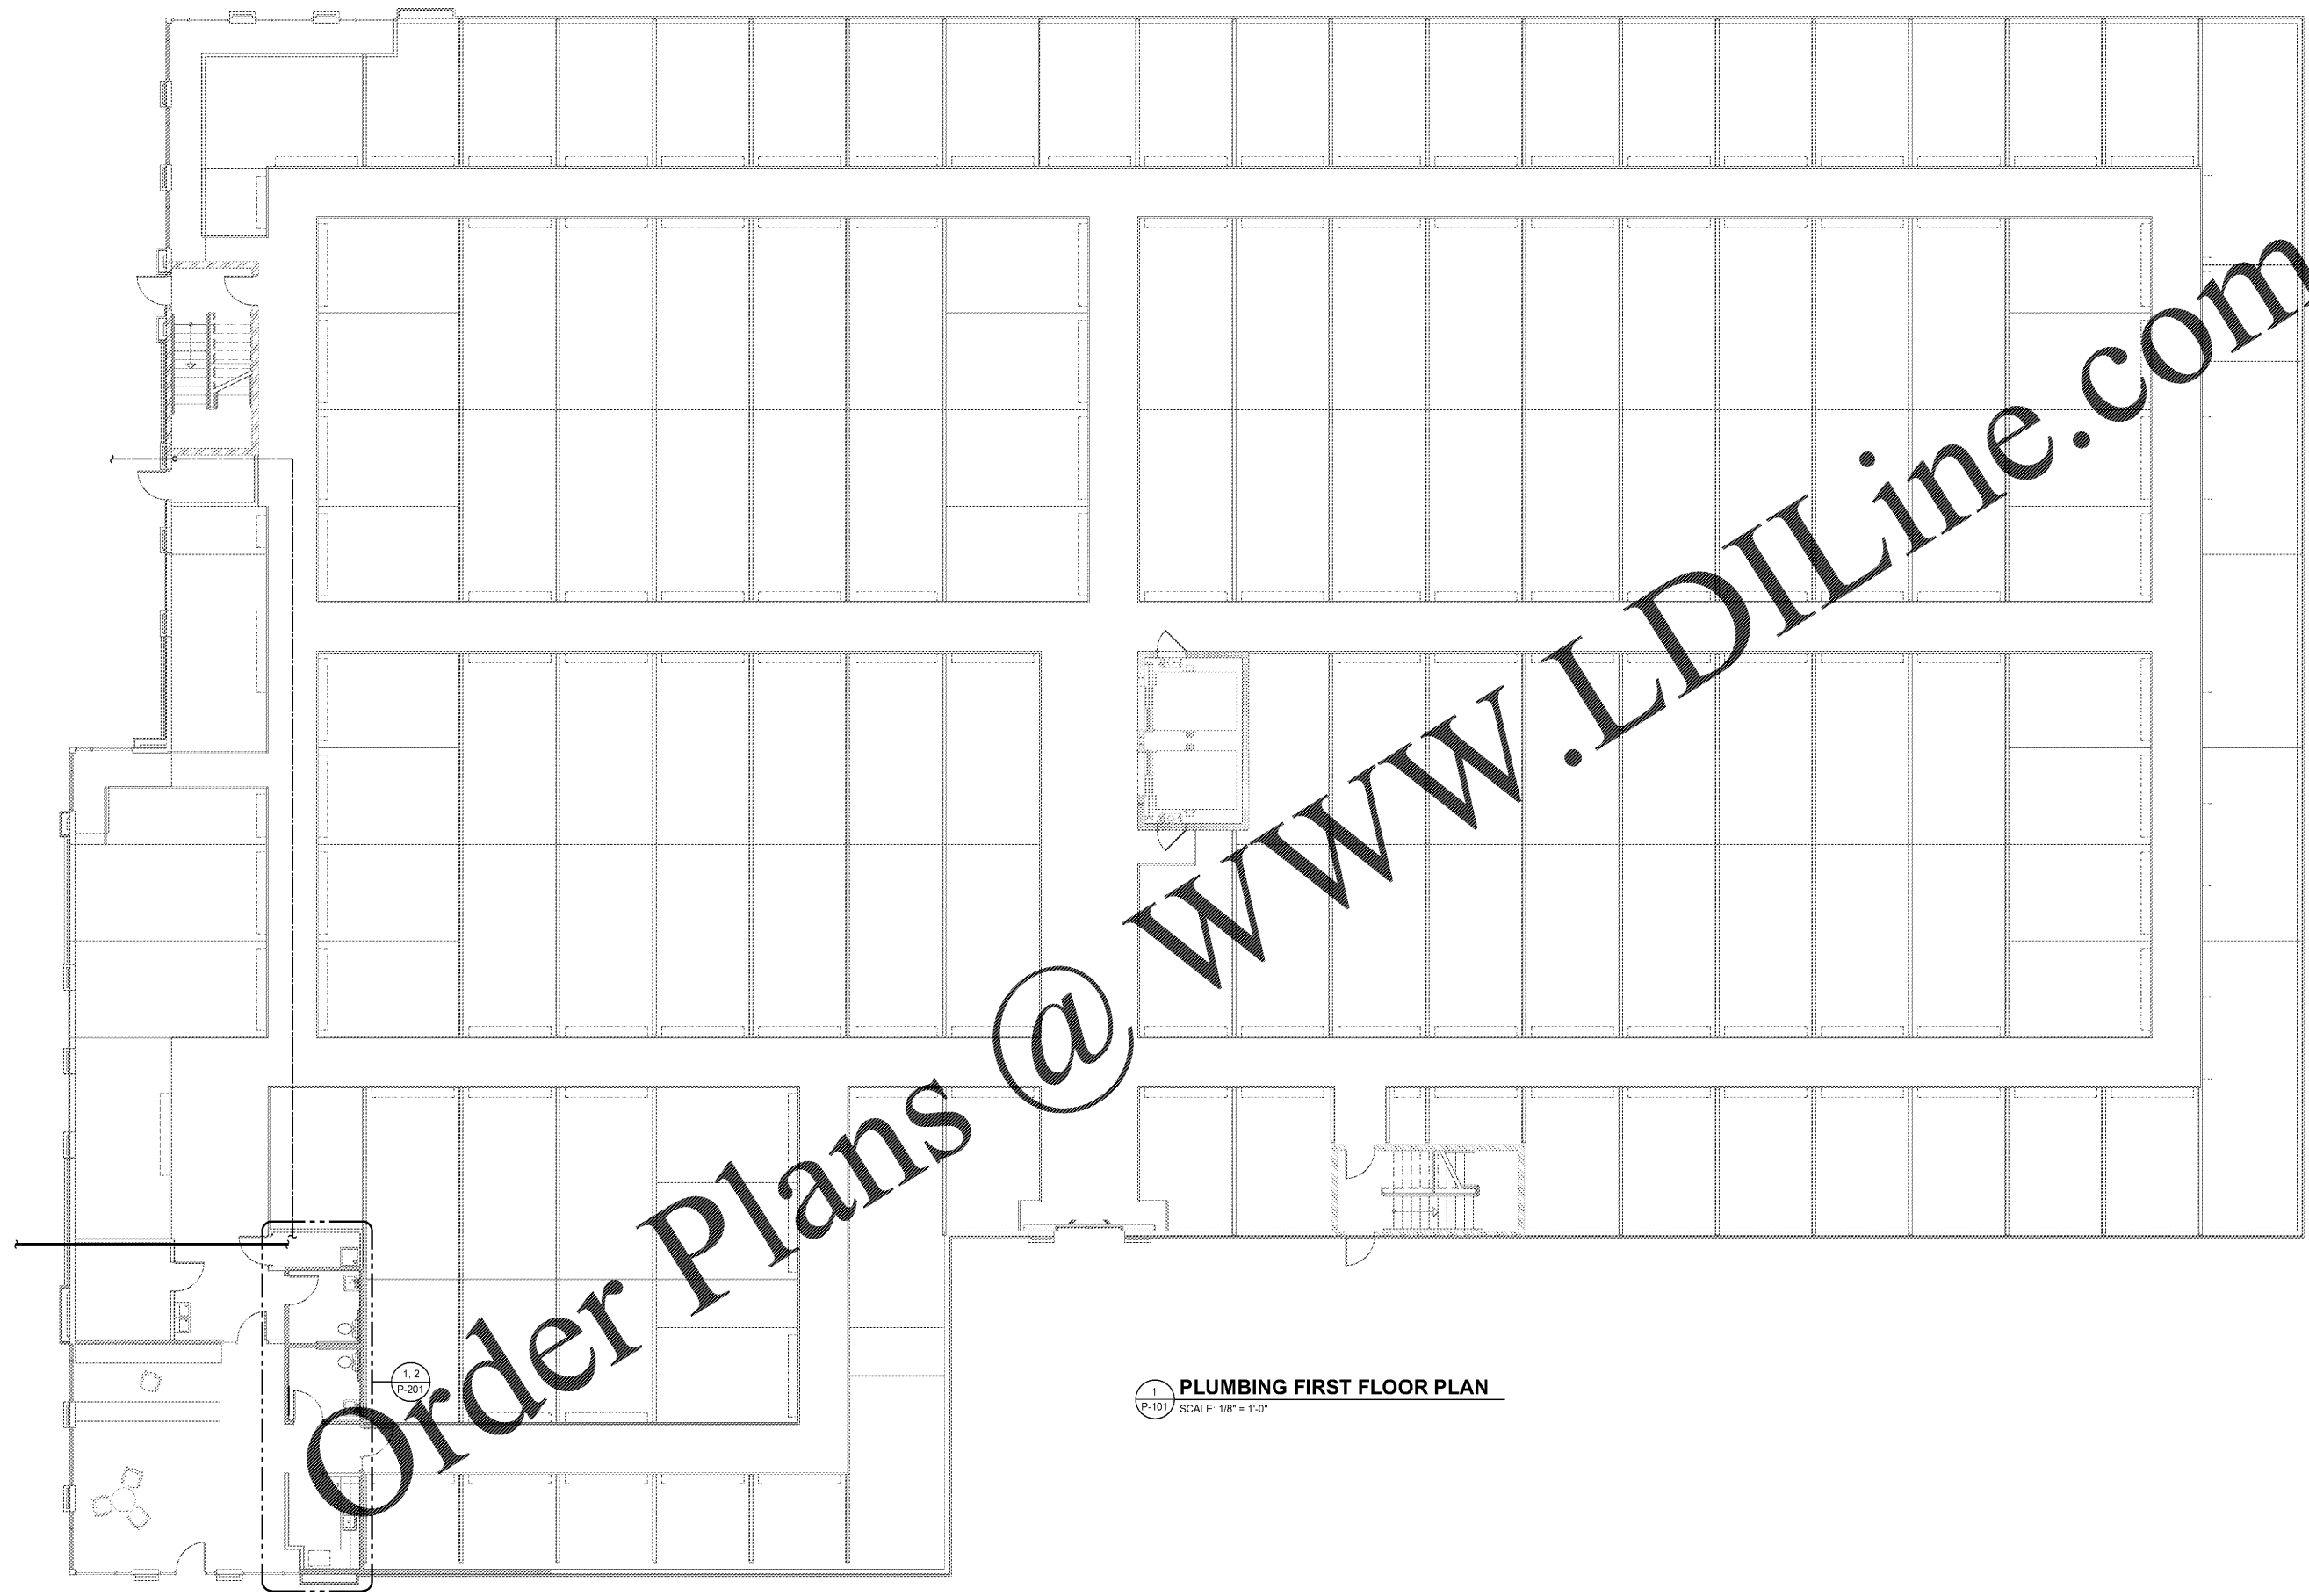

1 PLUMBING FIRST FLOOR PLAN
P-101 SCALE: 1/8" = 1'-0"