



HEALTH HUB/Rx CONSULTATION
STORE NUMBER: 4176

11 RIVER RIDGE DRIVE, OAKLEY PLAZA
ASHEVILLE, NC 28803
CAP CODE: 90

CS PROJECT NUMBER: 146740

ARCHITECT OF RECORD:



This drawing and the design shown are the property of Little Architectural Consulting. The reproduction, copying or other use of this drawing without their written consent is prohibited and any infringement will be subject to legal action.



DEVELOPER:



SEAL:




REVISIONS:

DRAWING BY: ZM
CVS PROJECT MANAGER: RJ
DATE: 11-02-2020
JOB NUMBER: 121-14217-08
TITLE: MECHANICAL DETAILS



SHEET NUMBER:

M-4


COMMENTS:

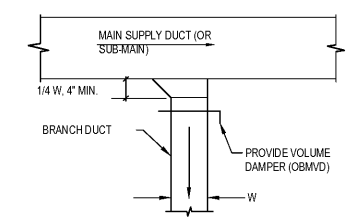



SUPPLY AIR DUCT

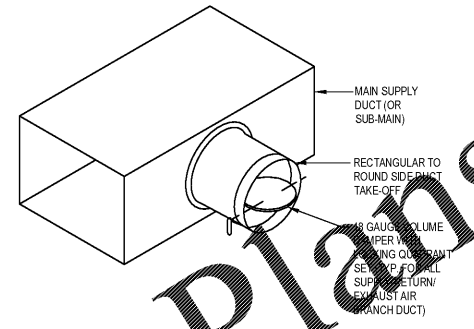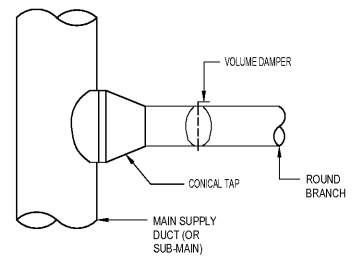

1 BRANCH TAKE-OFF DETAIL
M-4 SCALE: 1"=0"

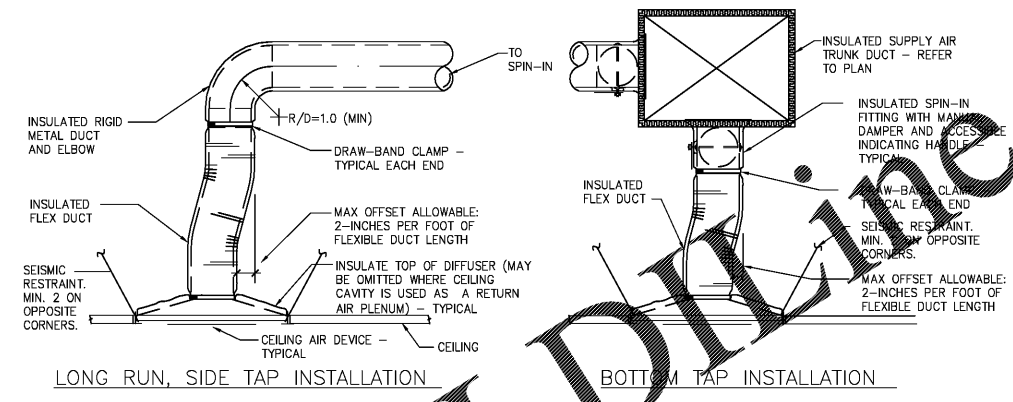

2 CEILING DIFFUSER/RETURN GRILLE CONNECTION DETAIL
M-4 SCALE: NTS

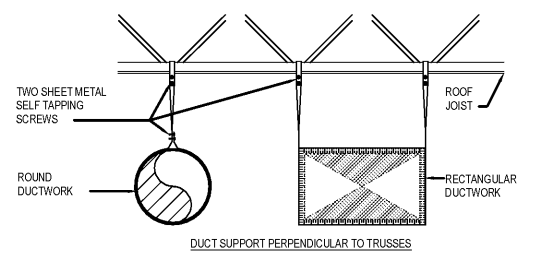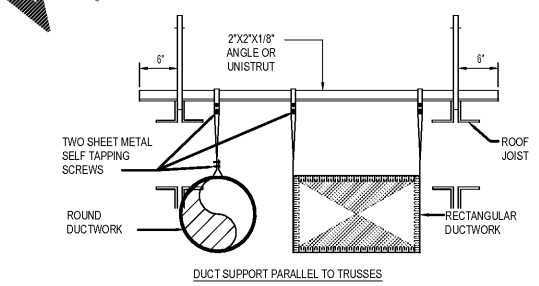

3 DUCT HANGER DETAILS
M-4 SCALE: NTS

Order Plans @ WWW.DIAGRAMS.COM