



Order Plans @ WWW.LDILine.com

NOTES BY SYMBOL (○) (EXISTING BUILDING)

- EXISTING PLUMBING FIXTURES TO REMAIN. NO WORK.
- REMOVE PHOTO LAB SINK AND ASSOCIATED INSTANTANEOUS WATER HEATER COMPLETELY. REMOVE EXISTING WASTE AND WATER LINES BACK TO EACH RESPECTIVE MAIN AND CAP PER CODE.

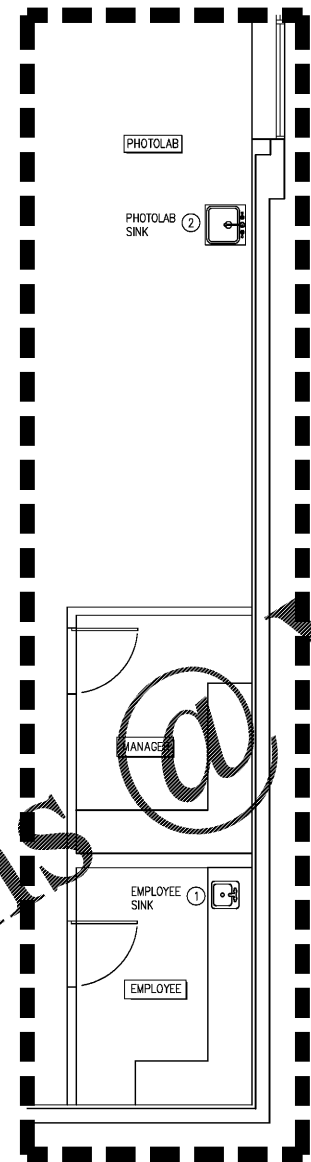

2 PLUMBING DEMOLITION PLAN
P-2 SCALE: 1/4"=1'-0"

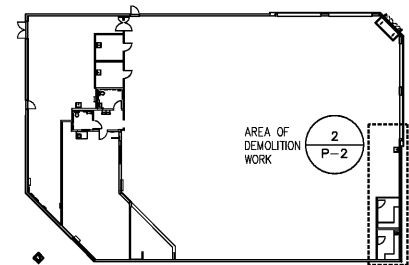

1 PLUMBING DEMOLITION KEY PLAN
P-2 SCALE: NTS



HEALTH HUB/Rx CONSULTATION
STORE NUMBER: 4176
11 RIVER RIDGE DRIVE, OAKLEY PLAZA
ASHEVILLE, NC 28803
CAP CODE: 90
CS PROJECT NUMBER: 146740

ARCHITECT OF RECORD:



815 S. College St. Ste 100 Charlotte, NC 28217
T: 704.525.6350 F: 704.561.8700
www.littleonline.com

This drawing and the design herein are the property of Little Diversified Architectural Consulting. The reproduction, copying or other use of this drawing without their written consent is prohibited and any infringement will be subject to legal action.



213 N. McDowell St., Suite 204
Charlotte, NC 28204
(P) 704.334.7363 | (F) 704.347.0093
www.shultzeng.com | 555 - 70 376
NC FIRM LICENSE NUMBER: C-0098
M:ZM E:W.C P:ZM

DEVELOPER:



SEAL:



REVISIONS:

DRAWING BY: ZM

CVS PROJECT MANAGER: R.J

DATE: 11-02-2020

JOB NUMBER: 121-14217-08

TITLE: PLUMBING DEMOLITION PLANS AND NOTES

SHEET NUMBER: P-2

COMMENTS: