


① 08 - Reflected Ceiling Plan - Main Floor  
1/4" = 1'-0"

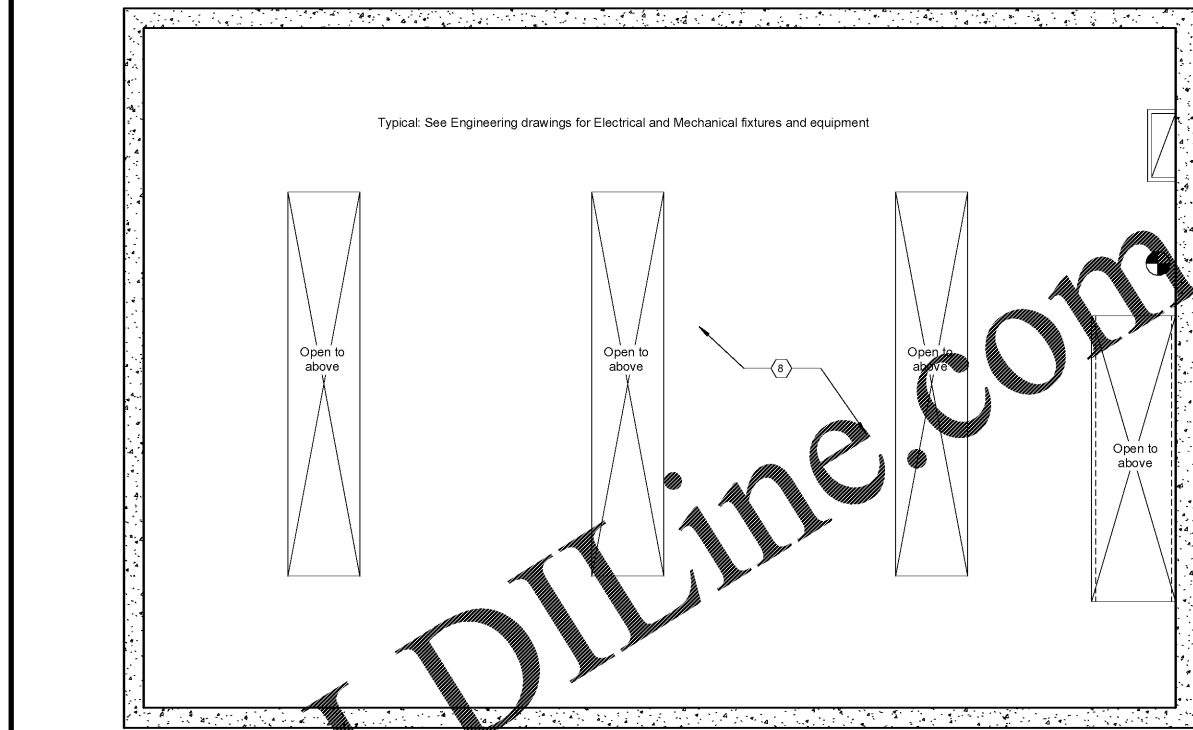

② 09 - Reflected Ceiling Plan - 1st Level  
1/4" = 1'-0"



Express Oil Change & Tire Engineers  
Right Hand Oil Change Building (Hurricane)  
2265 O'Neal Lane  
Baton Rouge, LA 70816

FINAL

No.	Description	Date

© 2020 Aho Architects, LLC. All Rights Reserved.

Reflected Ceiling Plans / Legend

Project number	20025
Date	08/27/2020
Drawn by	ARC
Checked by	TAA

OC-A104  
Scale 1/4" = 1'-0"