



Engineering & Design Consultants
 2111 Parkway Office Circle, Suite 125
 Birmingham, AL 35244
 (205) 733-6912 FAX: (205) 733-6913
 Job No. 20163




www.ahoarch.com



08/27/2020

Express Oil Change & Tire Engineers
 Right Hand Oil Change Building (Hurricane)
 2265 O'Neal Lane
 Baton Rouge, LA 70816

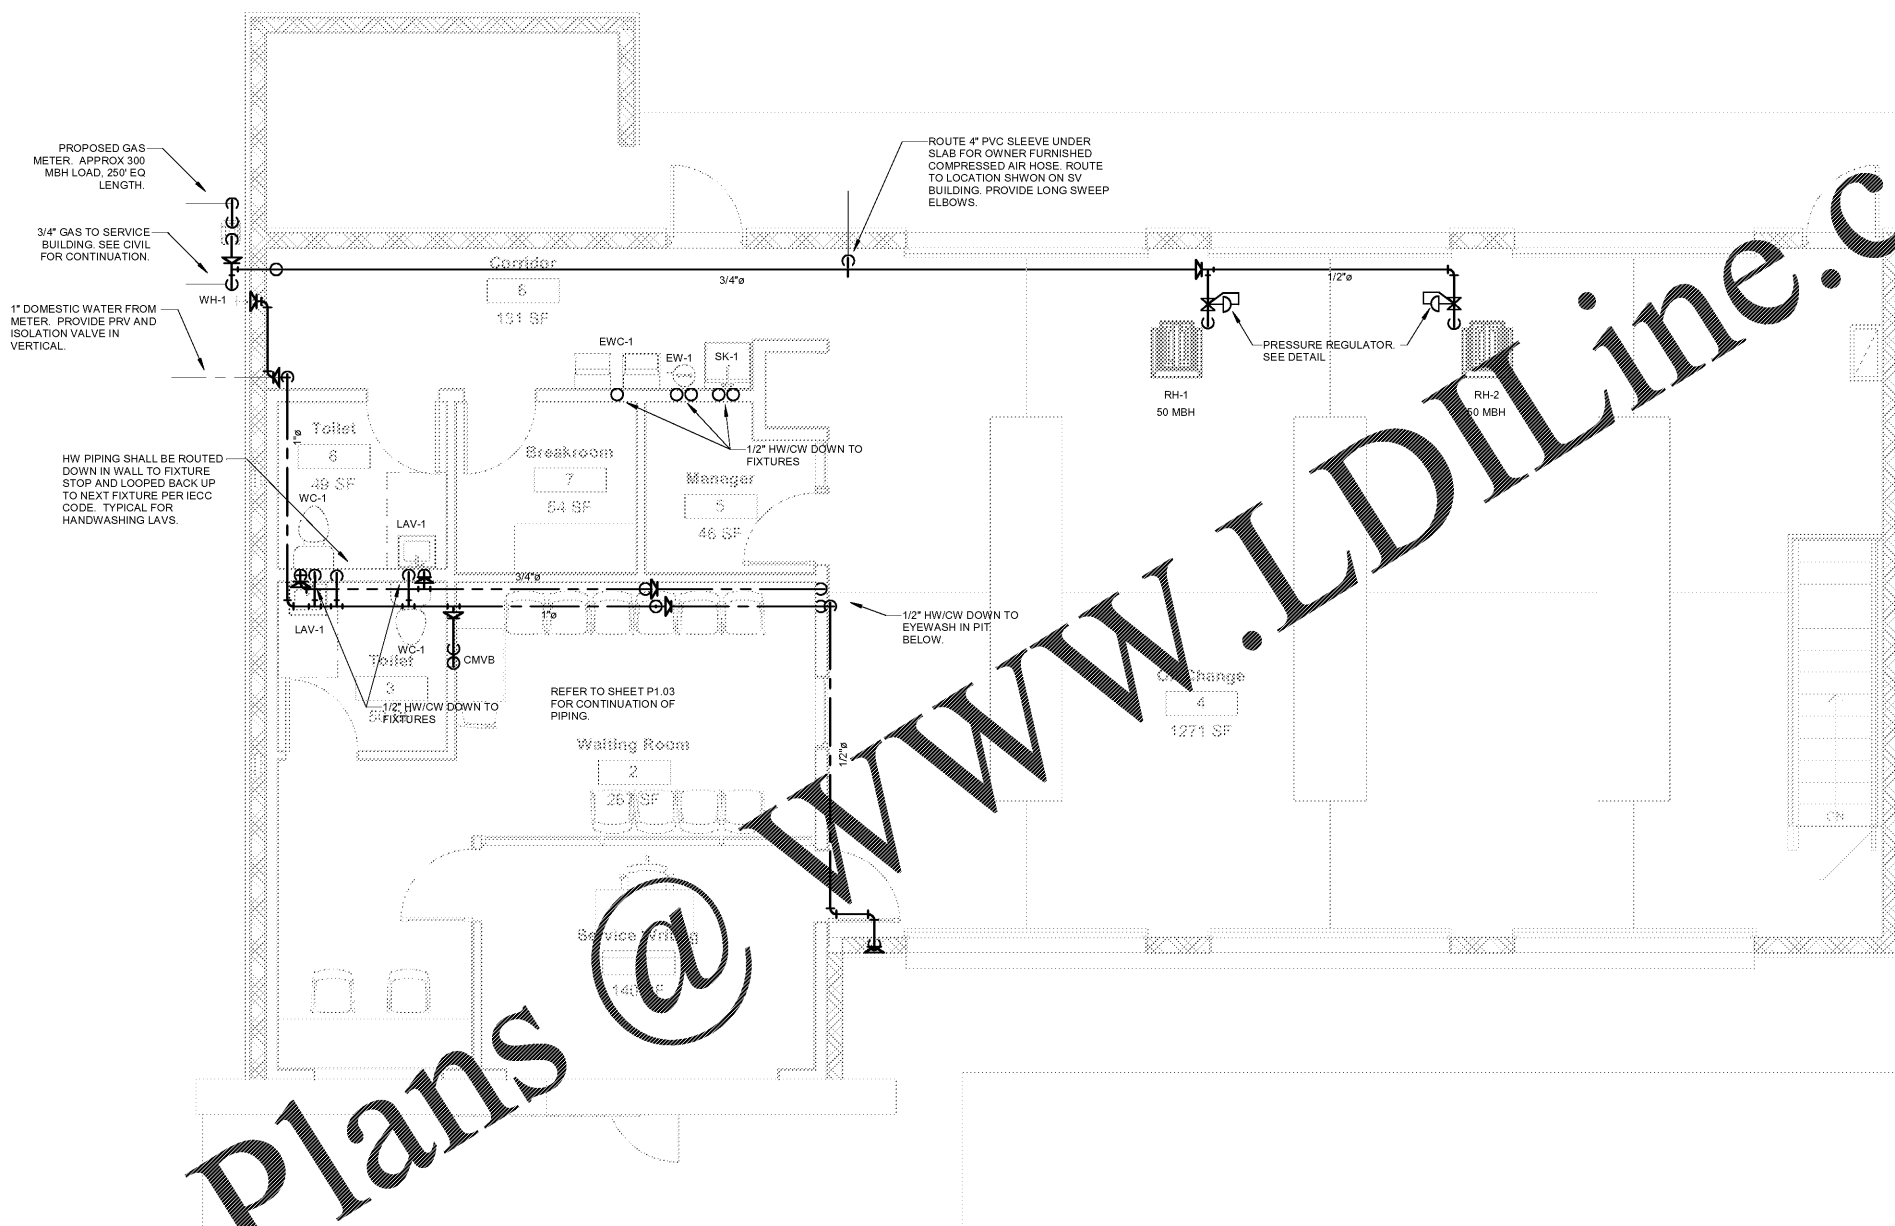

Order Plans @

MAIN FLOOR PLAN PLUMBING - PRESSURE
 NORTH
 0 1 2 3 4 8
 SCALE: 1/4" = 1'-0"

- GENERAL NOTES:**
- SPACE ABOVE CEILING IS LIMITED. CAREFUL COORDINATION WITH LIGHTING, ELECTRICAL, MECHANICAL, FIRE PROTECTION, STRUCTURAL AND ARCHITECTURAL WORK IS CRITICAL FOR COMPLETE PIPING INSTALLATION. CONTRACTOR SHALL PROVIDE NECESSARY OFFSETS IN NEW AND EXISTING PIPING AND ELECTRICAL CONDUIT AS REQUIRED TO ACCOMMODATE NEW WORK. CONTRACTOR SHALL ALLOW FOR ANY CONFLICTS ENCOUNTERED.
 - PIPING LAYOUTS ARE DIAGRAMMATIC AND DO NOT SHOW ALL ELEMENTS OF CONSTRUCTION. CONTRACTOR SHALL BE RESPONSIBLE FOR ALL CHANGES ON DIRECTION, ELEVATION AND MINOR OFFSETS NECESSARY FOR COMPLETE INSTALLATION OF ELEMENTS SHOWN.
 - ALL PRESSURE PIPING SHOWN IS ABOVE THE CEILING UNLESS OTHERWISE NOTED. ALL TRAP PRIMER LINES AND HOT WATER RETURN LINES SHALL BE 1/2" UNLESS OTHERWISE NOTED.
 - REFER TO ARCHITECTURAL REFLECTED CEILING PLANS FOR LOCATIONS OF ALL CEILING MOUNTED DEVICES. REFER TO ARCHITECTURAL FLOOR PLANS FOR ALL DIMENSIONS.
 - COORDINATE ACCESS DOOR LOCATIONS WITH GENERAL CONTRACTOR AND ARCHITECT.
 - UNDERGROUND COMPRESSED AIR PIPING SHALL BE EQUAL TO MAXLINE COMPRESSED AIR PIPING SYSTEM. PIPING SHALL BE COMPOSITE HDPE, ALUMINUM AND HDPE TUBING COMPATIBLE WITH DIRECT BURY APPLICATION.
 - ALL ABOVE GROUND COMPRESSED AIR PIPING SHALL BE BLACK STEEL.
 - PRESSURE REGULATORS FOR GAS PIPING SHALL BE EQUAL TO MAXITROL 325 SERIES.

FINAL

No.	Description	Date

© 2020 Aho Architects, LLC. All Rights Reserved.

Plumbing Floor Plan Pressure

Project number 20025
 Date 08/27/2020
 Drawn by CA
 Checked by JB

OC-P1.02
 Scale As indicated