




Express Oil Change & Tire Engineers
 Right Hand Oil Change Building (Hurricane)
 2265 O'Neal Lane
 Baton Rouge, LA 70816

GENERAL NOTES:


- OIL CHANGE BUILDING IS CLASSIFIED AS MINOR REPAIR GARAGE.

NOTES:

- 48"x48"x3/4" DATA/TELEPHONE BACKBOARD. PAINT WITH NON-CONDUCTIVE, FIRE RETARDANT PAINT. SEE AUXILIARY SINGLE LINE DIAGRAM ON SHEET E102 FOR MORE INFORMATION. COORDINATE EXACT LOCATION WITH DUCTWORK.

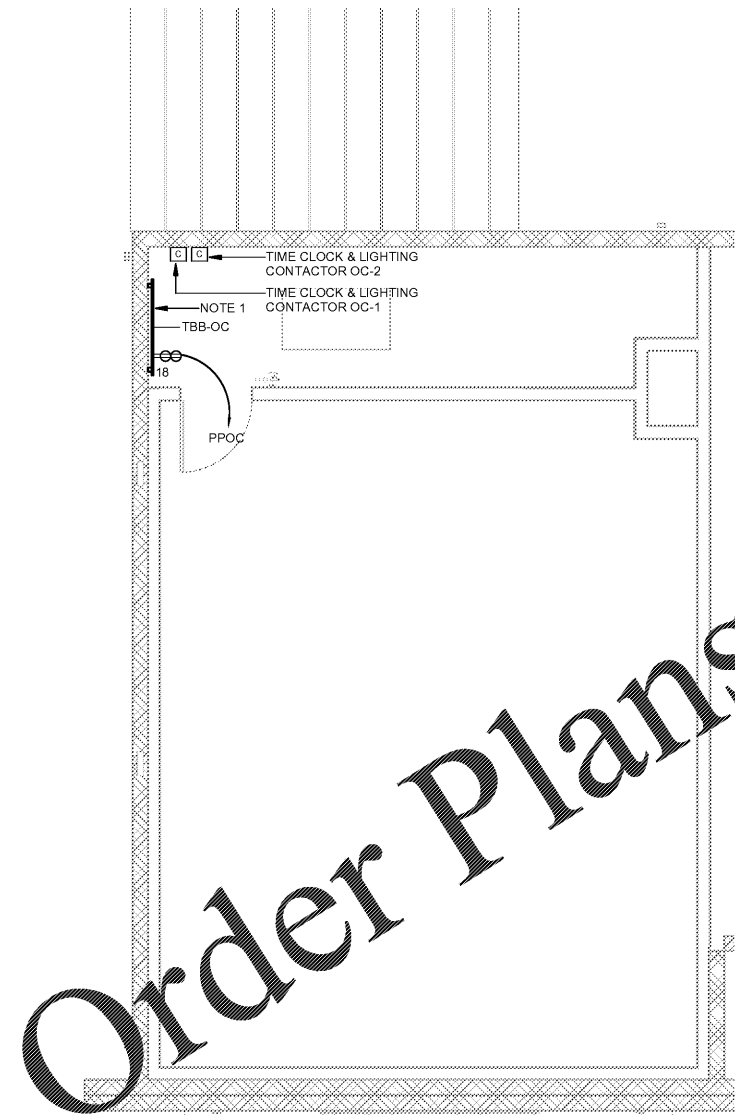

① Equipment Level - Power & Voice/Data
 1/4" = 1'-0"

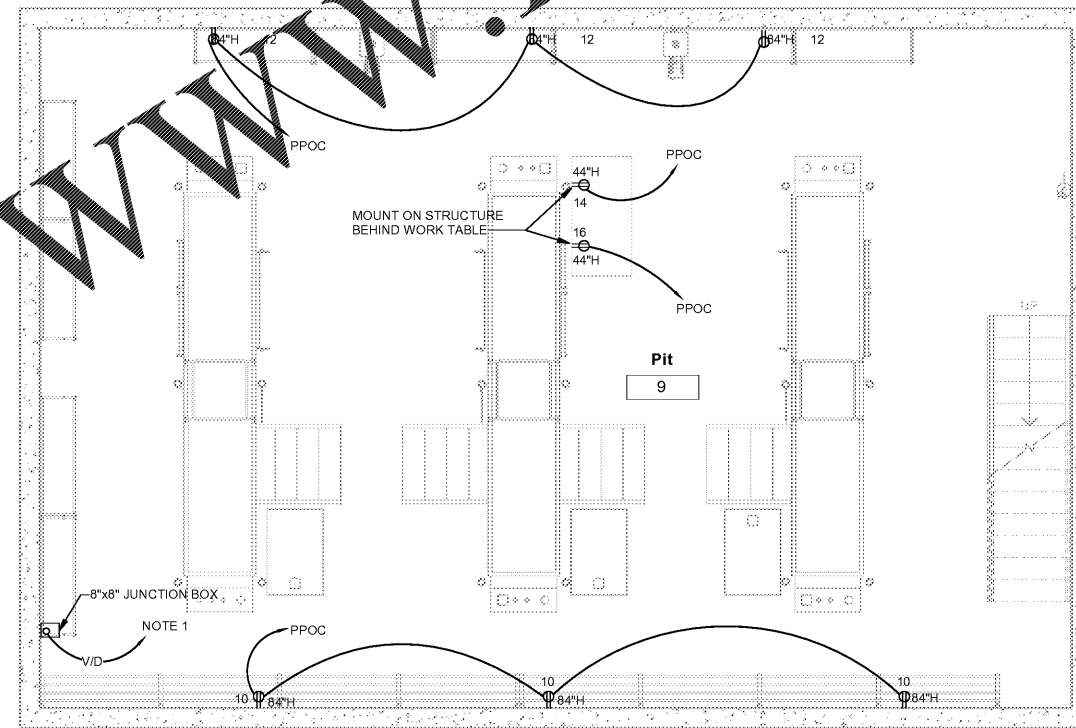

② Pit Level - Power & Voice/Data
 1/4" = 1'-0"



FINAL

No.	Description	Date

© 2020 Aho Architects, LLC. All Rights Reserved.

Pit Level & Equip. Platform Plans - Power & Voice/Data

Project number 20025
 Date 08/27/2020

Drawn by TH
 Checked by NB

OC-E301

Scale 1/4" = 1'-0"



PROJECT:

8/27/2020 2:01:13 PM