




GENERAL NOTES:

- OIL CHANGE BUILDING IS CLASSIFIED AS MINOR REPAIR GARAGE.

NOTES:

- HOMERUN TO 20A, POLE CIRCUIT BREAKER IN PANELBOARD PPOC THROUGH LIGHTING CONTACTOR OC-1

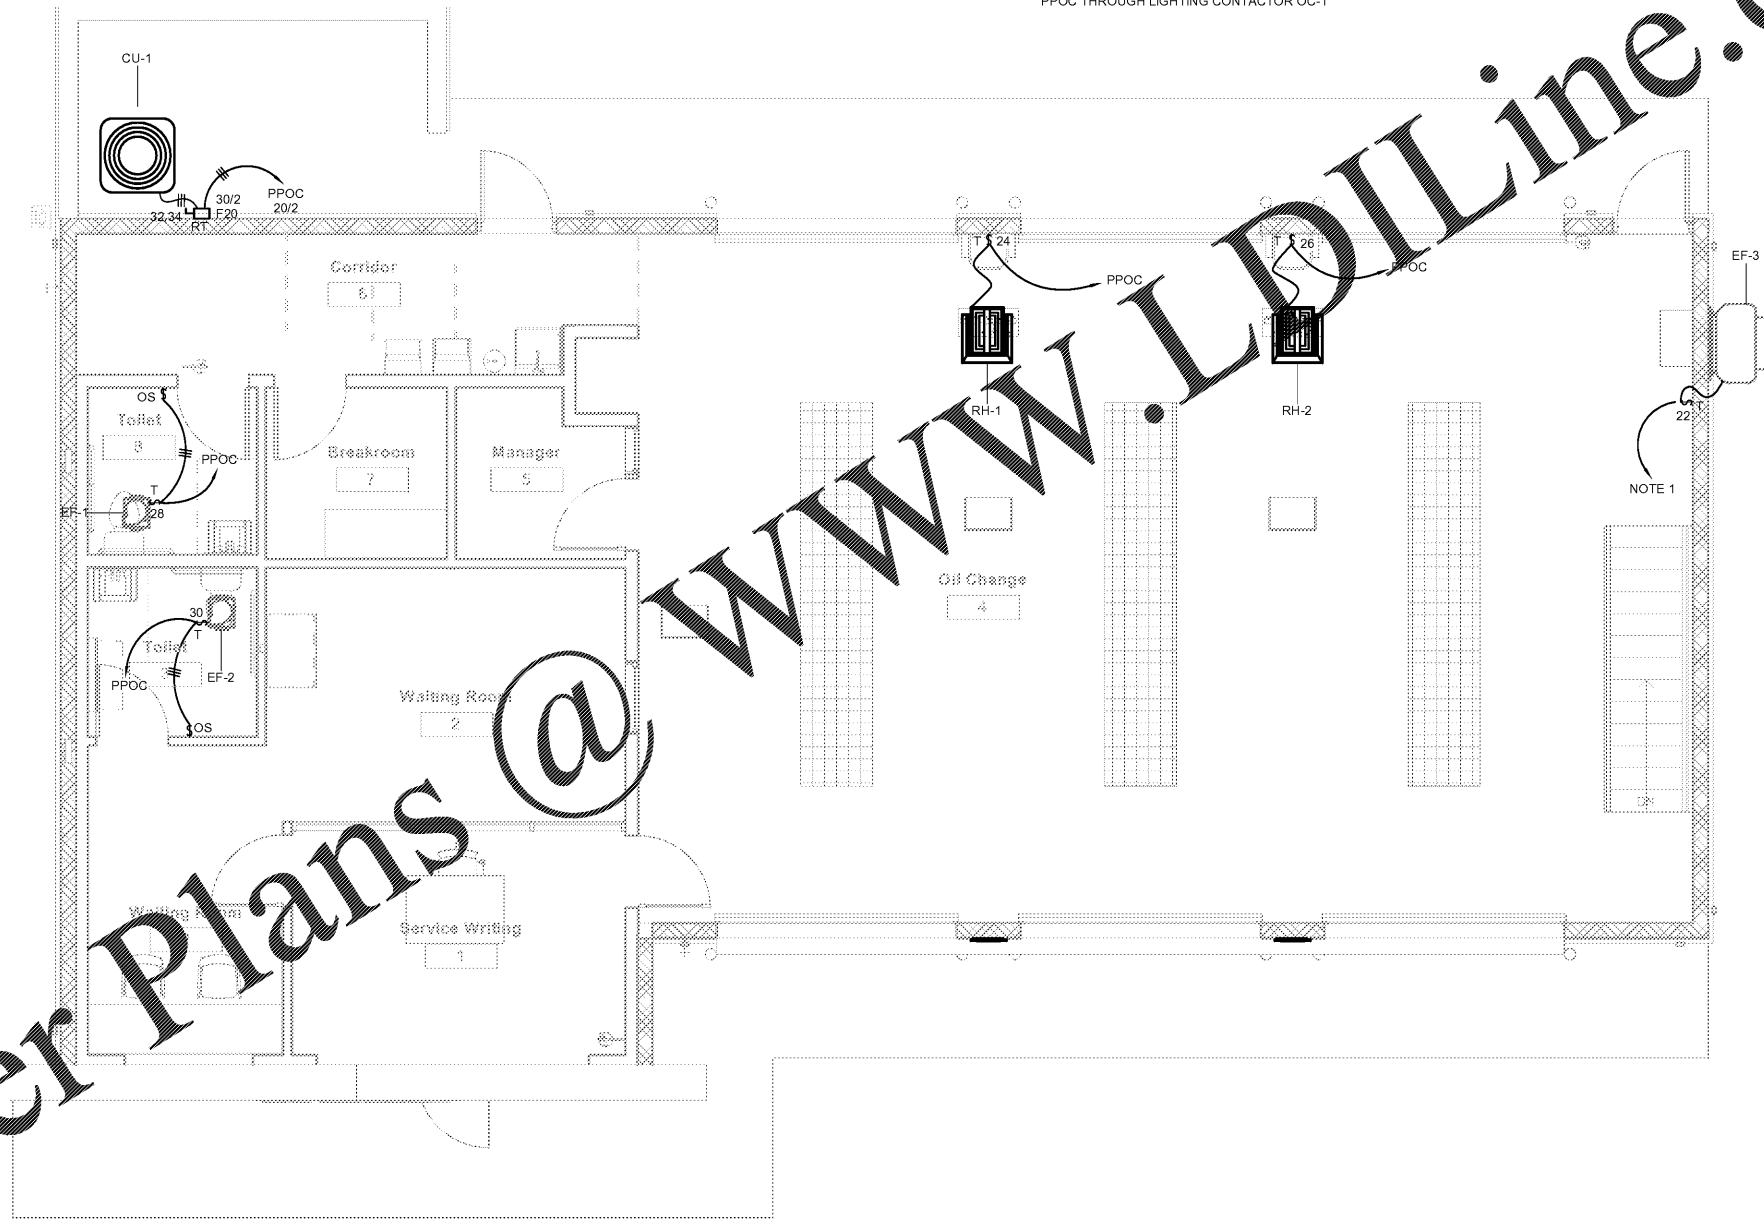

Order Plans @

1-Ground Level - Electrical Connection to Mechanical
 1/4" = 1'-0"



Express Oil Change & Tire Engineers
 Right Hand Oil Change Building (Hurricane)
 2265 O'Neal Lane
 Baton Rouge, LA 70816

FINAL

| No. | Description | Date |
|-----|-------------|------|
| | | |
| | | |
© 2020 Aho Architects, LLC. All Rights Reserved.

Ground Floor Plan - Electrical Connection to Mechanical

| | |
|----------------|--------------|
| Project number | 20025 |
| Date | 08/27/2020 |
| Drawn by | TH |
| Checked by | NB |
| OC-E400 | |
| Scale | 1/4" = 1'-0" |

