


3/4" GAS FROM OC BUILDING. SEE CIVIL FOR CONTINUATION.

EW-1 SHALL BE INSTALLED ABOVE CEILING OF RESTROOM. SEE DETAIL. ROUTE T&P TO GRADE.

1" DOMESTIC WATER FROM METER. PROVIDE PRV AND ISOLATION VALVE IN VERTICAL.

ROUTED 1" PVC SLEEVE UNDER SLAB. OWNER FURNISHED UNDESS AIR HOSE. ROUTE LOCATION SHOWN ON OC BUILDING. PROVIDE LONG SWEEP ELBOWS.

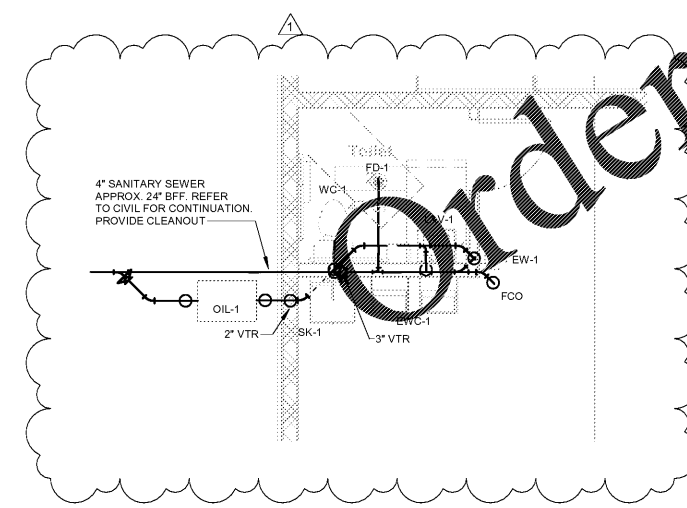

Plumbing Floor Plan - Gravity
SCALE: 1/4" = 1'-0"

Plumbing Floor Plan - Pressure
SCALE: 1/4" = 1'-0"

- GENERAL NOTES:**
- CONTRACTOR SHALL VERIFY EXISTING CONDITIONS IN FIELD PRIOR TO BEGINNING WORK.
 - PIPING LAYOUTS ARE DIAGRAMMATIC AND DO NOT SHOW ALL ELEMENTS OF CONSTRUCTION. CONTRACTOR SHALL BE RESPONSIBLE FOR ALL CHANGES ON DIRECTION, ELEVATION AND MINOR OFFSETS NECESSARY FOR COMPLETE INSTALLATION OF ELEMENTS SHOWN.
 - ALL WASTE PIPING SHOWN IS BELOW FINISHED FLOOR UNLESS OTHERWISE NOTED. ALL VENT PIPING SHOWN IS ABOVE CEILING UNLESS OTHERWISE NOTED.
 - REFER TO ARCHITECTURAL REFLECTED CEILING PLANS FOR LOCATIONS OF ALL CEILING MOUNTED DEVICES. REFER TO ARCHITECTURAL FLOOR PLANS FOR ALL DIMENSIONS.
 - COORDINATE ACCESS DOOR LOCATIONS WITH GENERAL CONTRACTOR AND ARCHITECT.

- GENERAL NOTES:**
- CONTRACTOR SHALL VERIFY EXISTING CONDITIONS IN FIELD PRIOR TO BEGINNING WORK.
 - SPACE ABOVE CEILING IS LIMITED. CAREFUL COORDINATION WITH LIGHTING, ELECTRICAL, MECHANICAL, FIRE PROTECTION, STRUCTURAL AND ARCHITECTURAL WORK IS CRITICAL FOR COMPLETE PIPING INSTALLATION. CONTRACTOR SHALL PROVIDE NECESSARY OFFSETS IN NEW AND EXISTING PIPING AND ELECTRICAL CONDUIT AS REQUIRED TO ACCOMMODATE NEW WORK. CONTRACTOR SHALL ALLOW FOR ANY CONFLICTS ENCOUNTERED.
 - PIPING LAYOUTS ARE DIAGRAMMATIC AND DO NOT SHOW ALL ELEMENTS OF CONSTRUCTION. CONTRACTOR SHALL BE RESPONSIBLE FOR ALL CHANGES ON DIRECTION, ELEVATION AND MINOR OFFSETS NECESSARY FOR COMPLETE INSTALLATION OF ELEMENTS SHOWN.
 - ALL PRESSURE PIPING SHOWN IS ABOVE THE CEILING UNLESS OTHERWISE NOTED. ALL TRAP PRIMER LINES AND HOT WATER RETURN LINES SHALL BE 1/2" UNLESS OTHERWISE NOTED.
 - PRESSURE REGULATORS FOR GAS PIPING SHALL BE EQUAL TO MAXITROL 325 SERIES.
 - EXPOSED DOMESTIC WATER PIPING SHALL BE TYPE K COPPER. PIPING WITHIN WALLS AND CEILINGS SHALL BE PERMITTED TO BE PEX.

FINAL

No.	Description	Date
1	Revision #1	9/15/20

© 2020 Aho Architects, LLC. All Rights Reserved.

Plumbing Floorplans

Project number 20025
Date 08/27/2020
Drawn by CRA
Checked by JAB

SV-P1.01
Scale As indicated

Express Oil Change & Tire Engineers
Service Building (Hurricane)
2265 O'Neal Lane
Baton Rouge, LA 70816