





Engineering & Design Consultants
 2111 Parkway Office Circle, Suite 125
 Birmingham, AL 35244
 (205) 733-6912 FAX: (205) 733-6913
 Job No. 20163




08/27/2020

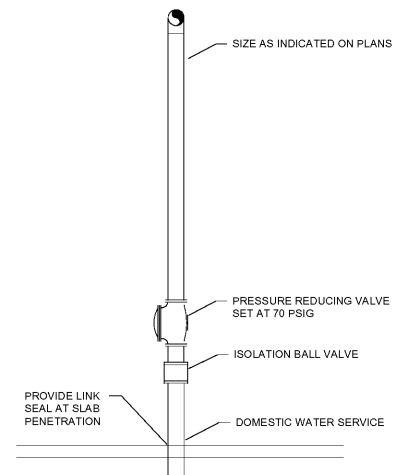


5 DOMESTIC WATER ENTRANCE DETAIL
 P3.01 NO SCALE

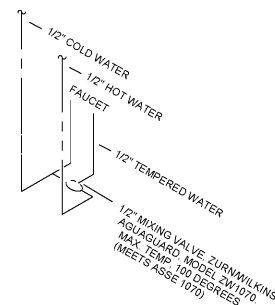


3 TYPICAL LAVATORY MIXING VALVE
 P3.01 SCALE: NONE

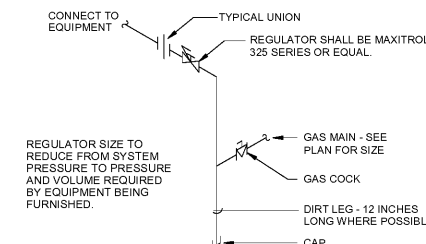


1 TYPICAL GAS CONNECTION
 P3.01 NO SCALE

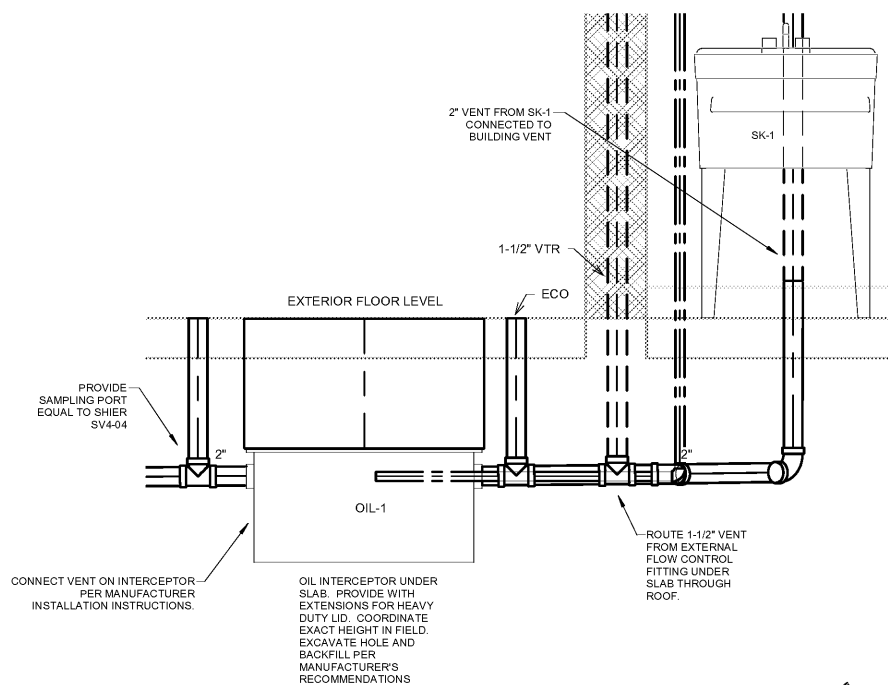

6 OIL INTERCEPTOR DETAIL
 SV-P3.01 1" = 1'-0"

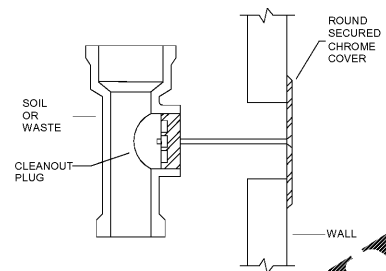

4 WALL CLEANOUT
 P3.01 NO SCALE

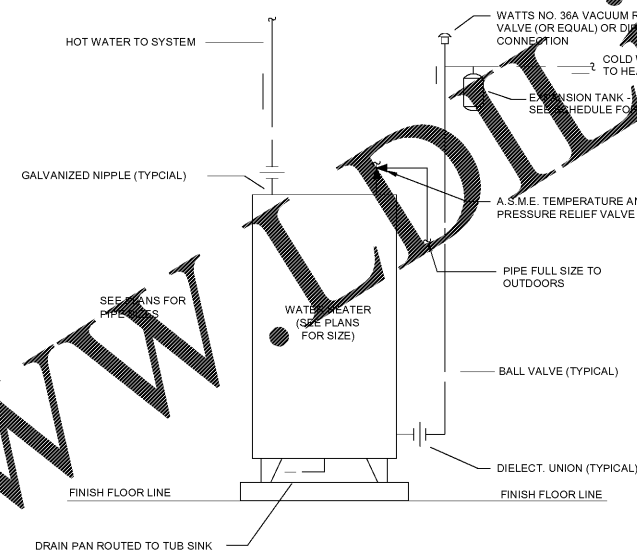

2 WATER HEATER MOUNTING DETAIL
 P3.01 NO SCALE

Order Plans @ WWW.LDOnline.com

Express Oil Change & Tire Engineers
 Service Building (Hurricane)
 2265 O'Neal Lane
 Baton Rouge, LA 70816

FINAL

No.	Description	Date

© 2020 Aho Architects, LLC. All Rights Reserved.

Plumbing Details

Project number	20025
Date	08/27/2020
Drawn by	CRA
Checked by	JAB
SV-P3.01	
Scale	As indicated