


Order Plans @ www.LDOnline.com

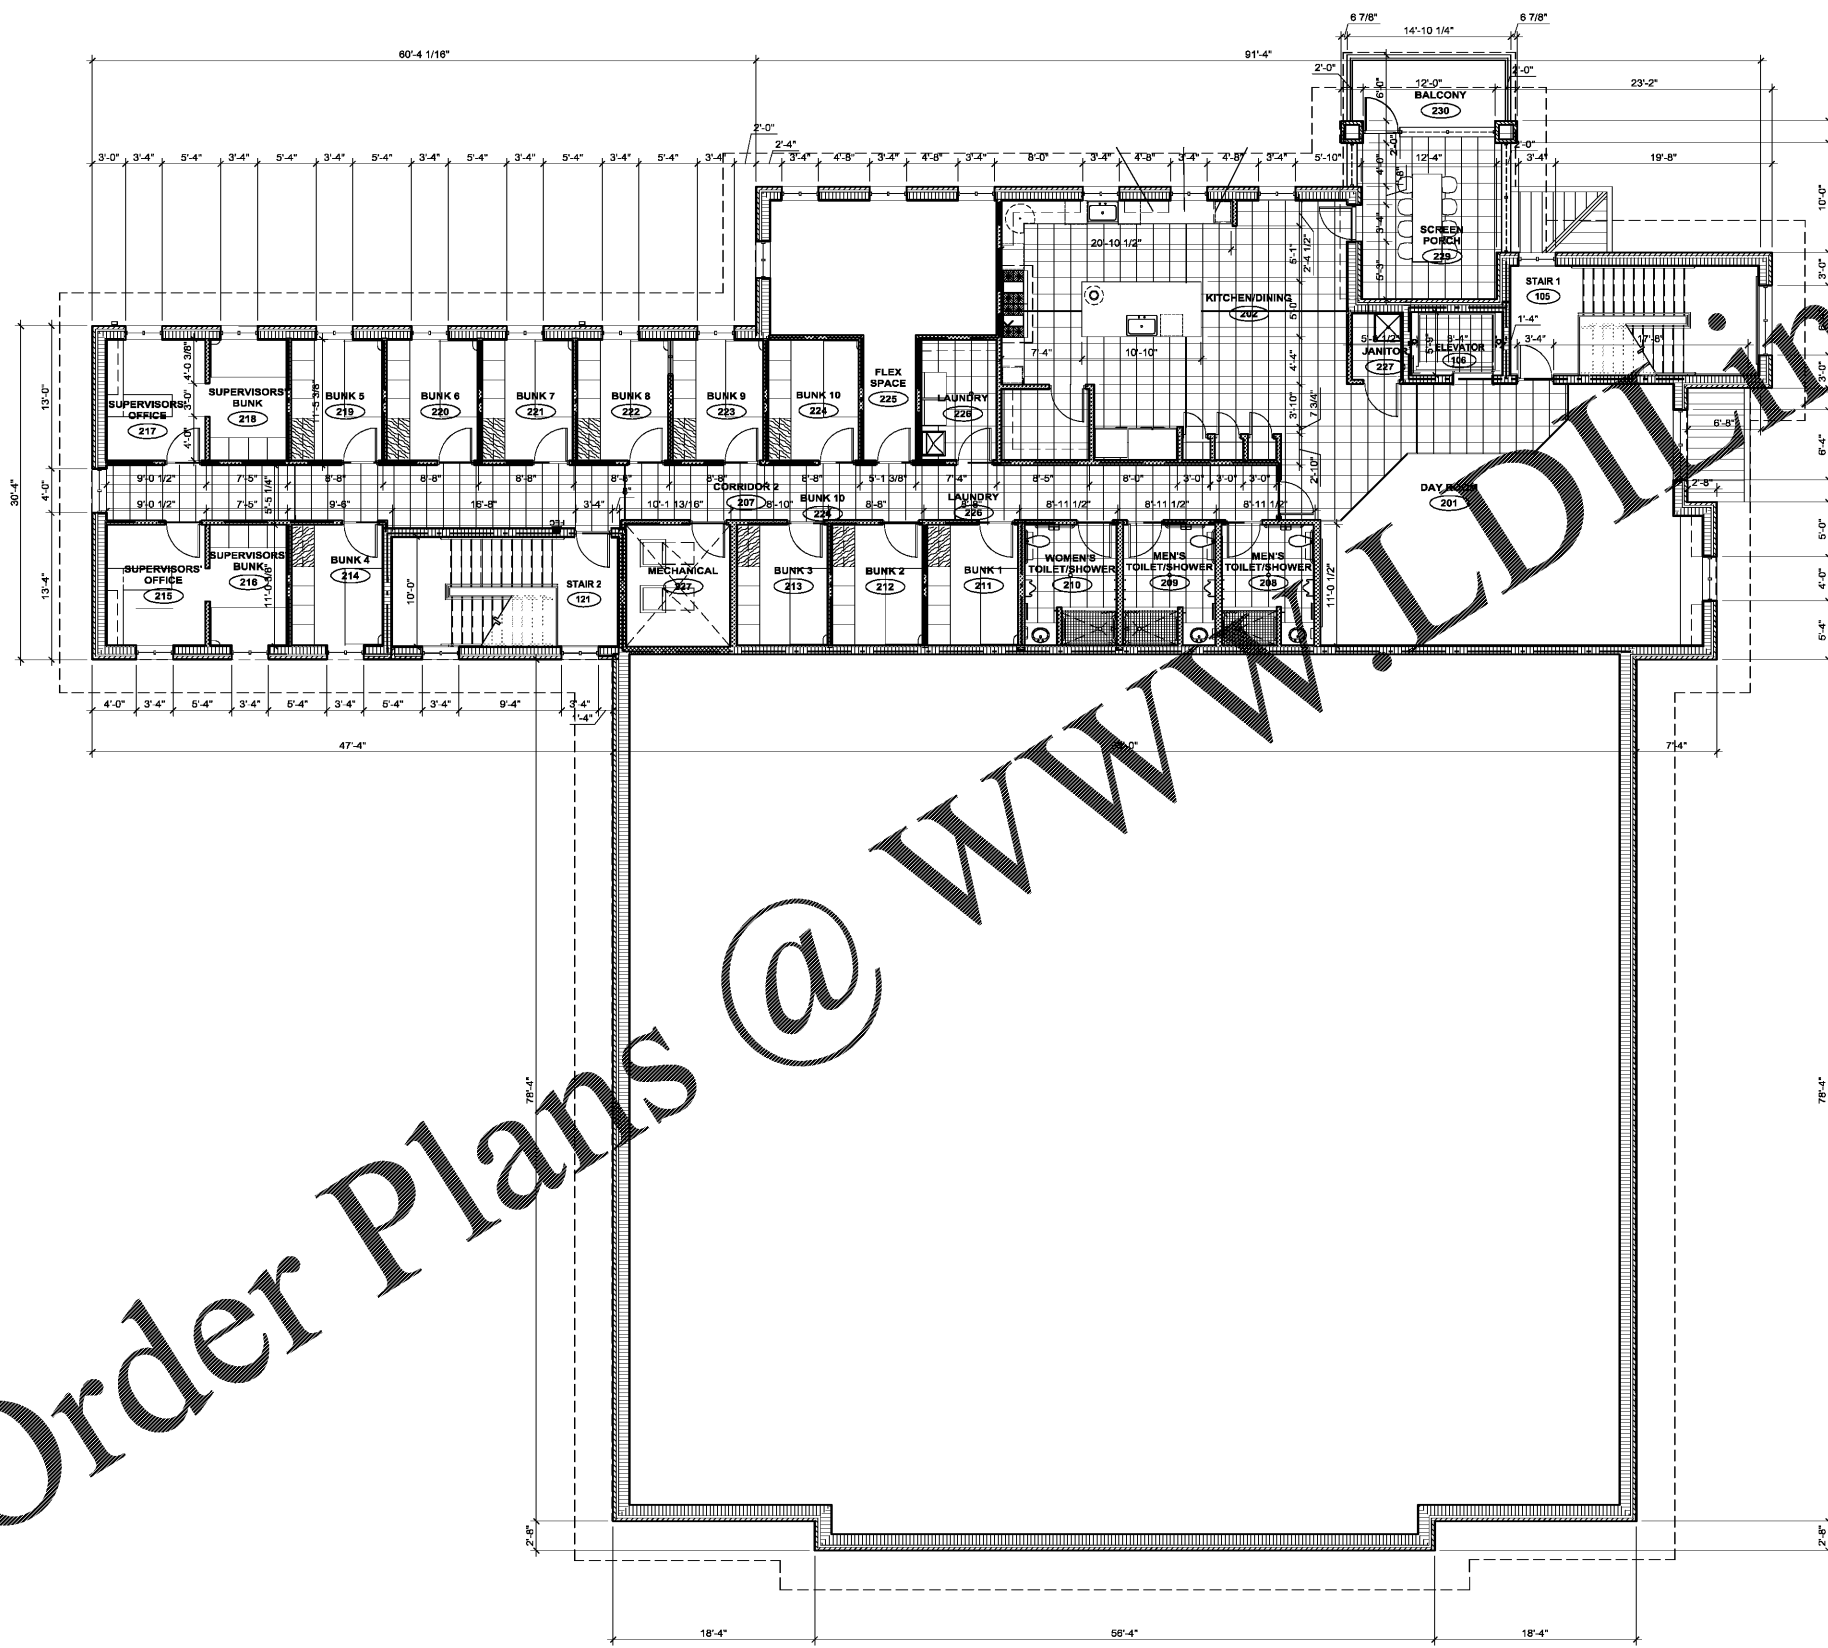

SECOND FLOOR DIMENSION FLOOR PLAN



FleischmanGarcia
 ARCHITECTURE • ENGINEERING
 2410 W. PARK AVENUE, SUITE 300
 TAMPA, FLORIDA 33606
 PHONE (813) 776-8888
 FAX (813) 775-2888
 REGISTRATION NUMBER: AA 0000121

**Pasco County
 Fire & Rescue Station
 No. 17
 New Port Richey, Florida**

THIS PERSON AND DRAWING IS THE SOLE PROPERTY OF FLEISCHMAN-GARCIA ARCHITECTURE, ENGINEERING AND DESIGN. NO PART OF THIS WORK MAY BE REPRODUCED WITHOUT THE WRITTEN PERMISSION OF FLEISCHMAN-GARCIA ARCHITECTURE, ENGINEERING AND DESIGN. ANY REUSE OF THIS WORK WITHOUT THE WRITTEN PERMISSION OF FLEISCHMAN-GARCIA ARCHITECTURE, ENGINEERING AND DESIGN IS PROHIBITED.

FGA PROJECT NUMBER
19039

ISSUE DATE
05-25-20

REVISIONS	
△	DATE: 10-02-19
△	DATE: -
△	DATE: -

SHEET NUMBER
A2.2

05-25-20 Jeff Rauscher\19039\19039_Station 17\FGA\2019\19039_Station 17_A2.dwg