


**WALL SECTION 2**

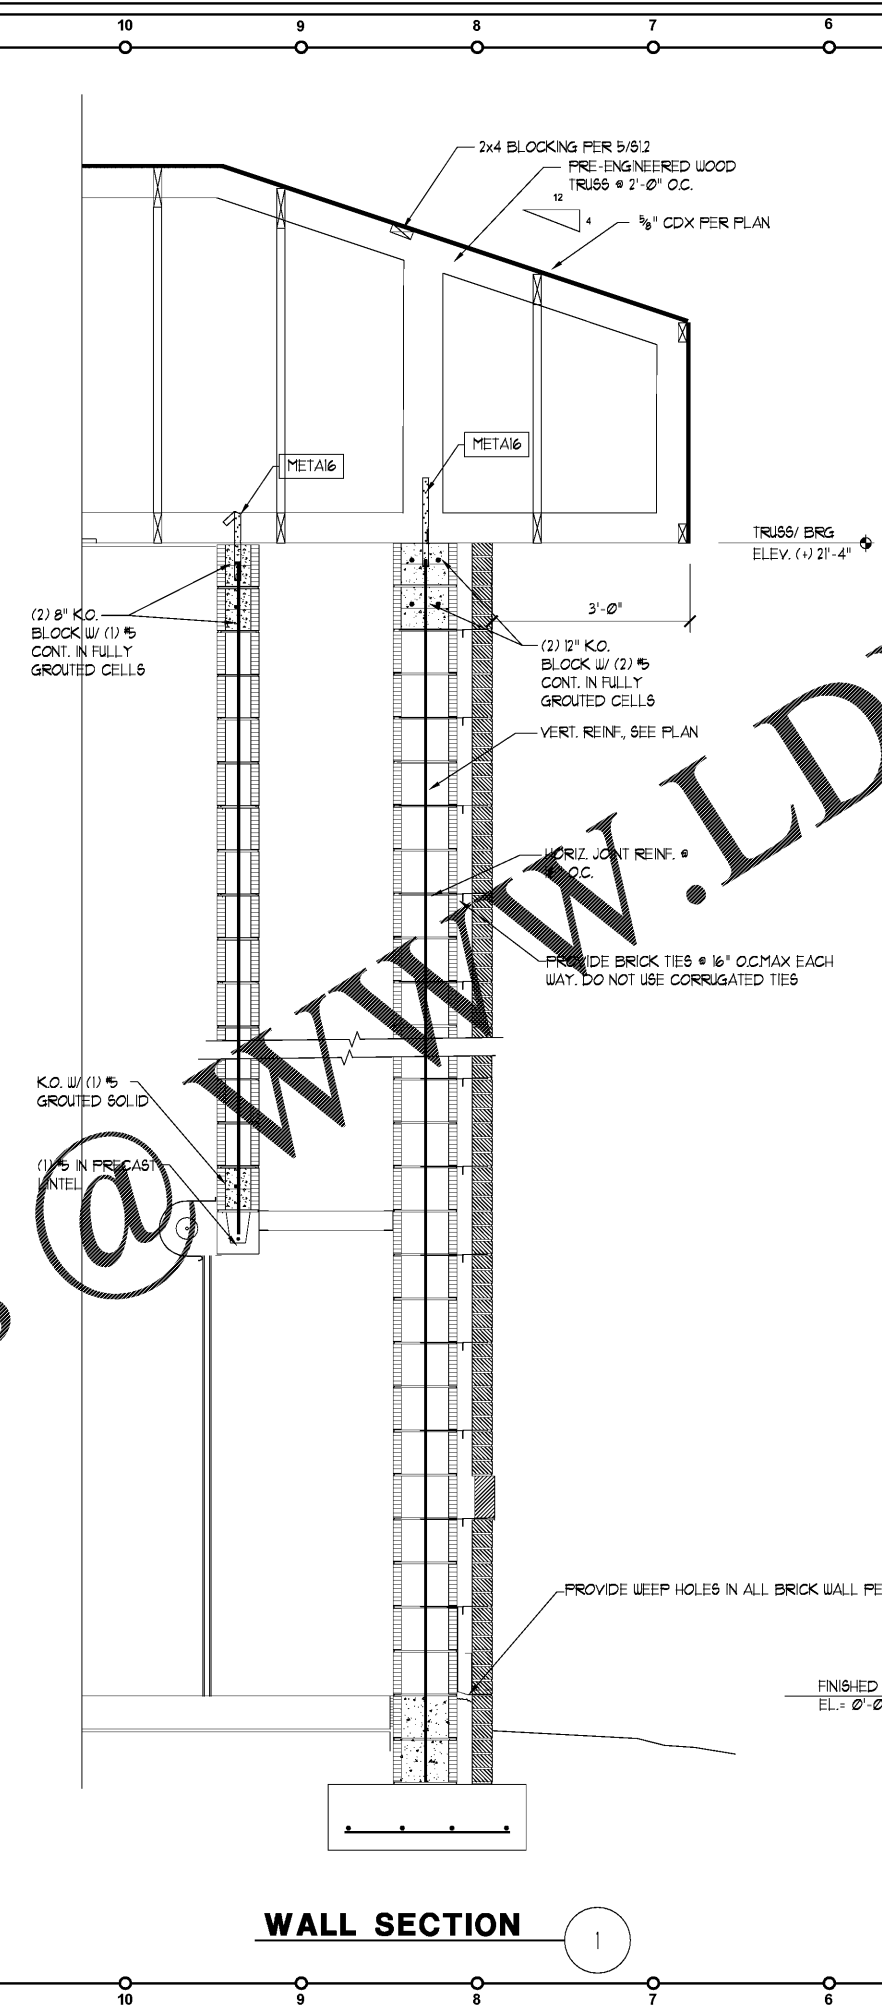

**WALL SECTION 1**

Order Plans

WWW.LDILine.com

02-25-20 DWG FleischmanGarcia/FGA/19039 - Pasco Fire Station 1/DESIGN/24.1.dwg

**Pennoni**  
 5755 R.C. VITO DRIVE  
 CHARLOTTE, NC 28217  
 (771) 536-8772  
 Charlotte, NC 28217 S.E.  
 Florida P.L. 7/2584  
 Pennoni Project No. 11040305

**FleischmanGarcia**  
 ARCHITECTS • ENGINEERS  
 2415 PARK AVENUE, SUITE 100  
 FORT WORTH, TEXAS 76104  
 PHONE (817) 724-8800  
 FAX (817) 724-8806  
 REGISTRATION NUMBER AA 000227

**Pasco County**  
**Fire & Rescue Station**  
**No. 17**  
 New Port Richey, Florida

THIS DESIGN AND DRAWING IS THE SOLE PROPERTY OF FLEISCHMAN-GARCIA AND SHALL BE REPRODUCED WITHOUT THEIR WRITTEN PERMISSION. NO PART OF THIS WORK MAY BE REPRODUCED WITHOUT THE WRITTEN PERMISSION OF FLEISCHMAN-GARCIA.  
 VERIFY TO THE BEST OF YOUR KNOWLEDGE THAT THESE DRAWINGS CORRECTLY REFLECT ALL RELEVANT BUILDING CODES.

**FGA PROJECT NUMBER**  
 19039

**ISSUE DATE**  
 05-25-20

**SHEET NUMBER**  
**S4.1**

TYPICAL BUILDING SECTIONS

S2.5  
3/4"=1'