


05-27-20  
Joanna Wicks, 20191010000 FGA CPA Fire Station 1/Manufacture/15-0000\_M5.1/PLM\_S2\_Contrct.dwg

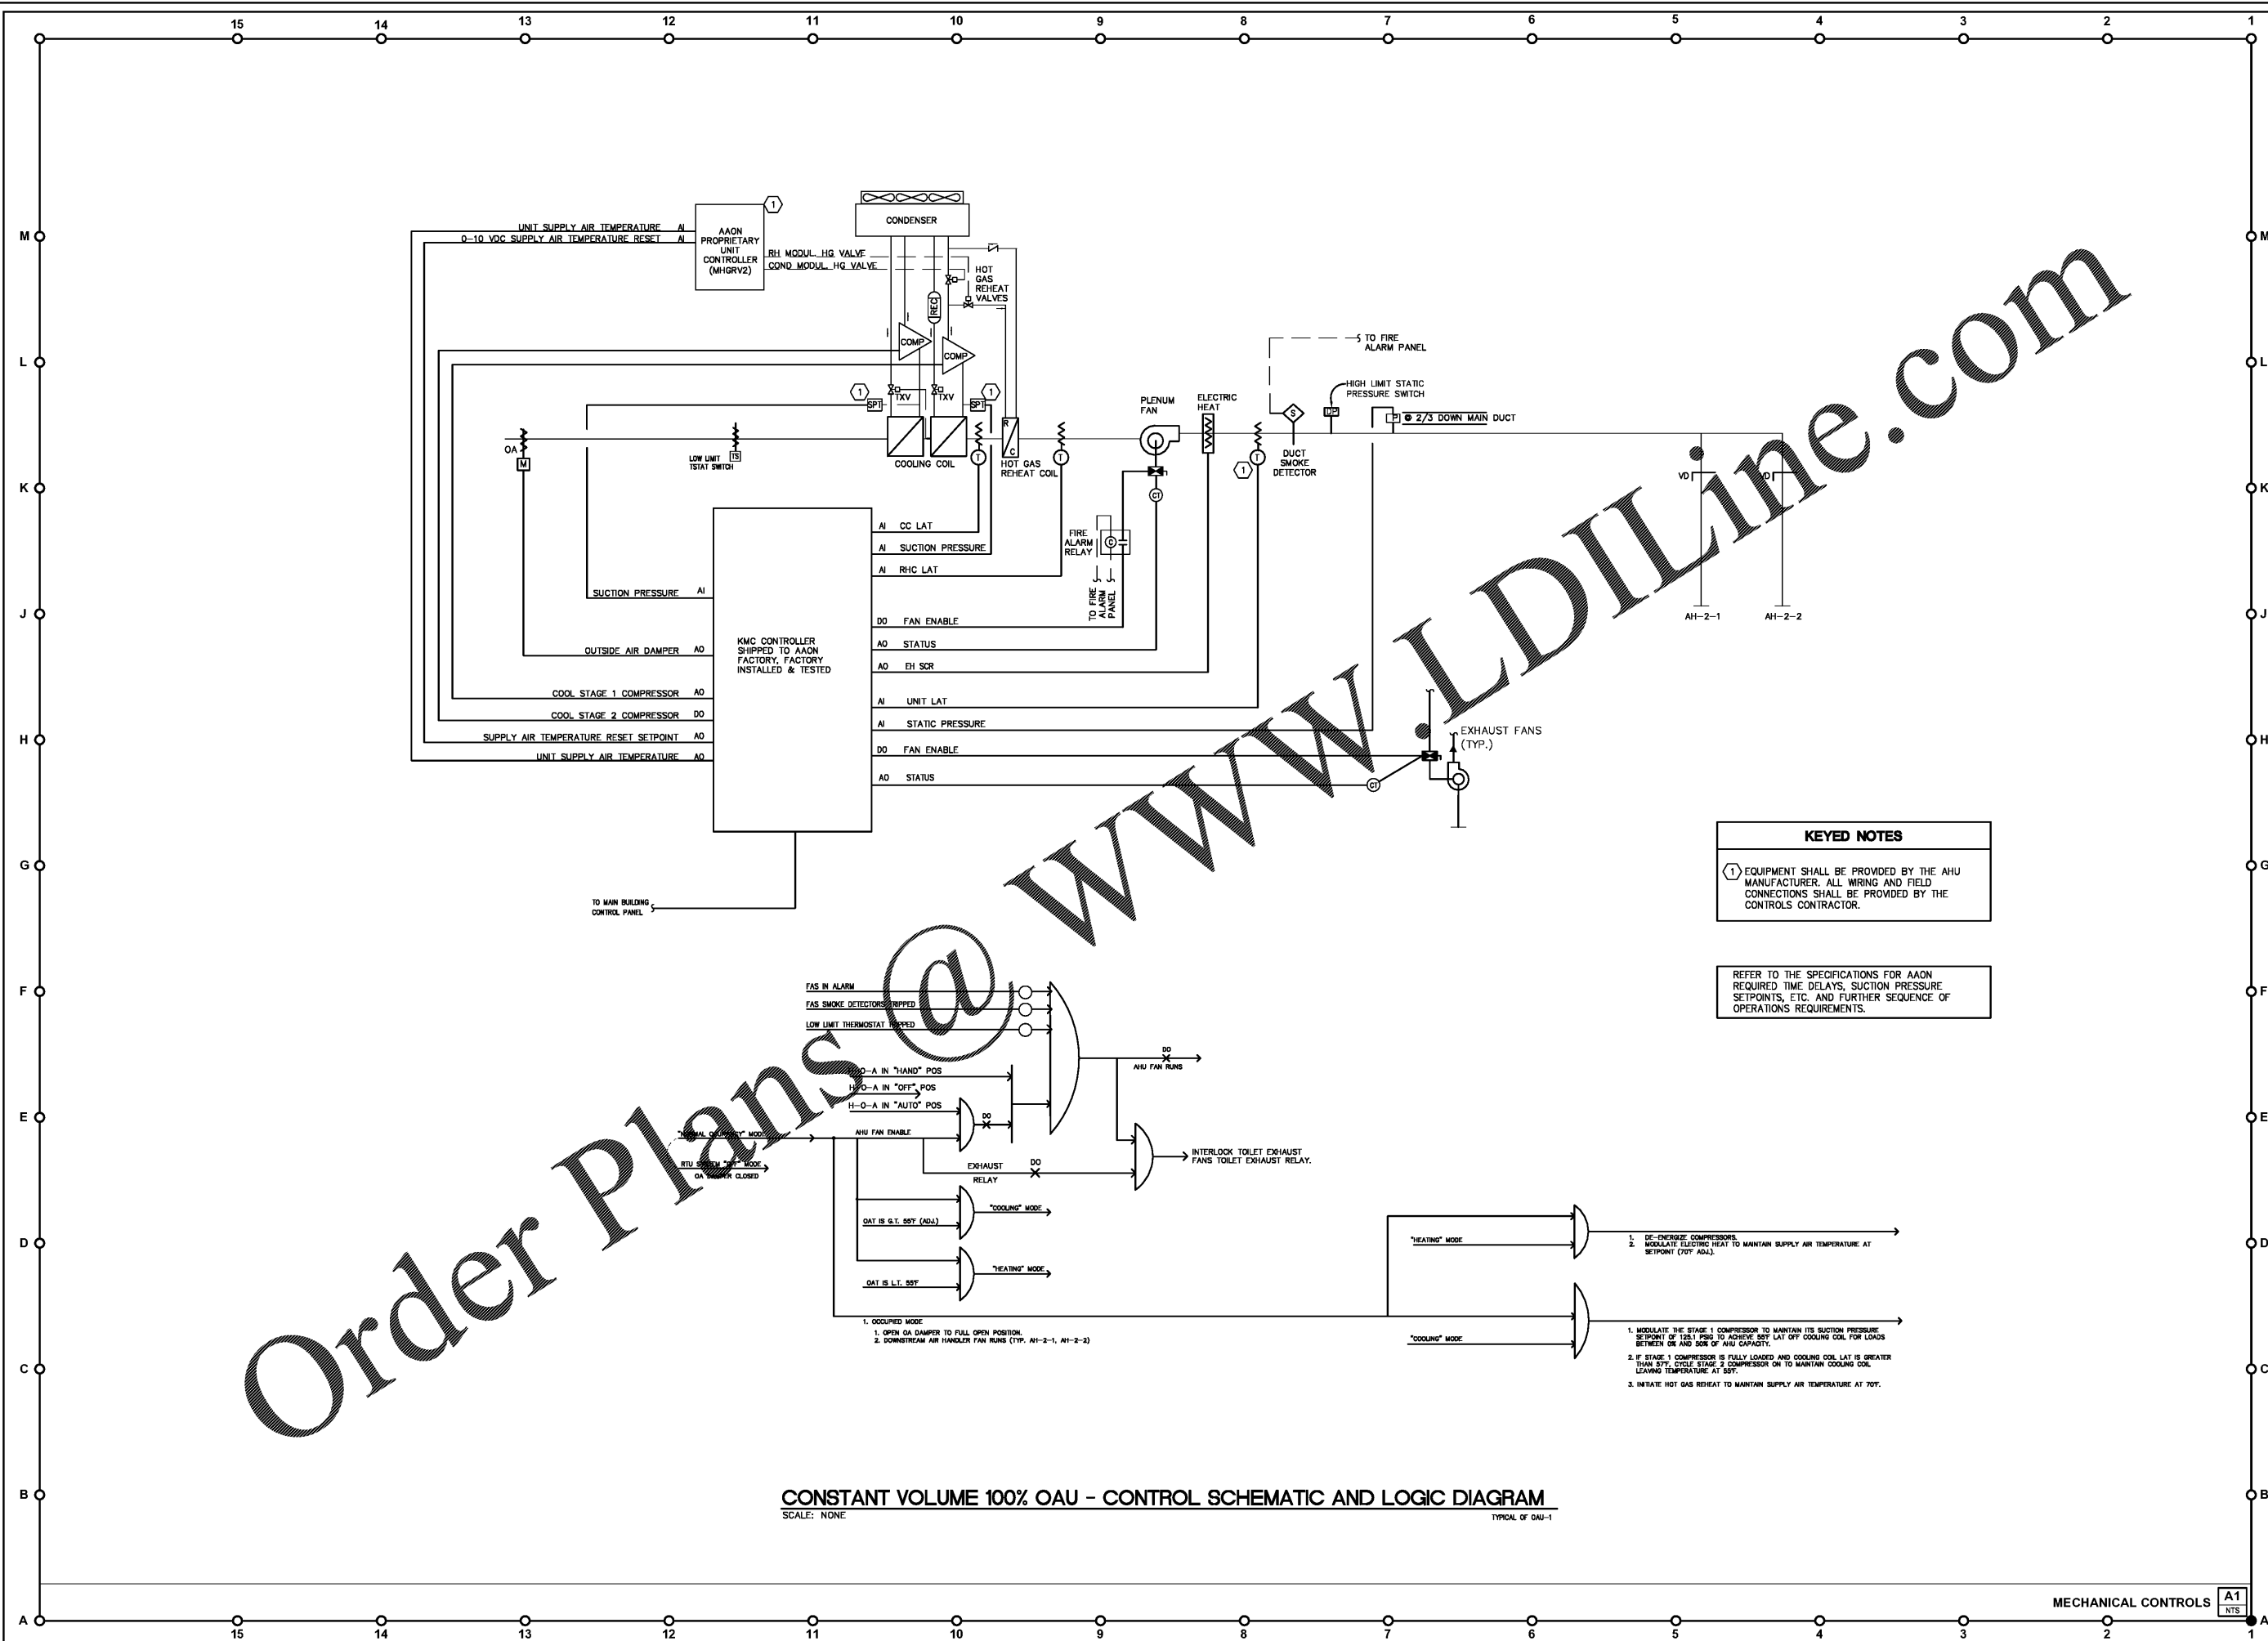

**CONSTANT VOLUME 100% OAU - CONTROL SCHEMATIC AND LOGIC DIAGRAM**  
SCALE: NONE  
TYPICAL OF OAU-1

**KEYED NOTES**

① EQUIPMENT SHALL BE PROVIDED BY THE AHU MANUFACTURER. ALL WIRING AND FIELD CONNECTIONS SHALL BE PROVIDED BY THE CONTROLS CONTRACTOR.

REFER TO THE SPECIFICATIONS FOR AON REQUIRED TIME DELAYS, SUCTION PRESSURE SETPOINTS, ETC. AND FURTHER SEQUENCE OF OPERATIONS REQUIREMENTS.

**ENGINEERING MATRIX, INC.**  
CONSULTING ENGINEERS  
2880 SCHEERER DRIVE, SUITE 640  
ST. PETERSBURG, FLORIDA, 33716  
(921) 392-4668 FAX(921) 391-8082 EMAIL: em@matrixeng.com  
CERT. OF AUTHORIZATION NO. 42898 EMI JOB NO. 19-0900  
© 2019 Engineering Matrix, Inc. DRAWN BY: CM CHECKED BY: JSW

**FleischmanGarcia**  
REGISTERED PROFESSIONAL ENGINEERS  
3511 13TH AVENUE, SUITE 300  
SAFETY HARBOR, FLORIDA 34622  
PHONE (813) 721-4400  
FAC (813) 725-2006  
REGISTRATION NUMBER: AA 000227

**Pasco County  
Fire & Rescue Station  
No. 17**  
New Port Richey, Florida

THIS DESIGN AND DRAWING IS THE SOLE PROPERTY OF FLEISCHMAN-GARCIA AND SHALL BE REPRODUCED WITH THE WRITTEN CONSENT OF FLEISCHMAN-GARCIA.  
NO PART OF THIS DESIGN OR DRAWING SHALL BE REPRODUCED OR TRANSMITTED IN ANY FORM OR BY ANY MEANS, ELECTRONIC OR MECHANICAL, INCLUDING PHOTOCOPYING, RECORDING, OR BY ANY INFORMATION STORAGE AND RETRIEVAL SYSTEM, WITHOUT THE WRITTEN PERMISSION OF FLEISCHMAN-GARCIA.

FGA PROJECT NUMBER  
**19039**

ISSUE DATE  
**05-25-20**

REVISIONS  
△ DATE: \_\_\_\_\_  
△ DATE: \_\_\_\_\_  
△ DATE: \_\_\_\_\_

SHEET NUMBER  
**M5.1**

MECHANICAL CONTROLS A1  
WTS