


05-25-20 Silver Dabell 1/2"=1'-0" P1118-0000 FGA CFA Fire Station 17/10/18/19/20/999/1000

Order Plans @ www.LDOnline.com

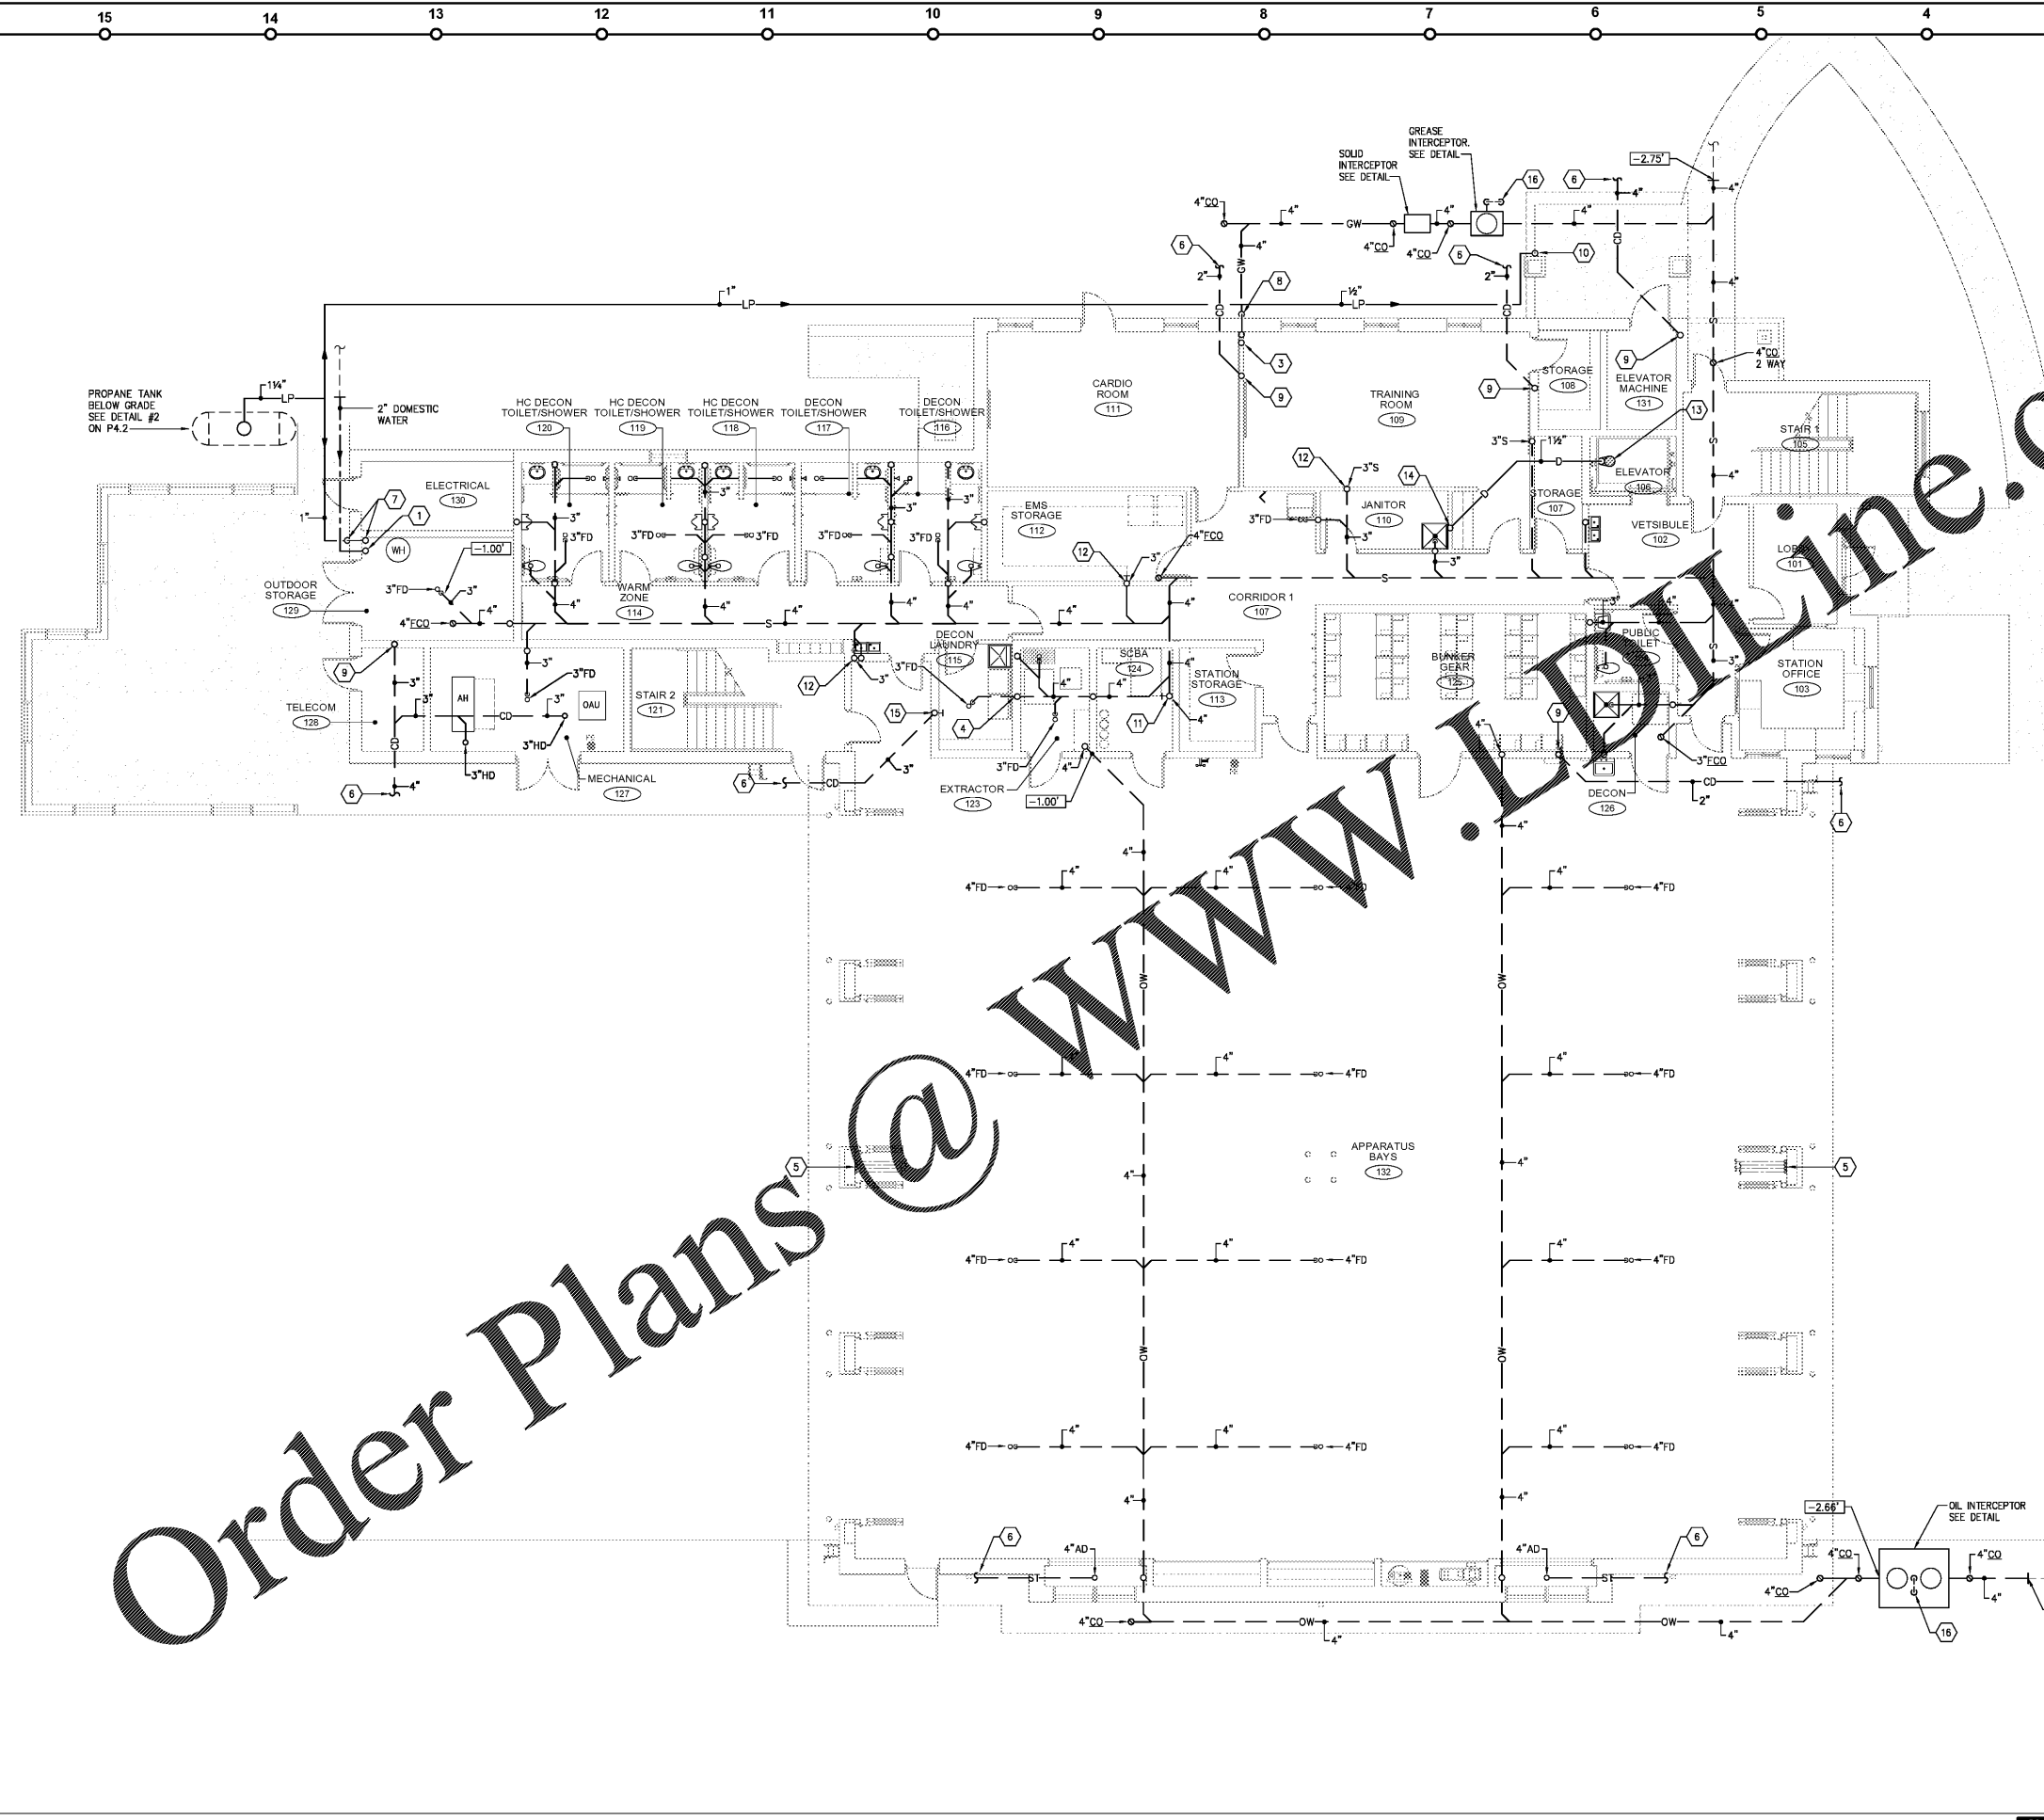

1. REFER TO SANITARY RISER DIAGRAMS FOR PIPE SIZES NOT SHOWN ON PLAN.
2. INVERT ELEVATIONS NOTED ON PLAN IS REFERENCED WITH A FINISHED FLOOR ELEVATION OF 0.00'.
3. ALL PIPING INSTALLED BELOW THE FOUNDATION SHALL BE INSTALLED IN PROTECTIVE PIPE SLEEVE.

GENERAL NOTES M1 NTS

PROPOSED DEMAND:
 TOTAL WATER FLOW UNITS = 281 @ 106 GPM
 (BASED ON FLUSH VALVES)
 TOTAL SANITARY FIXTURE UNITS = 167

BUILDING CALCULATIONS L1 NTS

- 1 WATER UP TO SHUTOFF VALVE. REFER TO PLUMBING FLOOR PLAN FOR CONTINUATION.
- 2 P-TRAP FOR ELEVATED TRENCH DRAIN. SEE DETAIL.
- 3 3" GREASE WASTE UP TO 2ND FLOOR.
- 4 3" WASHING MACHINE STACK.
- 5 ELECTRONIC TRAP PRIMER. REFER TO DETAIL 3/P5.2.
- 6 CONNECT TO STORM DRAINAGE FOR GUTTERS. REFER TO CIVIL PLANS FOR ADDITIONAL INFORMATION.
- 7 RISE LP GAS UP FROM BELOW GRADE ON EXTERIOR WALL, OFFSET PIPE ABOVE FINISHED FLOOR & RISE UP EXPOSED ON INTERIOR WALL. REFER TO ENLARGED PLUMBING PLAN FOR CONTINUATION.
- 8 RISE LP GAS UP FROM BELOW GRADE ON EXTERIOR WALL, OFFSET PIPE ABOVE FINISHED FLOOR & RISE UP IN INTERIOR WALL TO ABOVE CEILING. REFER TO ENLARGED PLUMBING PLAN FOR CONTINUATION.
- 9 2" CONDENSATE UP IN WALL FOR A.C. UNIT. REFER TO DETAIL 9/P4.2.
- 10 LP GAS UP TO PORTABLE GAS GRILLE ON SECOND LEVEL.
- 11 SANITARY UP INTO CEILING SPACE. INSTALL C.O. PLUG 12" A.F.F.
- 12 SANITARY UP INTO CEILING SPACE. INSTALL WCQ 12" A.F.F.
- 13 ELEVATOR SUMP PUMP. REFER TO DETAIL #6 ON P4.3.
- 14 OUTLET FOR SUMP PUMP. REFER TO DETAIL.
- 15 CONDENSATE UP IN WALL. PROVIDE WCQ AT BASE OF STACK.
- 16 GOOSENECK VENT 12" ABOVE FINISHED GRADE. TERMINATE WITH INSECT SCREEN.

APPARATUS BAYS 132

PLUMBING UNDERGROUND PLAN A3 1/8"=1'

KEYED NOTES A1 NTS

ENGINEERING MATRIX, INC.
 CONSULTING ENGINEERS
 2880 SCRIBNER DRIVE, SUITE 640
 ST. PETERSBURG, FLORIDA, 33716
 (727) 321-4668 FAX (727) 321-8062 EMAIL: enr@matrixeng.com
 CERT. OF AUTHORIZATION NO. 4898 E.M. JOB NO. 19-0960
 © 2019 Engineering Matrix, Inc. DRAWN BY: SCD CHECKED BY: JSW

FleischmanGarcia
 ARCHITECTS
 2511 WYNDHAM AVENUE, SUITE 300
 TAMPA, FLORIDA 33609
 PHONE (813) 281-1400
 FAX (813) 281-1400
 REGISTRATION NUMBER: AA 000227

Pasco County Fire & Rescue Station No. 17
 New Port Richey, Florida

THIS DESIGN AND DRAWING IS THE SOLE PROPERTY OF FLEISCHMAN-GARCIA ARCHITECTS. IT IS TO BE USED ONLY FOR THE PROJECT AND SITE SPECIFICALLY IDENTIFIED HEREIN. IT IS NOT TO BE REPRODUCED, COPIED, OR TRANSMITTED IN ANY FORM OR BY ANY MEANS, WITHOUT THE WRITTEN PERMISSION OF FLEISCHMAN-GARCIA ARCHITECTS.

FGA PROJECT NUMBER 19039

ISSUE DATE 05-25-20

REVISIONS
 DATE: _____
 DATE: _____
 DATE: _____

SHEET NUMBER P1.2