


Order Plans @ www.LDILine.com

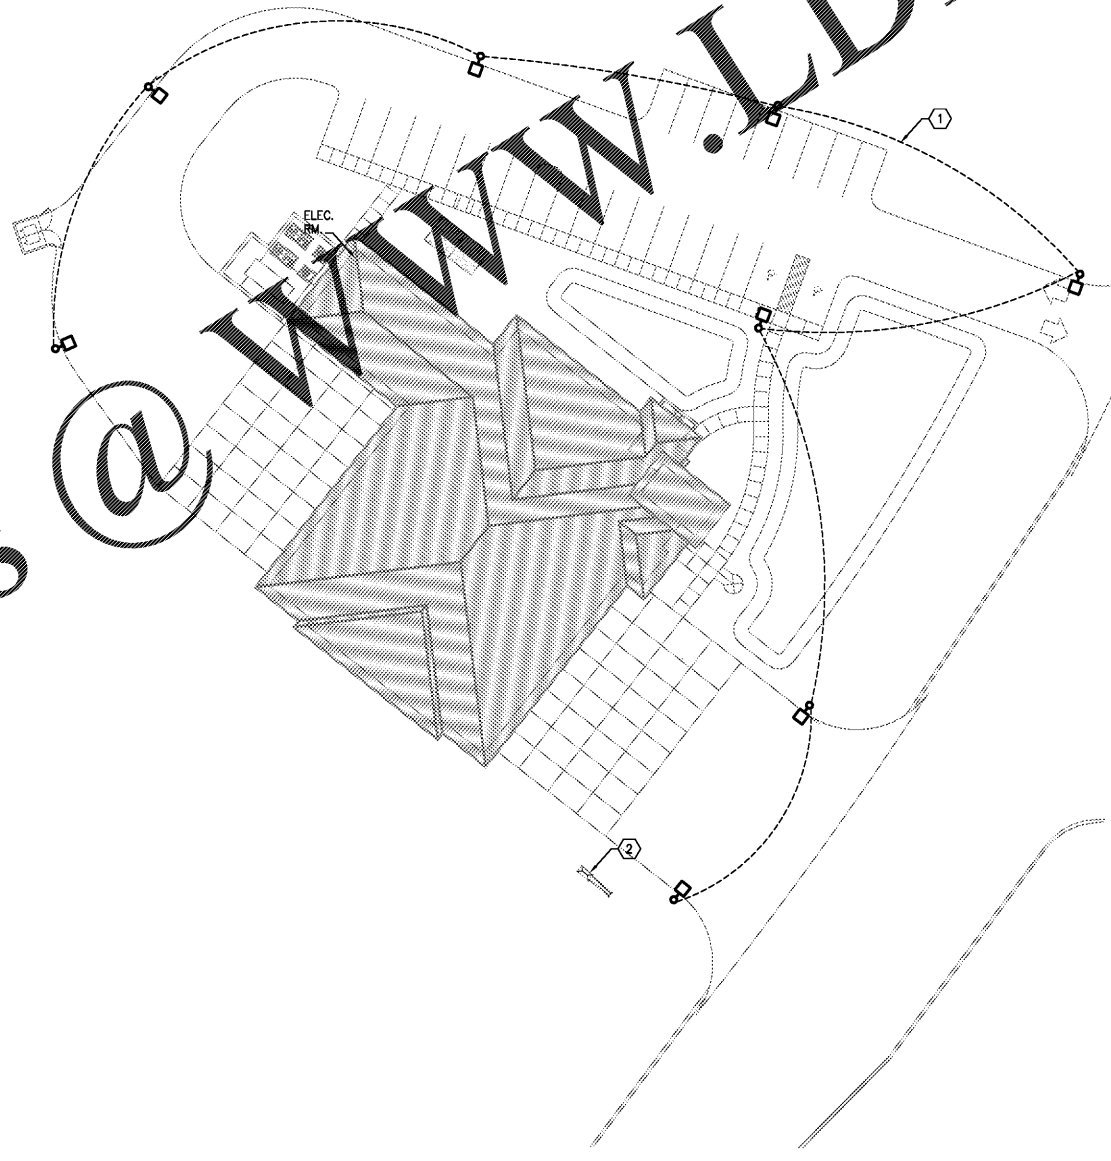

1. EXTERIOR LIGHT POLES AND FIXTURES SHALL BE PROVIDED BY UTILITY CO. CONTRACTOR SHALL PROVIDE CONDUIT FOR ALL SITE LIGHTING. THE POLE LOCATIONS AND CONDUIT ROUTING SHOWN ARE DIAGRAMMATIC. COORDINATE WITH OWNER AND UTILITY CO. FOR EXACT LAYOUT OF SITE LIGHTING FIXTURES AND CONDUIT REQUIREMENTS.

GENERAL NOTES M1
NTS

- ① PROVIDE 2" CONDUIT WITH PULL STRING UNDERGROUND TO ALL NEW LIGHT POLE LOCATIONS. COORDINATE EXACT LOCATION WITH UTILITY. FIXTURE AND POLE BY UTILITY, SHOWN FOR REFERENCE ONLY.
- ② INTERNALLY ILLUMINATED MONUMENT SIGN. REFER TO SHEET E1.2 FOR POWER REQUIREMENTS.

KEYED NOTES K1
NTS

LIGHTING SITE PLAN A3
1"=30'

ENGINEERING MATRIX, INC.
CONSULTING ENGINEERS
2880 SCHEERER DRIVE, SUITE 640
ST. PETERSBURG, FLORIDA 33716
(727) 372-4668 FAX (727) 571-8082 EMAIL: enr@matrixinc.com
CERT. OF AUTHORIZATION NO. 4898 P.E. JOB NO. 19-0900
© 2019 Engineering Matrix, Inc. DRAWN BY: JTH CHECKED BY: JSW

FleischmanGarcia
ARCHITECTS • INTERIORS • EXTERIORS
3511 13TH AVENUE, SUITE 300
SAFETY HARBOR, FLORIDA 34629
PHONE (813) 728-8800
FAX (813) 728-8800
REGISTRATION NUMBER: AA 000272

**Pasco County
Fire & Rescue Station
No. 17**
New Port Richey, Florida

THIS PERSON AND DRAWING IS THE SOLE PROPERTY OF FLEISCHMAN-GARCIA ARCHITECTS AND SHALL NOT BE REPRODUCED WITHOUT WRITTEN PERMISSION FROM FLEISCHMAN-GARCIA ARCHITECTS.

LETTERS TO THE BEST OF MY KNOWLEDGE THAT THESE DRAWINGS COMPLY WITH ALL RELEVANT BUILDING CODES.

FGA PROJECT NUMBER
19039

ISSUE DATE
05-25-20

REVISIONS
 △ DATE: _____
 △ DATE: _____
 △ DATE: _____

SHEET NUMBER
E1.1