



Z:\Mtnr\Projects\2020\Projects\20-04-CCSD-I.T. Dept\DRAWINGS\CD Construction Documents\I.T. MODEL.IT.DBF.CD.rvt


PRINTED: 10/27/2020 3:49:12 PM

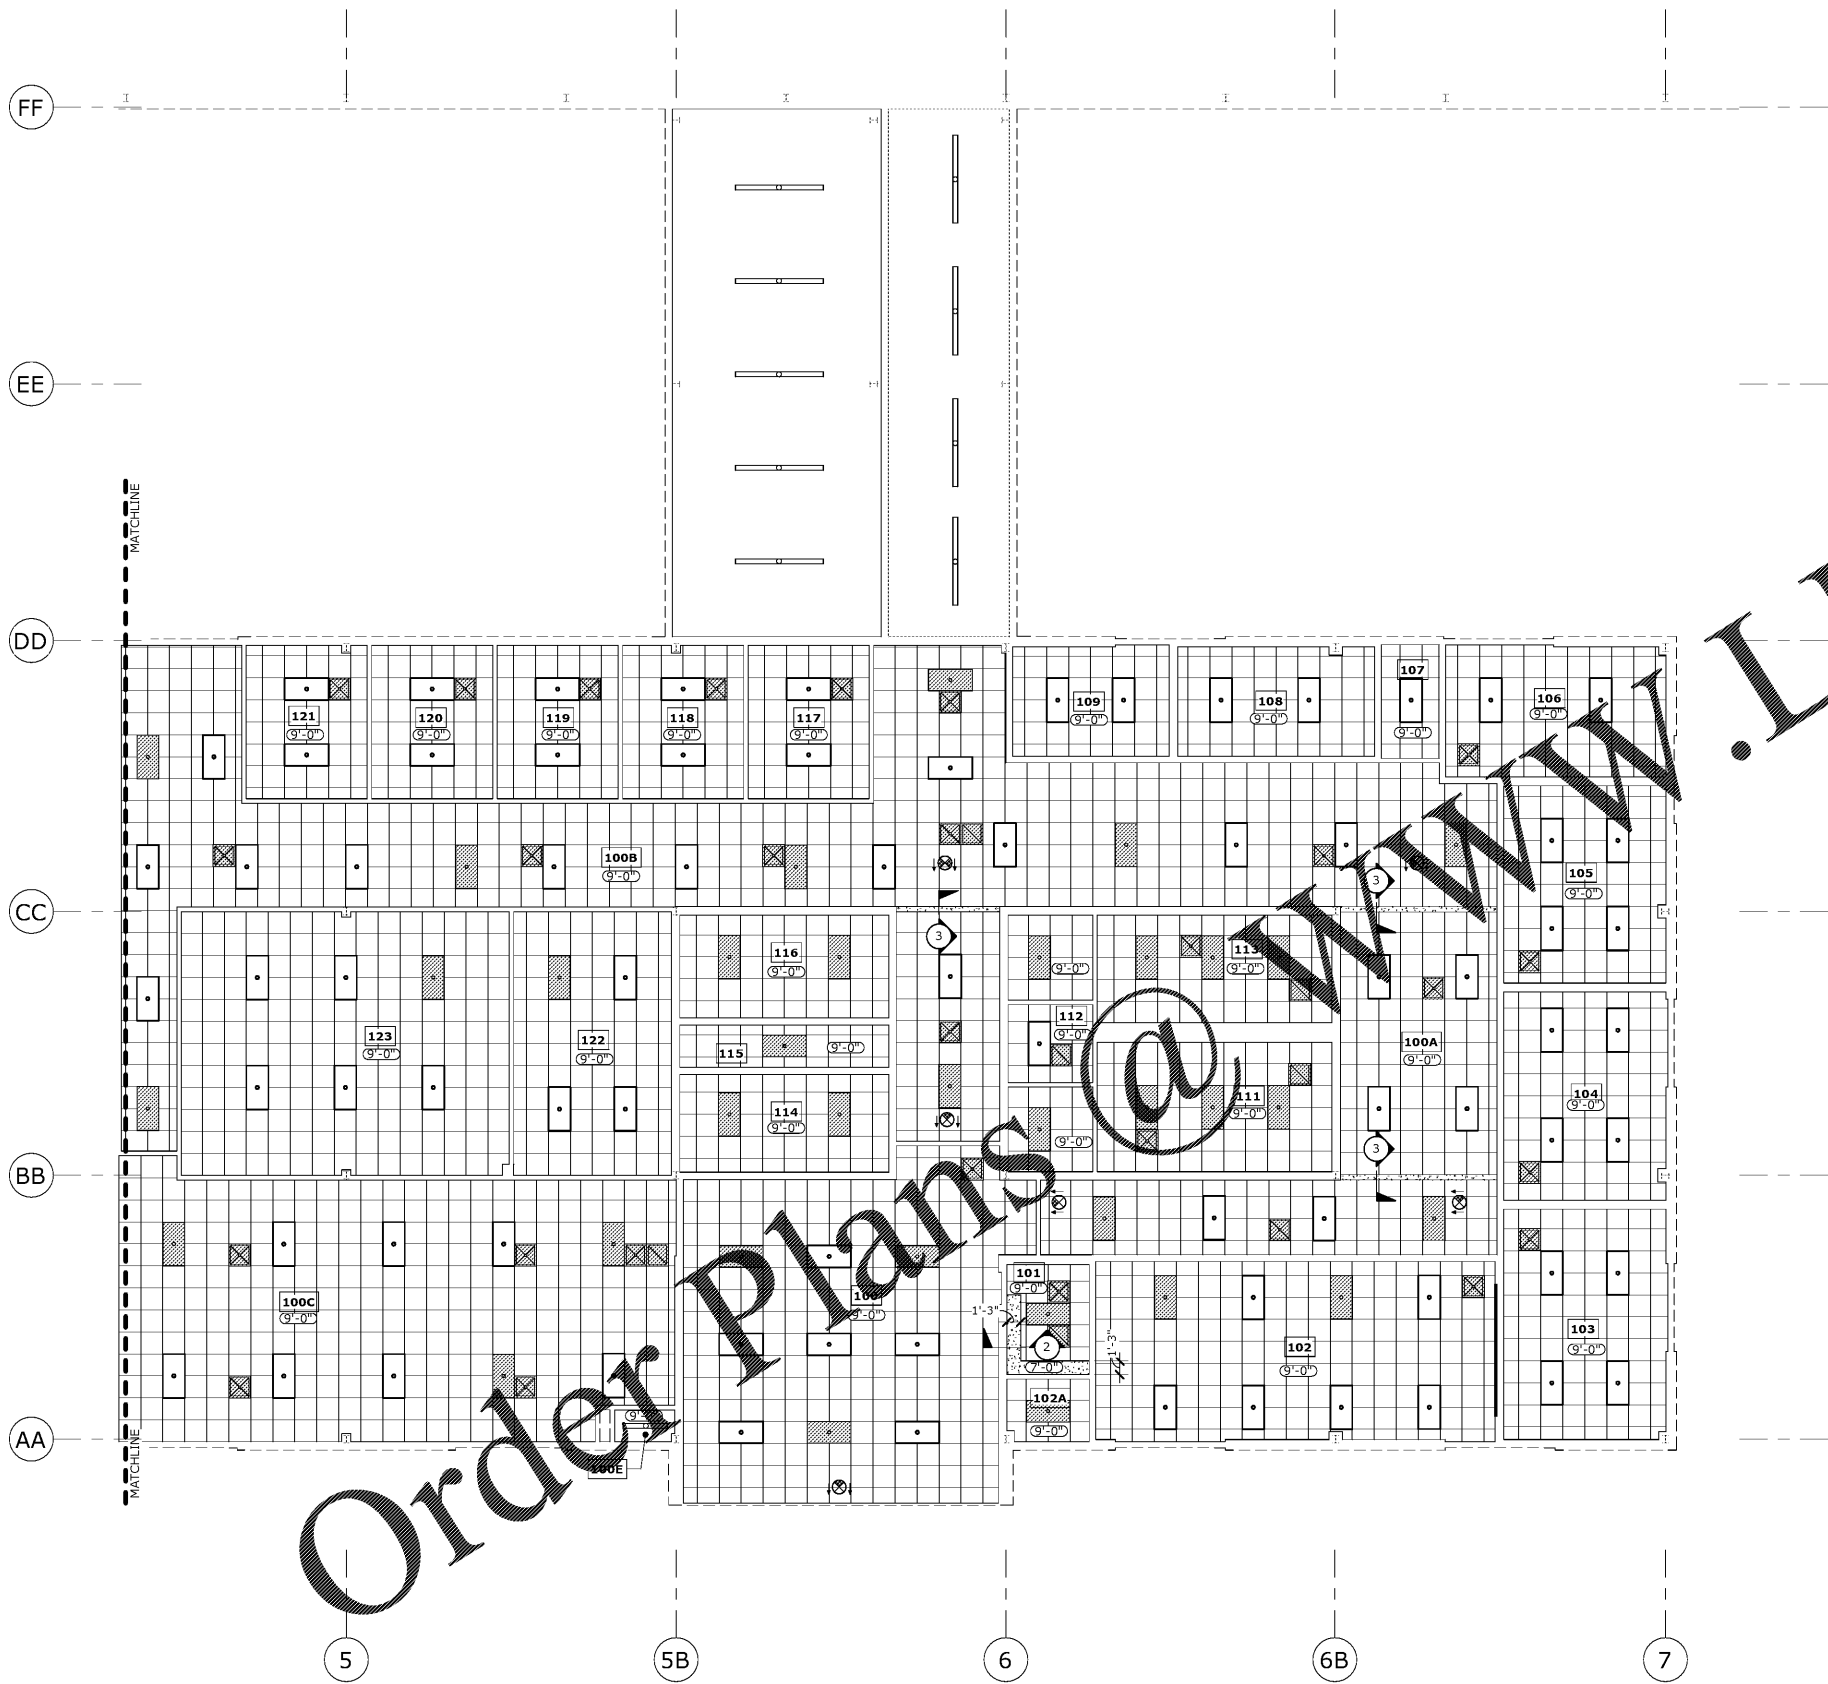

- RCP LEGEND:**
- NEW CEILING OUTLINE
 - - - WALL OUTLINE
 - NEW 2X2 ACOUSTICAL CEILING TILE AND SUSPENDED GRID
 - GPDW CEILING/ BULKHEAD
 - 2 X 4 EMERGENCY L.E.D. LIGHT FIXTURE
 - 2 X 4 L.E.D. LIGHT FIXTURE
 - HVAC SUPPLY DIFFUSER
 - HVAC RETURN GRILLE
 - EXIT SIGN
 - STRIP LIGHT FIXTURE, SURFACE MOUNTED

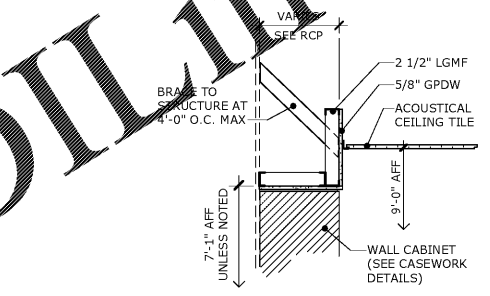

2 SECTION @ WALL CABINET
SCALE: 3/4" = 1'-0"

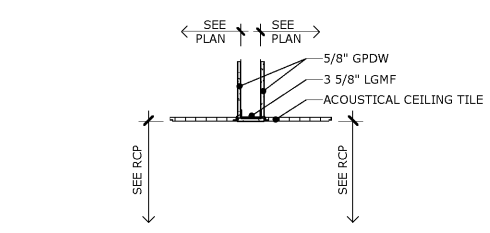

3 SECTION @ CEILING
SCALE: 3/4" = 1'-0"

2.K.M. ARCHITECTS, INC.
ROBERT L. MAULDIN
10/26/2020
REGISTERED ARCHITECT
529 GREENE ST. AUGUSTA, GA. 30901
(706) 736-3333 - FAX (706) 736-7100

This document is the property of 2KM Architects, Inc. The unauthorized reproduction, copying, or otherwise use of this document is strictly prohibited and any infringement thereupon may be subject to legal action. Copyright © 2020, 2KM Architects, Inc.

KEY PLAN:

AREA OF WORK: 11,957 SF

REVISIONS:

Date	Description

**CCSD
I.T./TRAINING
DEPARTMENT**

FOR
COLUMBIA COUNTY SCHOOL DISTRICT

4395 RIVERWATCH PARKWAY
EVANS, GA 30809

DRAWING TITLE
**REFLECTED CEILING
PLAN**

PROJECT NO. 20-04C	DRAWING NO.
DATE 10/26/2020	A1.4
DRAWN BY MP	
PAPER 24"x36"	
ISSUE CD	

1 REFLECTED CEILING PLAN
SCALE: 1/8" = 1'-0"