




ROBERT JOHNSON
architects
1808 West Morehead St.
Charlotte, NC 28208
T 704 / 342.1058
F 704 / 342.3043

STAMPS

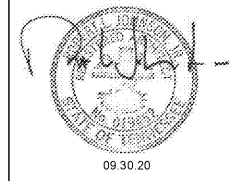

CONSULTANT

MIDSOUTH
CARPENTER'S
TRAINING
TRUST
LA VERGNE, TN

PROJECT NUMBER 1982
ISSUE DATE
FOR PERMIT 09.30.20


DRAWING DATA
DRAWN BY: BM/LM
CHECKED BY: TH

SHEET TITLE
GROUND
FLOOR
EQUIPMENT
PLAN

This drawing is the property of ROBERT JOHNSON ARCHITECTS, Inc. and is not to be reproduced or copied in whole or in part. It is only to be used for the project and site specifically identified herein and is not to be used on any other project. It is to be returned upon request.

SHEET NUMBER

A-1.9

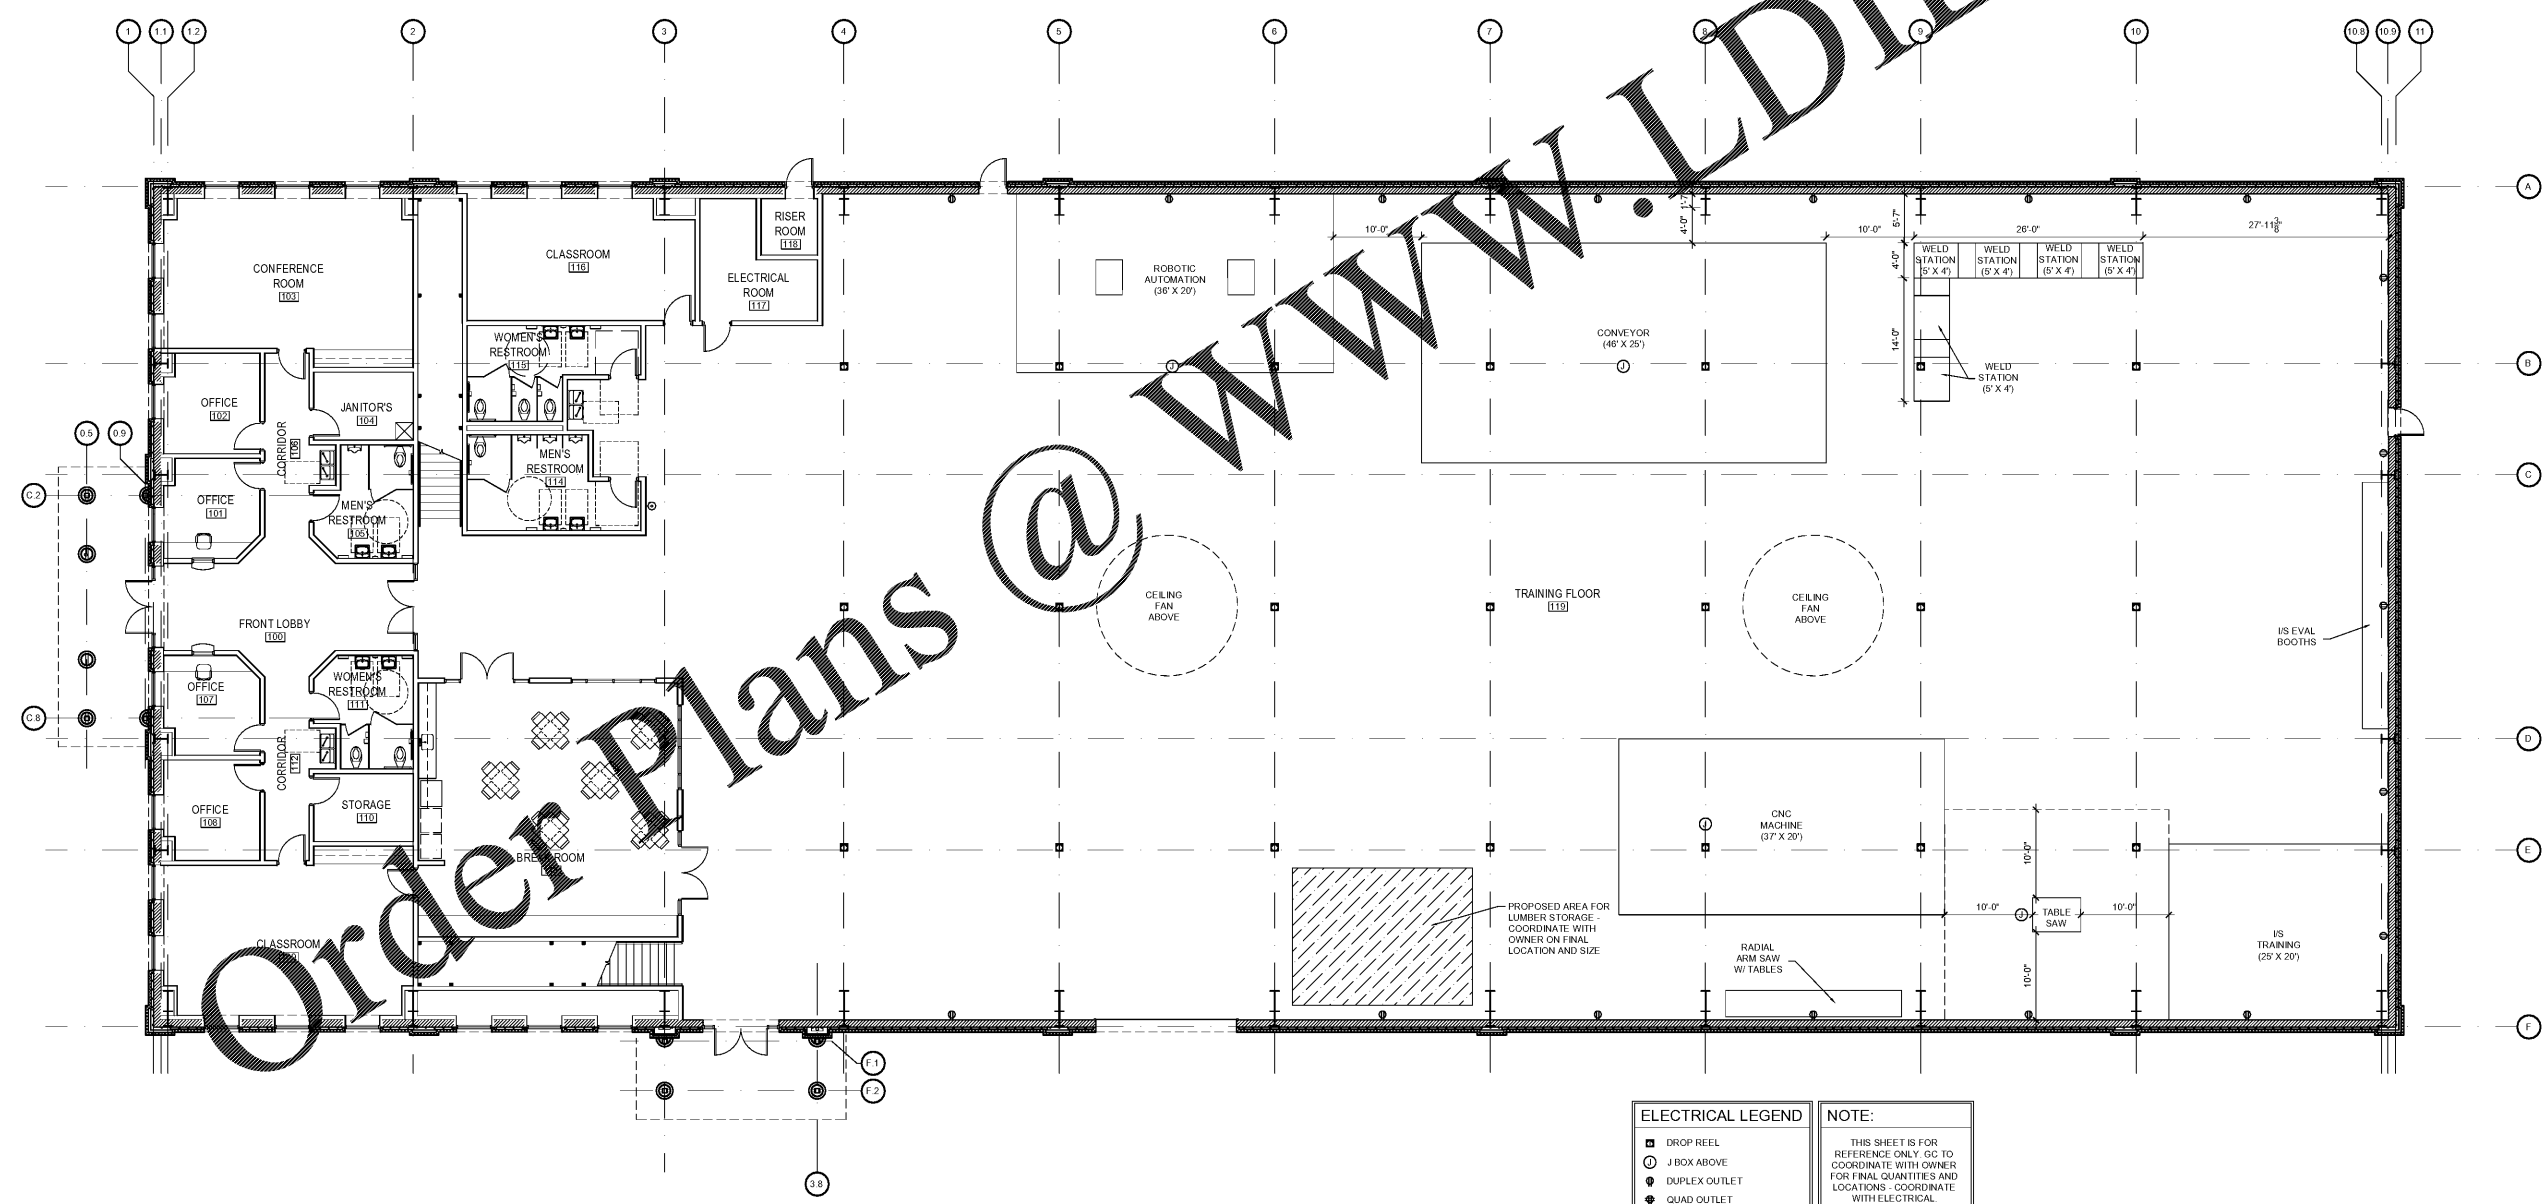

ELECTRICAL LEGEND	NOTE:
■ DROP REEL	THIS SHEET IS FOR REFERENCE ONLY. GO TO COORDINATE WITH OWNER FOR FINAL QUANTITIES AND LOCATIONS - COORDINATE WITH ELECTRICAL.
○ J BOX ABOVE	
● DUPLEX OUTLET	
◆ QUAD OUTLET	

1 GROUND FLOOR EQUIPMENT PLAN
A-1.9 SCALE: 1/8" = 1'-0"

WWW.LDILine.com

Order Plans @