




ROBERT JOHNSON
architects
1808 West Morehead St.
Charlotte, NC 28208
T 704 / 342.1058
F 704 / 342.3043

STAMPS



CONSULTANT

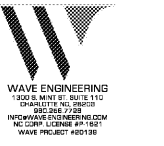

MIDSOUTH
CARPENTER'S
TRAINING
TRUST

La Vergne, TN

PROJECT NUMBER 1987
ISSUE DATE
FOR PERMIT 09.30.20


DRAWING DATA
DRAWN BY: MJS
CHECKED BY: MJS

SHEET TITLE
FIRE
PROTECTION
MAIN FLOOR
PLAN

This drawing is the property of ROBERT JOHNSON ARCHITECTS, Inc. and is not to be reproduced or copied in whole or in part. It is only to be used for the project and site specifically identified herein and is not to be used on any other project. It is to be returned upon request.

SHEET NUMBER

FP-1.1

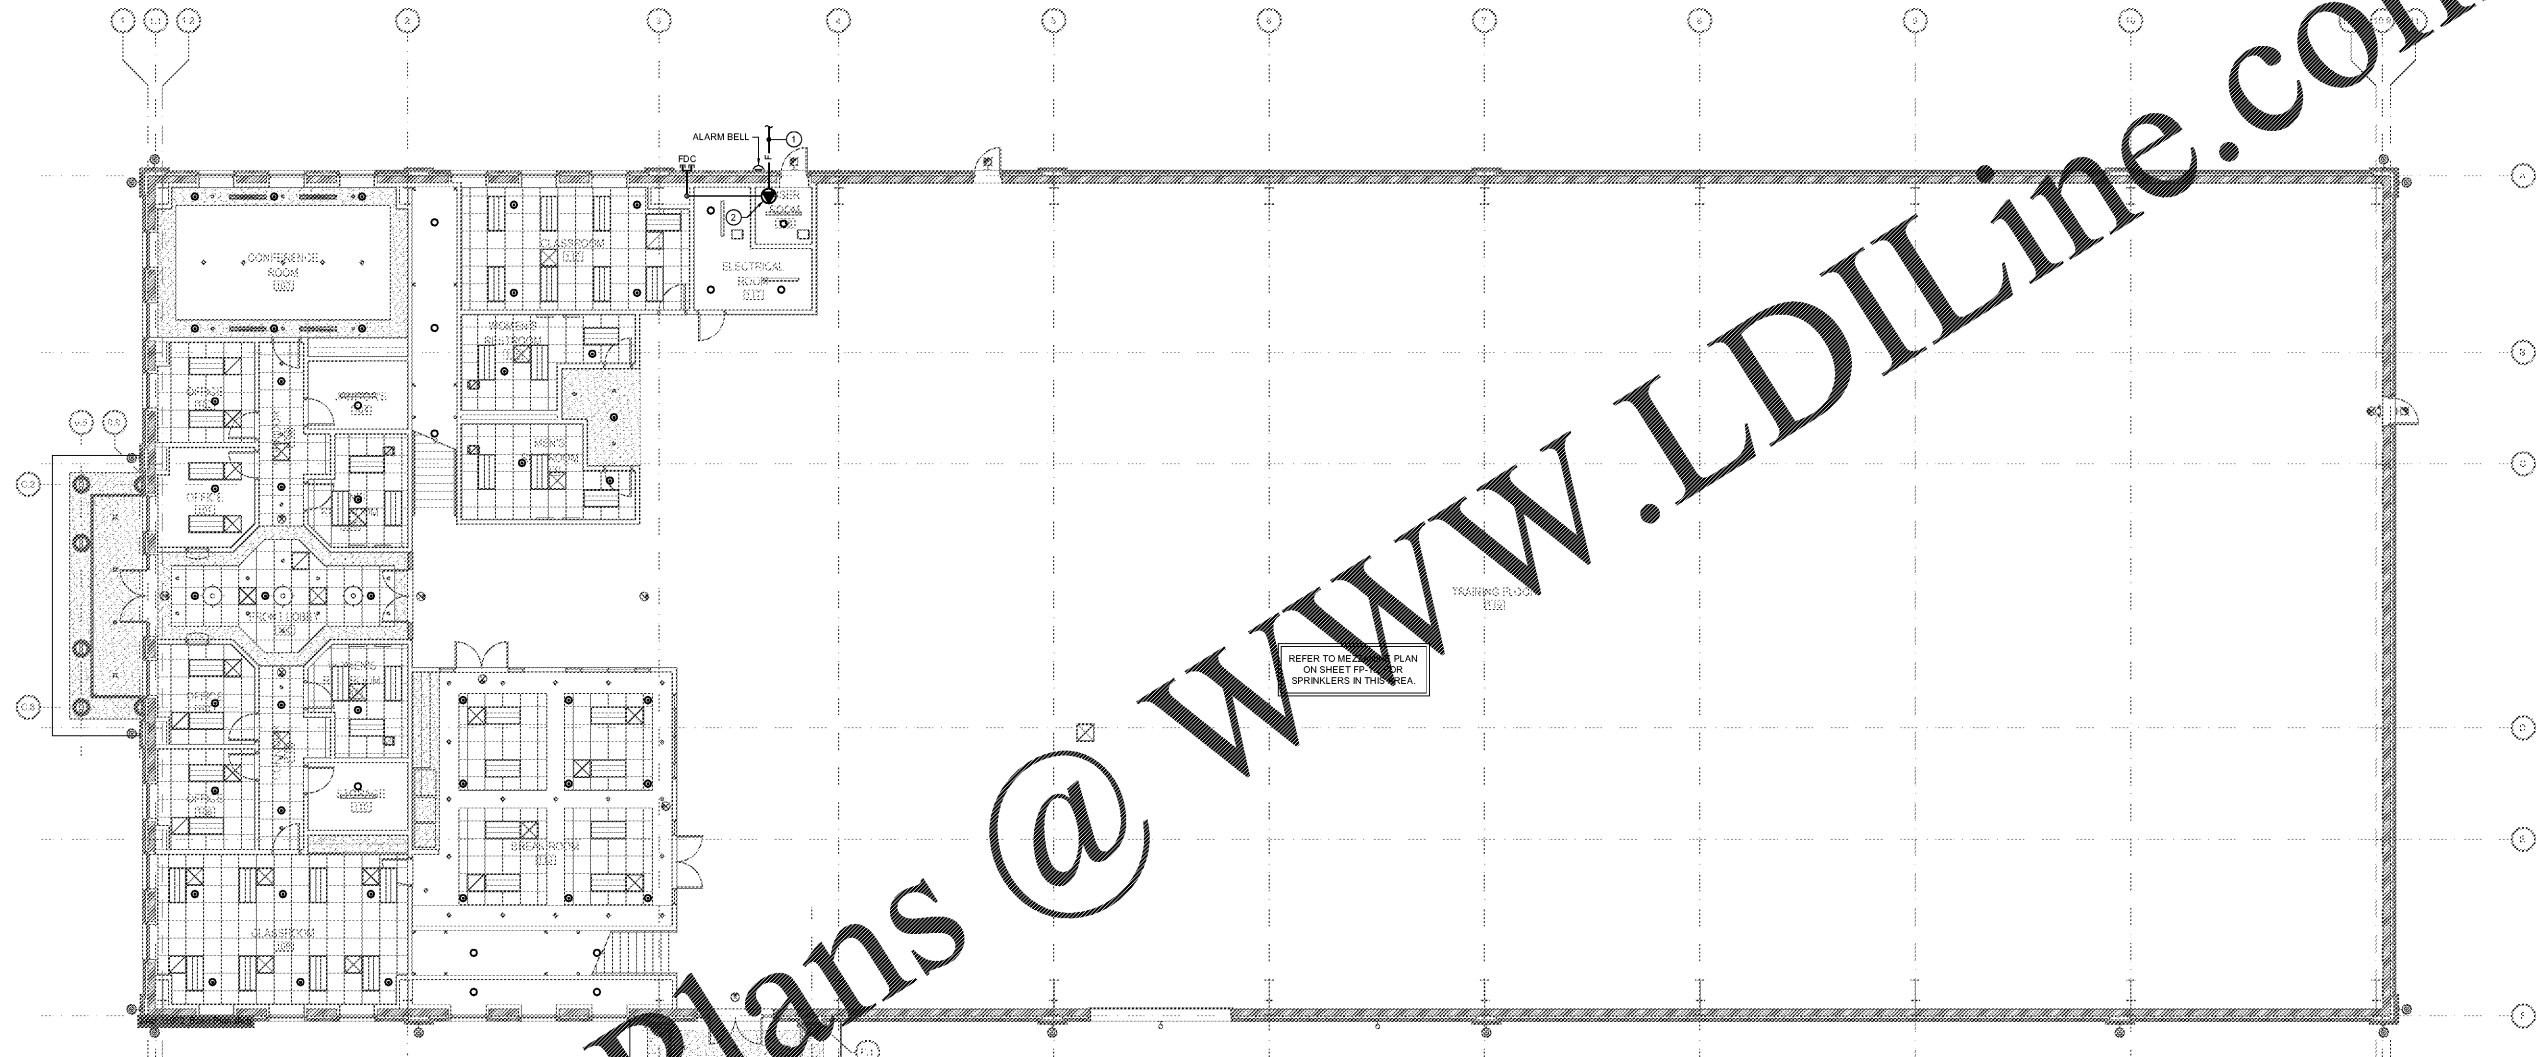

Order Plans @ www.LDILine.com

1 FIRE PROTECTION MAIN FLOOR PLAN
SCALE: 1/8" = 1'-0"

KEYED NOTES THIS SHEET	
①	FIRE SERVICE MAIN BELOW GRADE BY SITE UTILITY CONTRACTOR. REFER TO SITE UTILITY PLANS FOR CONTINUATION.
②	FIRE SERVICE ENTRANCE RISER. SEE DETAIL #1 ON SHEET FP-0.1.