



ROBERT JOHNSON
architects
1808 West Morehead St.
Charlotte, NC 28208
T 704 / 342.1058
F 704 / 342.3043

STAMPS



CONSULTANT



MIDSOUTH
CARPENTER'S
TRAINING
TRUST

La Vergne, TN

PROJECT NUMBER 1982
ISSUE DATE
FOR PERMIT 09.30.20


DRAWING DATA
DRAWN BY: SBC
CHECKED BY: MJS

SHEET TITLE
PLUMBING
ROOF PLAN

This drawing is the property of ROBERT JOHNSON ARCHITECTS, Inc. and is not to be reproduced or copied in whole or in part. It is only to be used for the project and site specifically identified herein and is not to be used on any other project. It is to be returned upon request.

SHEET NUMBER

P-1.3

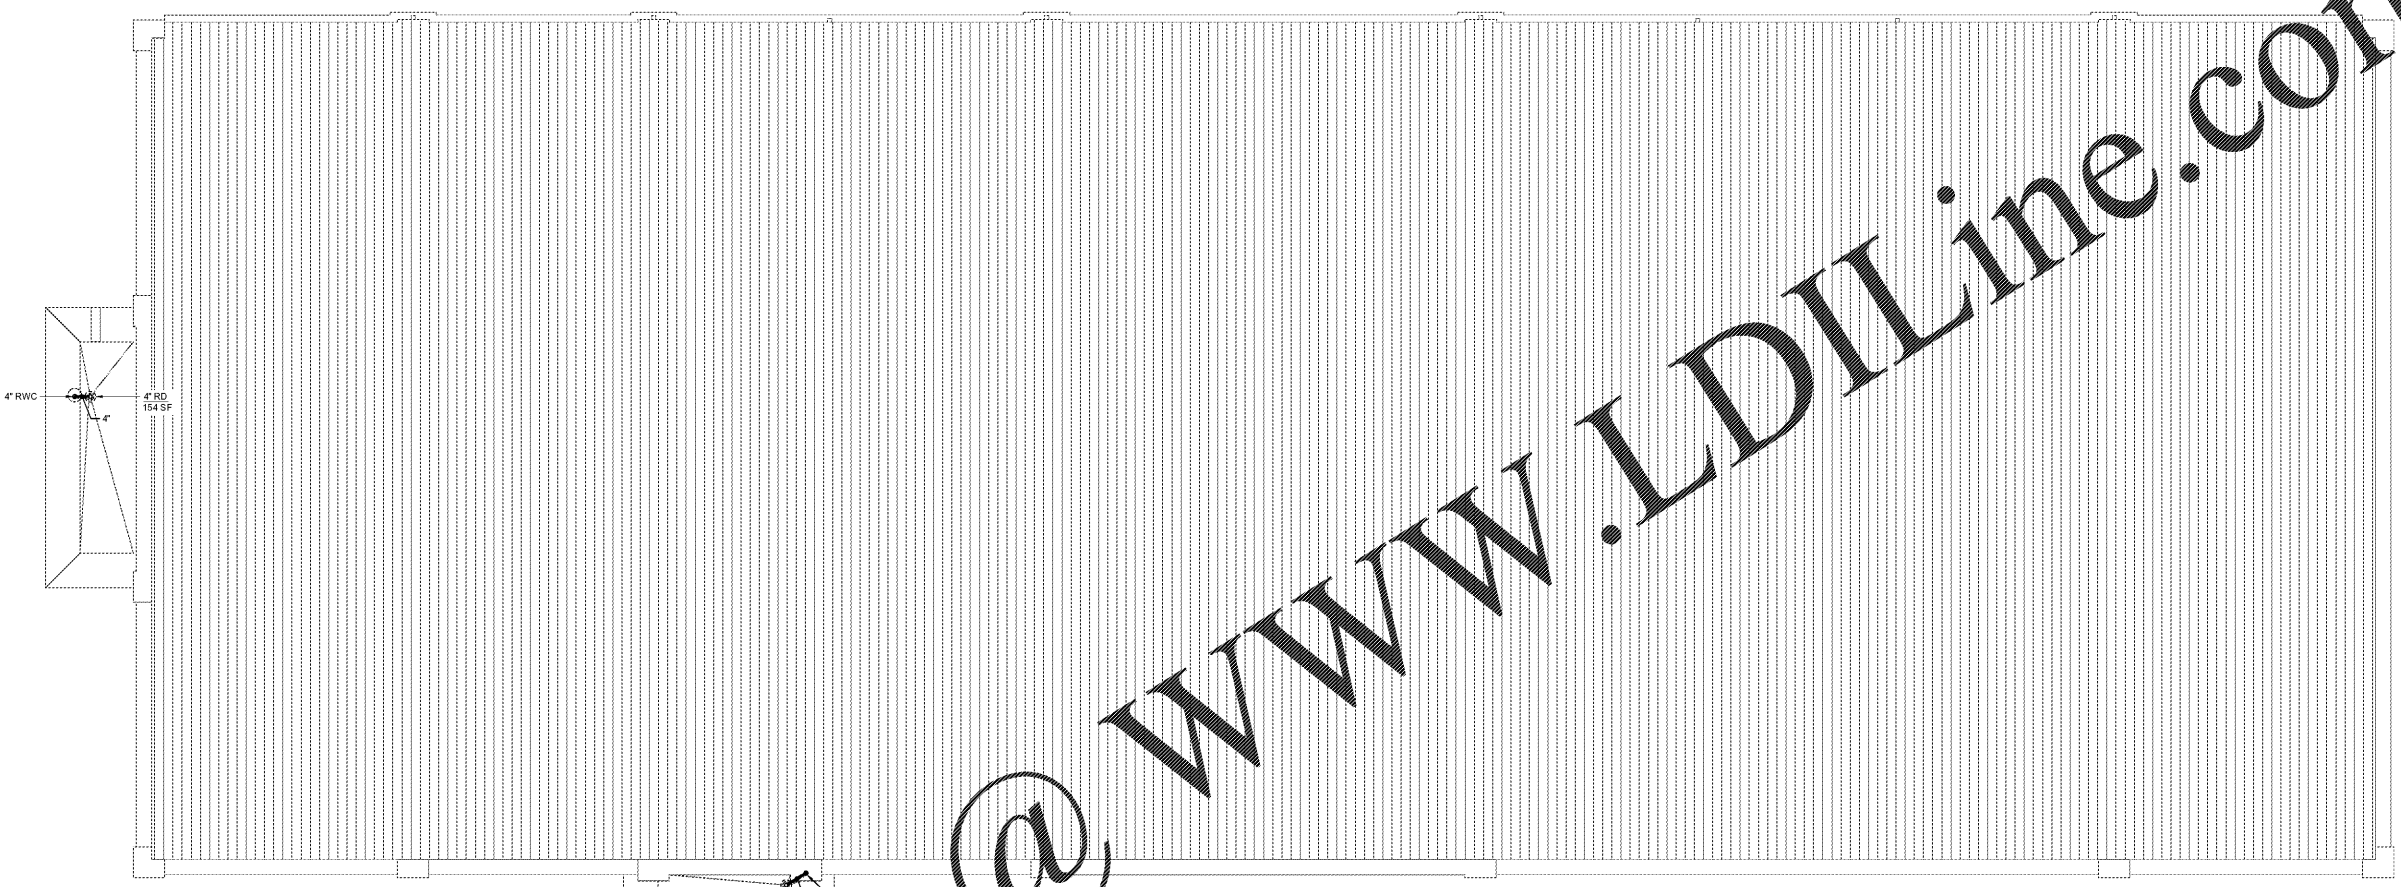

1 PLUMBING ROOF PLAN
P-1.3 SCALE: 1/8" = 1'-0"

GENERAL NOTES THIS SHEET
1. ALL STORM DRAIN PIPING SHOWN ON THIS SHEET SHALL BE RUN BELOW ROOF, ABOVE CEILINGS BELOW, UNLESS OTHERWISE NOTED.

Order Plans @ www.LDILine.com