




ROBERT JOHNSON
architects
1808 West Morehead St.
Charlotte, NC 28208
T 704 / 342.1058
F 704 / 342.3043

STAMPS



CONSULTANT

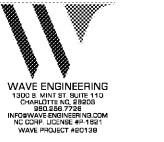

MIDSOUTH
CARPENTER'S
TRAINING
TRUST

La Vergne, TN

PROJECT NUMBER 1987
ISSUE DATE
FOR PERMIT 09.30.20





DRAWING DATA
DRAWN BY: GKG
CHECKED BY: MJS

SHEET TITLE
ELECTRICAL
SITE PLAN

This drawing is the property of ROBERT JOHNSON ARCHITECTS, INC. and is not to be reproduced or copied in whole or in part. It is only to be used for the project and site specifically identified herein and is not to be used on any other project. It is to be returned upon request.

SHEET NUMBER

E-1.0

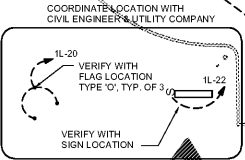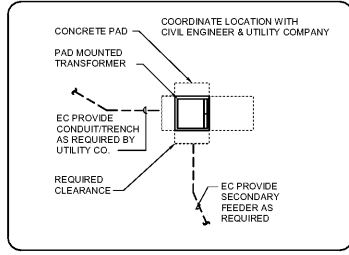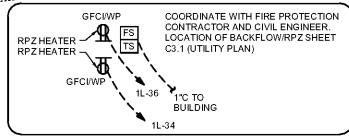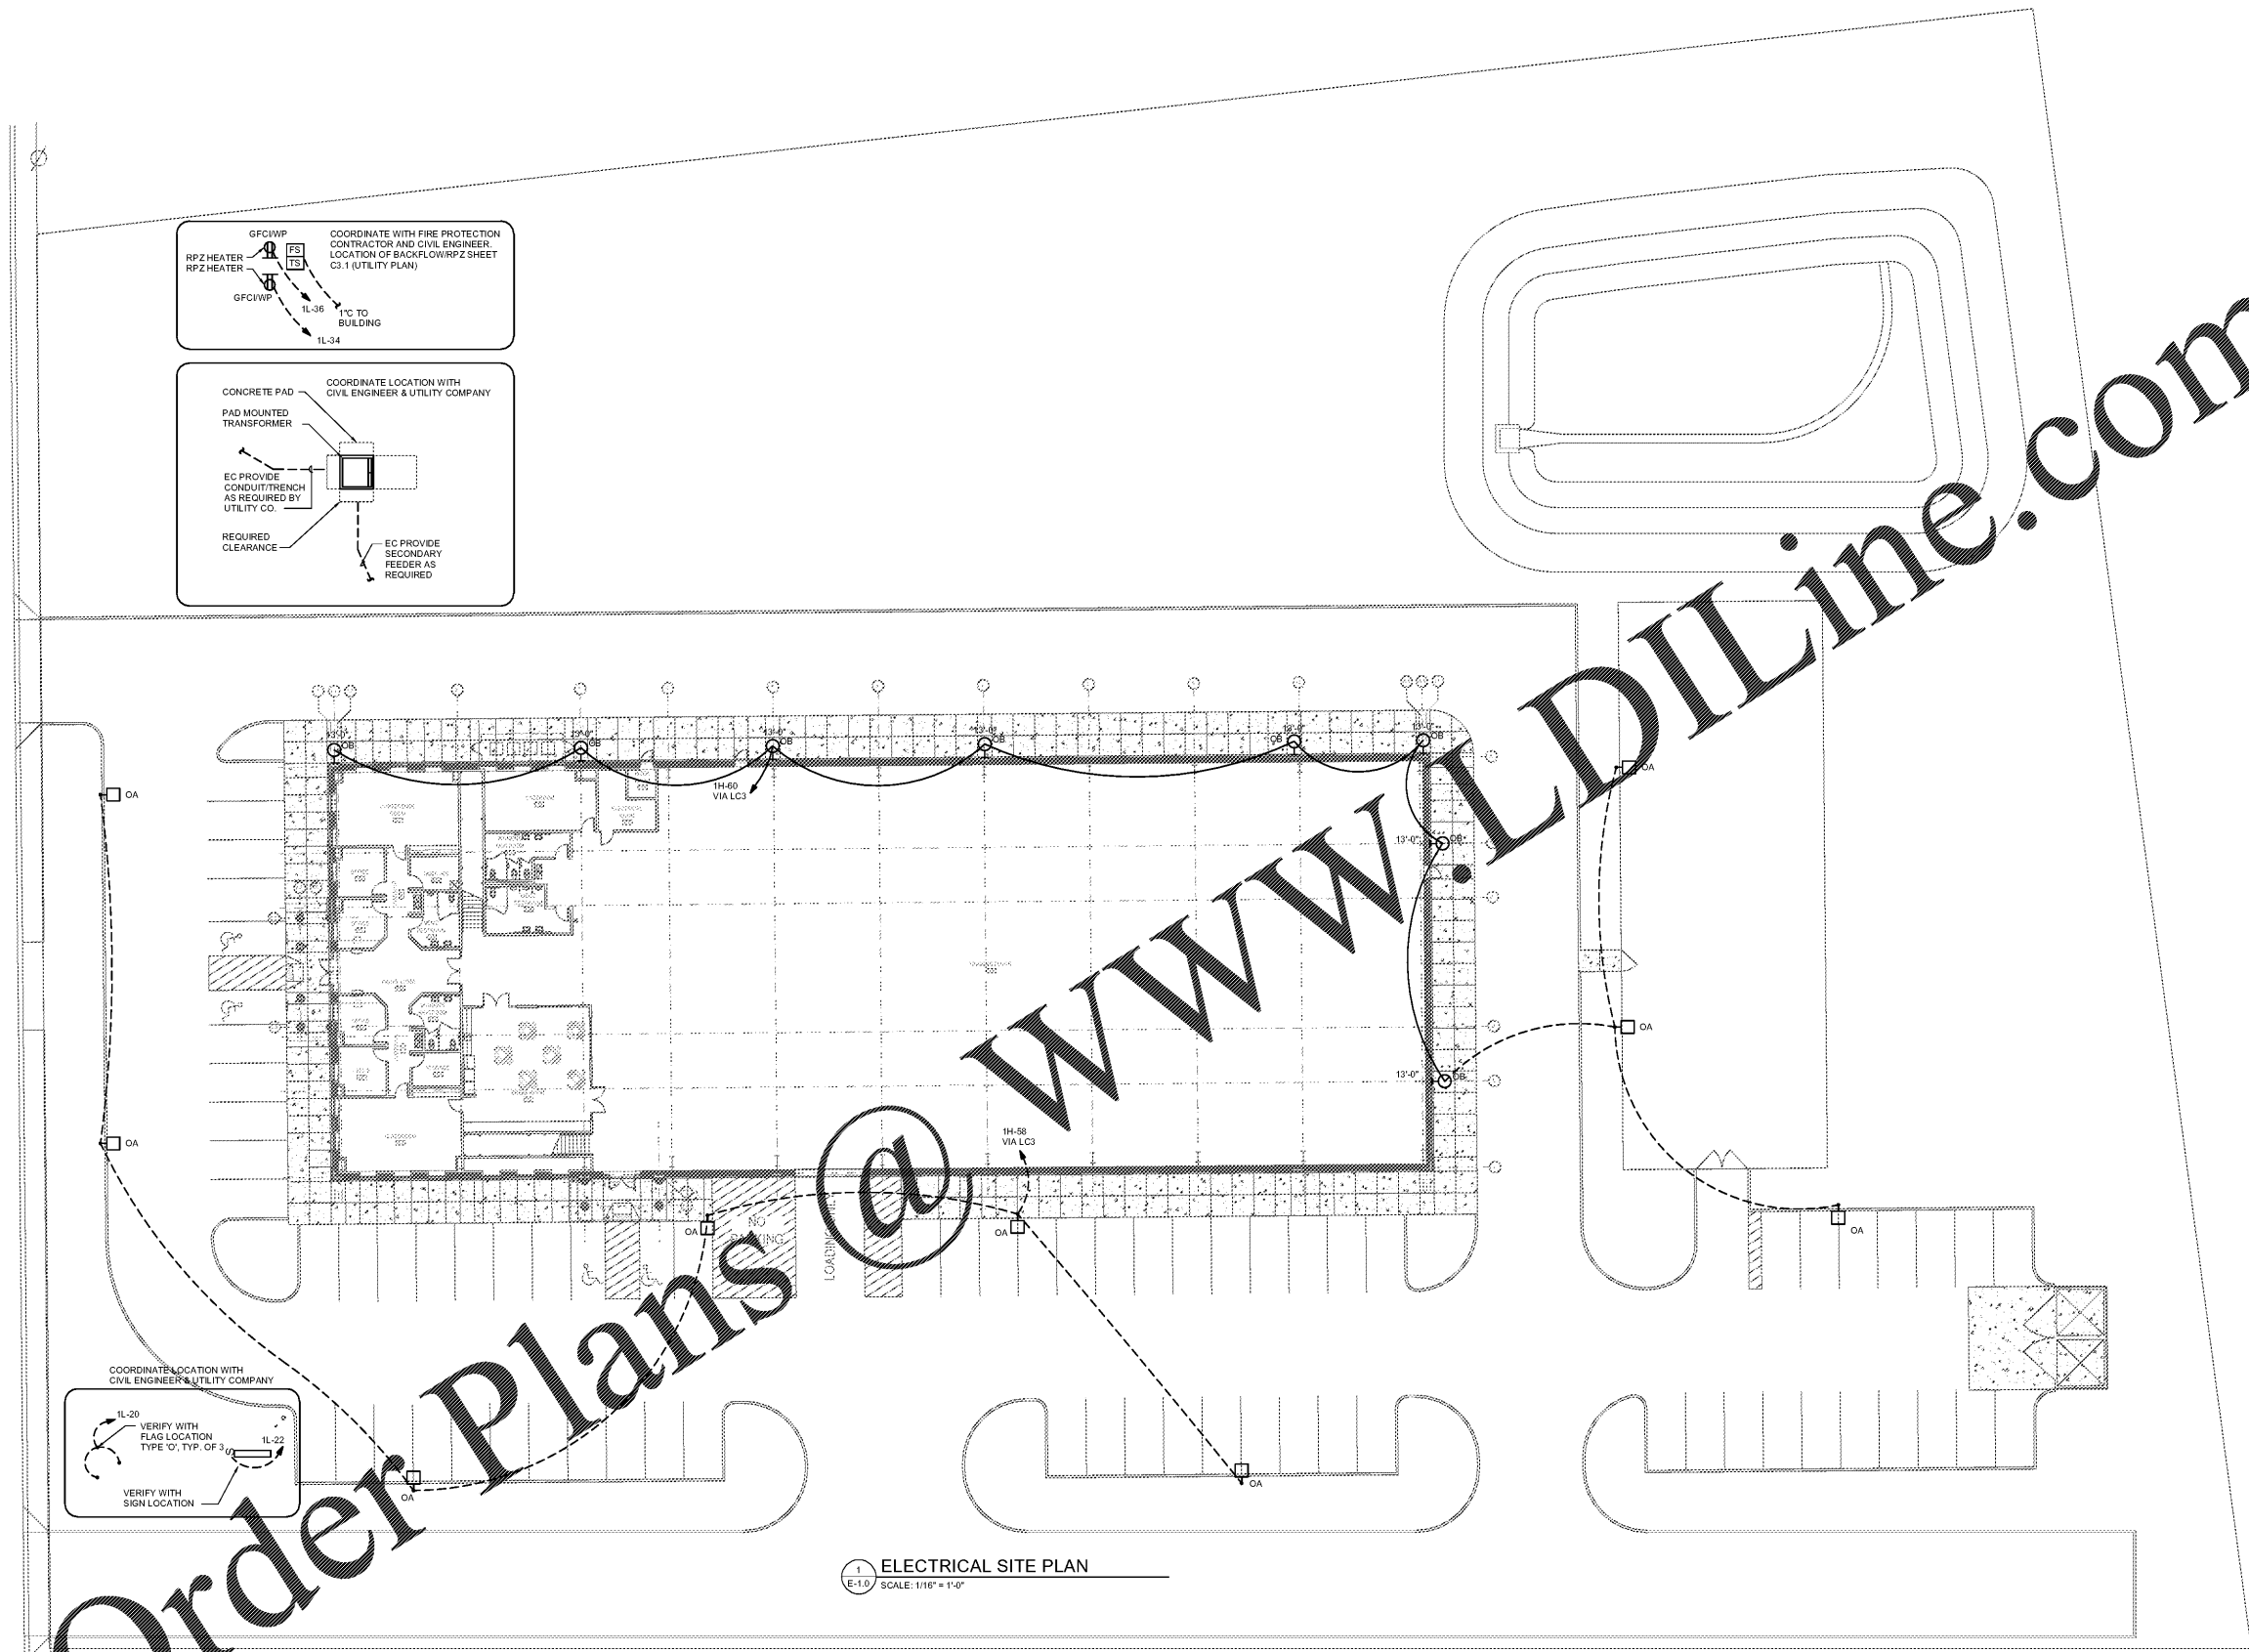

1 ELECTRICAL SITE PLAN
E-1.0 SCALE: 1/16" = 1'-0"

GENERAL NOTES

1. COORDINATE ELECTRICAL SITE WORK WITH CIVIL ENGINEER PRIOR TO ANY ROUGH IN WORK.
2. COORDINATE SITE LIGHTING POLE PLACEMENT WITH CIVIL ENGINEERING SITE LIGHTING PHOTOMETRIC PLAN PRIOR TO ANY ROUGH IN WORK.
3. COORDINATE SITE LIGHTING SPECIFICATIONS WITH CIVIL PHOTOMETRIC PLAN PRIOR TO ORDERING.
4. VERIFY UTILITY TRANSFORMER PLACEMENT WITH CIVIL ENGINEER AND UTILITY COMPANY PRIOR TO AND SITE WORK AND PROJECT STARTUP.



Order Plans @