


REGISTRATION SEAL

A NEW ADDITION TO
ROCKDALE COUNTY
ANIMAL CONTROL
 1506 ROCKBRIDGE ROAD, CONYERS, GA 30012

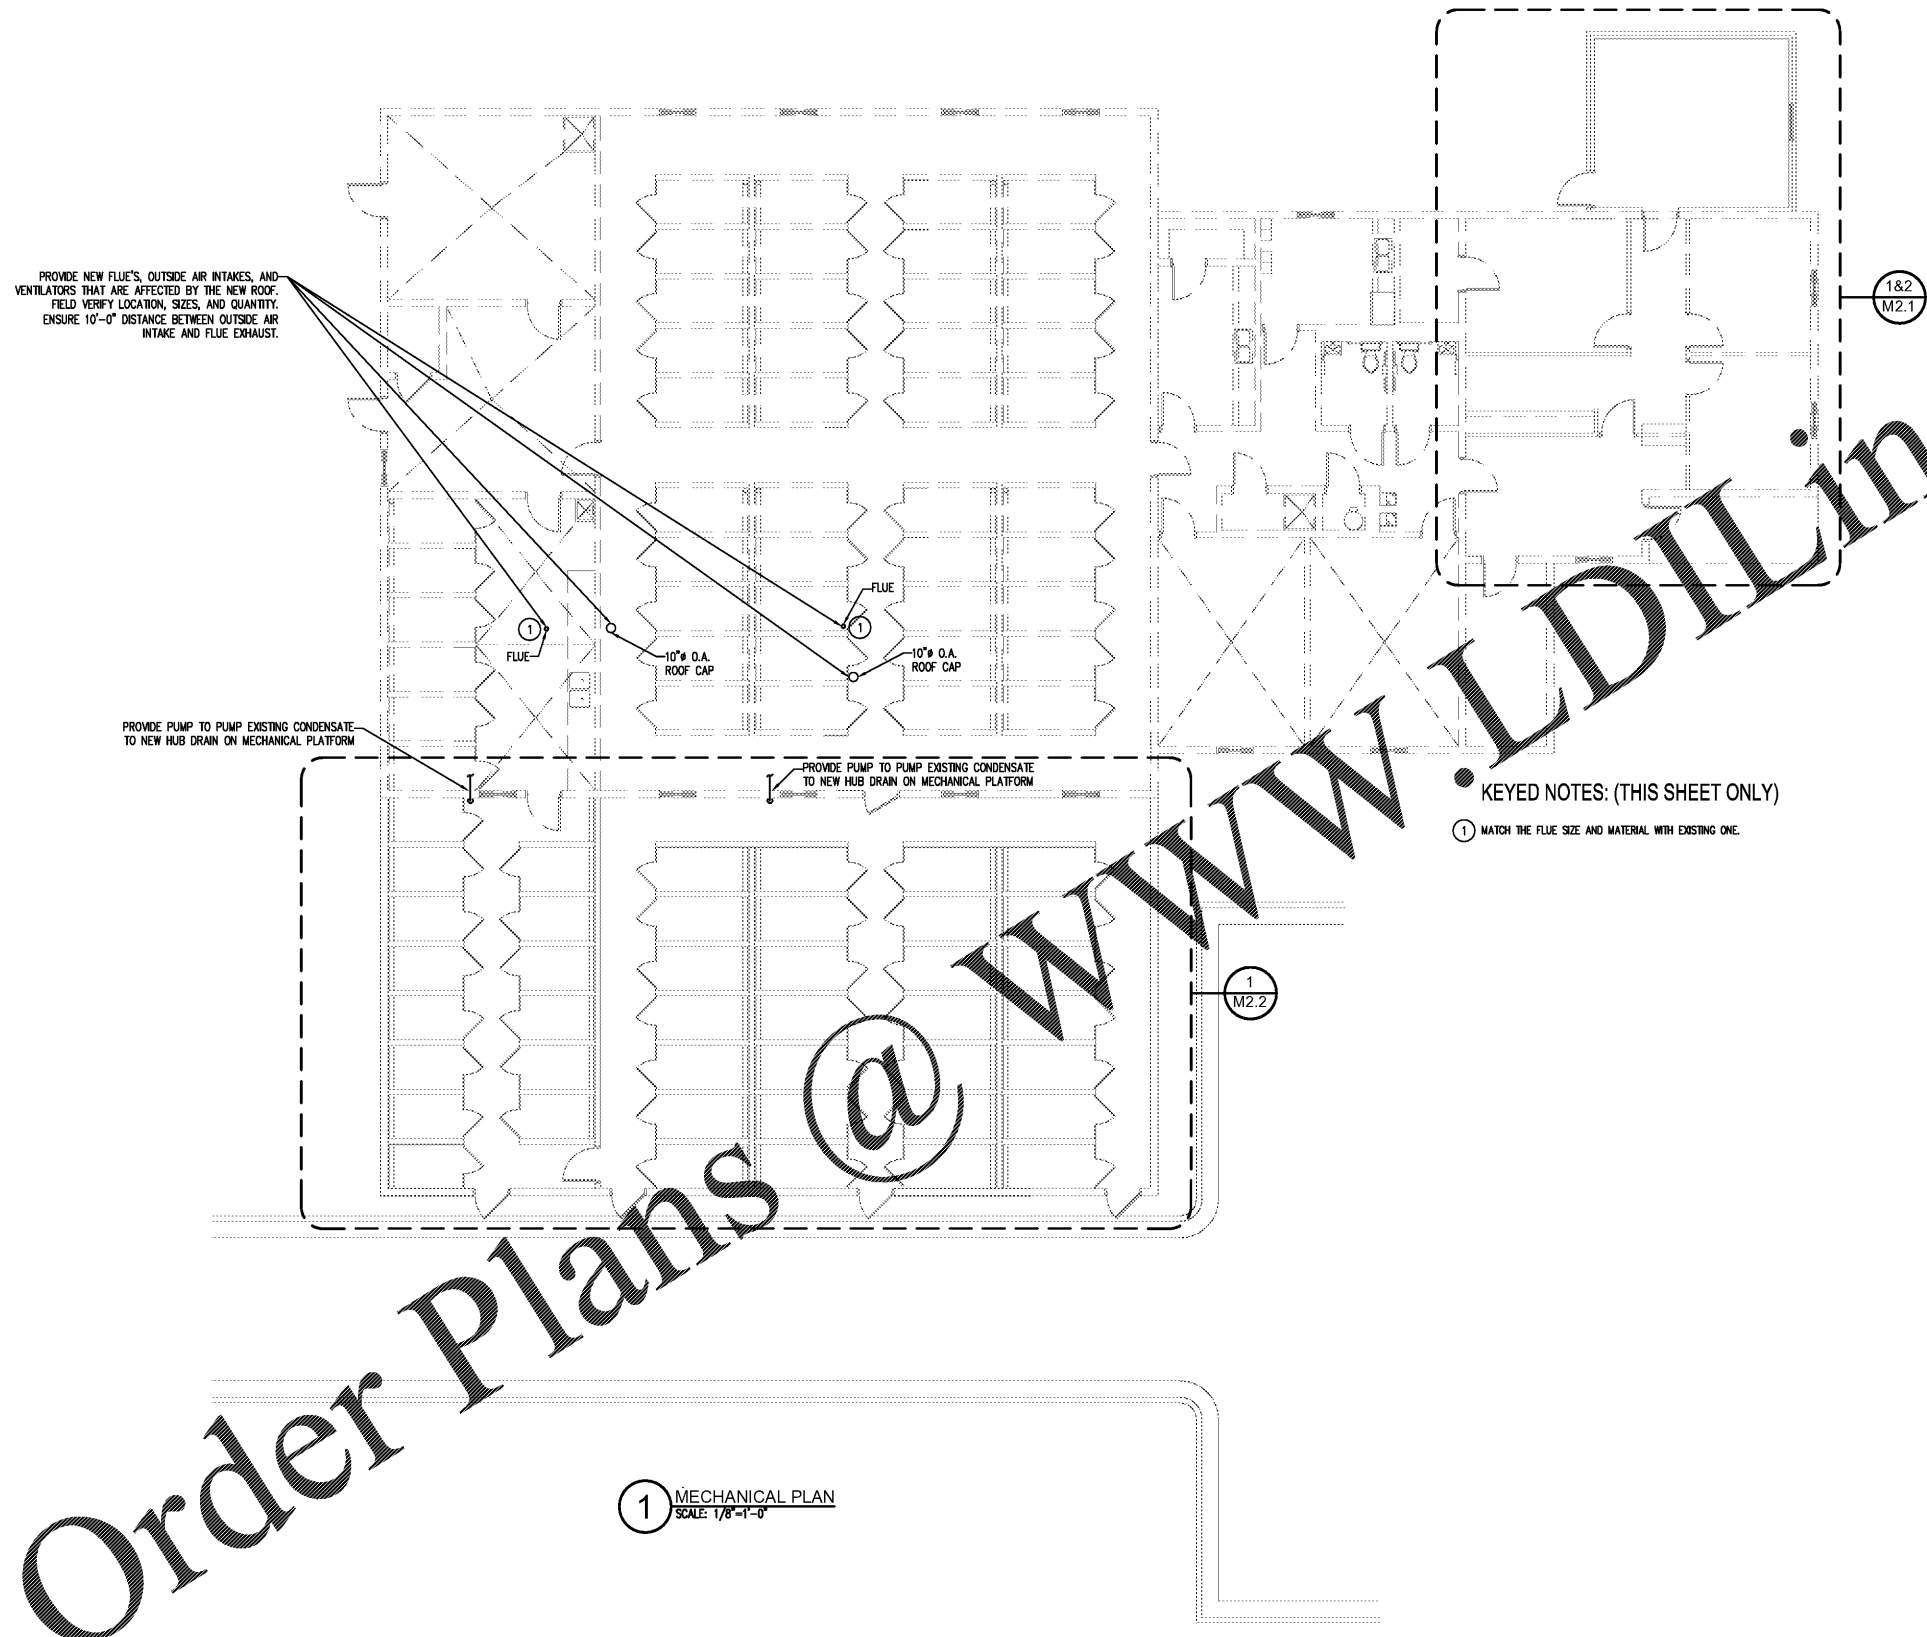

1 MECHANICAL PLAN
 SCALE: 1/8"=1'-0"

Order Plans @ WWW.LDILine.com

MARK	DATE	DESCRIPTION
△	12/17/19	KENNEL LOCATIONS

DATE: 11-01-18 PROJECT NUMBER: 18-059

DRAWN BY: JWK & KMP CHECK BY: KMP

SHEET TITLE:
 MECHANICAL PLAN

M1.1