



A NEW ADDITION TO  
**ROCKDALE COUNTY**  
**ANIMAL CONTROL**  
 1506 ROCKBRIDGE ROAD, CONYERS, GA 30012

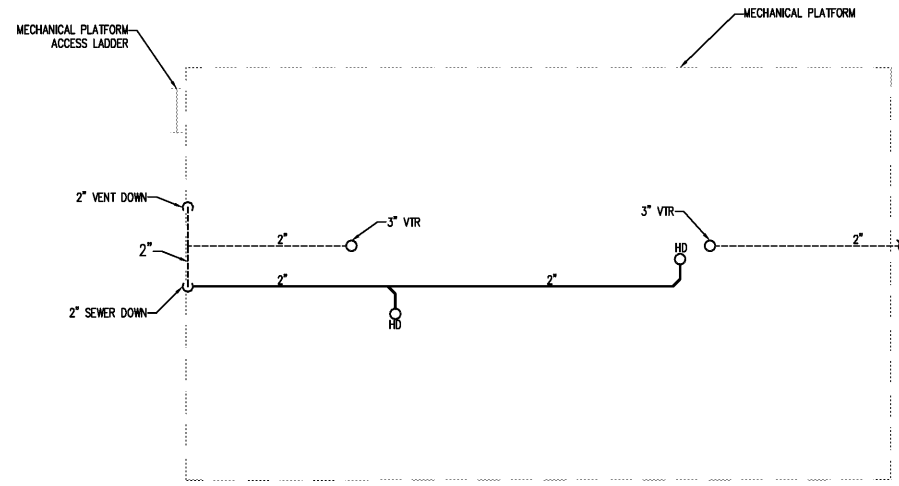

1 MECHANICAL PLATFORM PLUMBING PLAN  
 SCALE: 1/4"=1'-0"

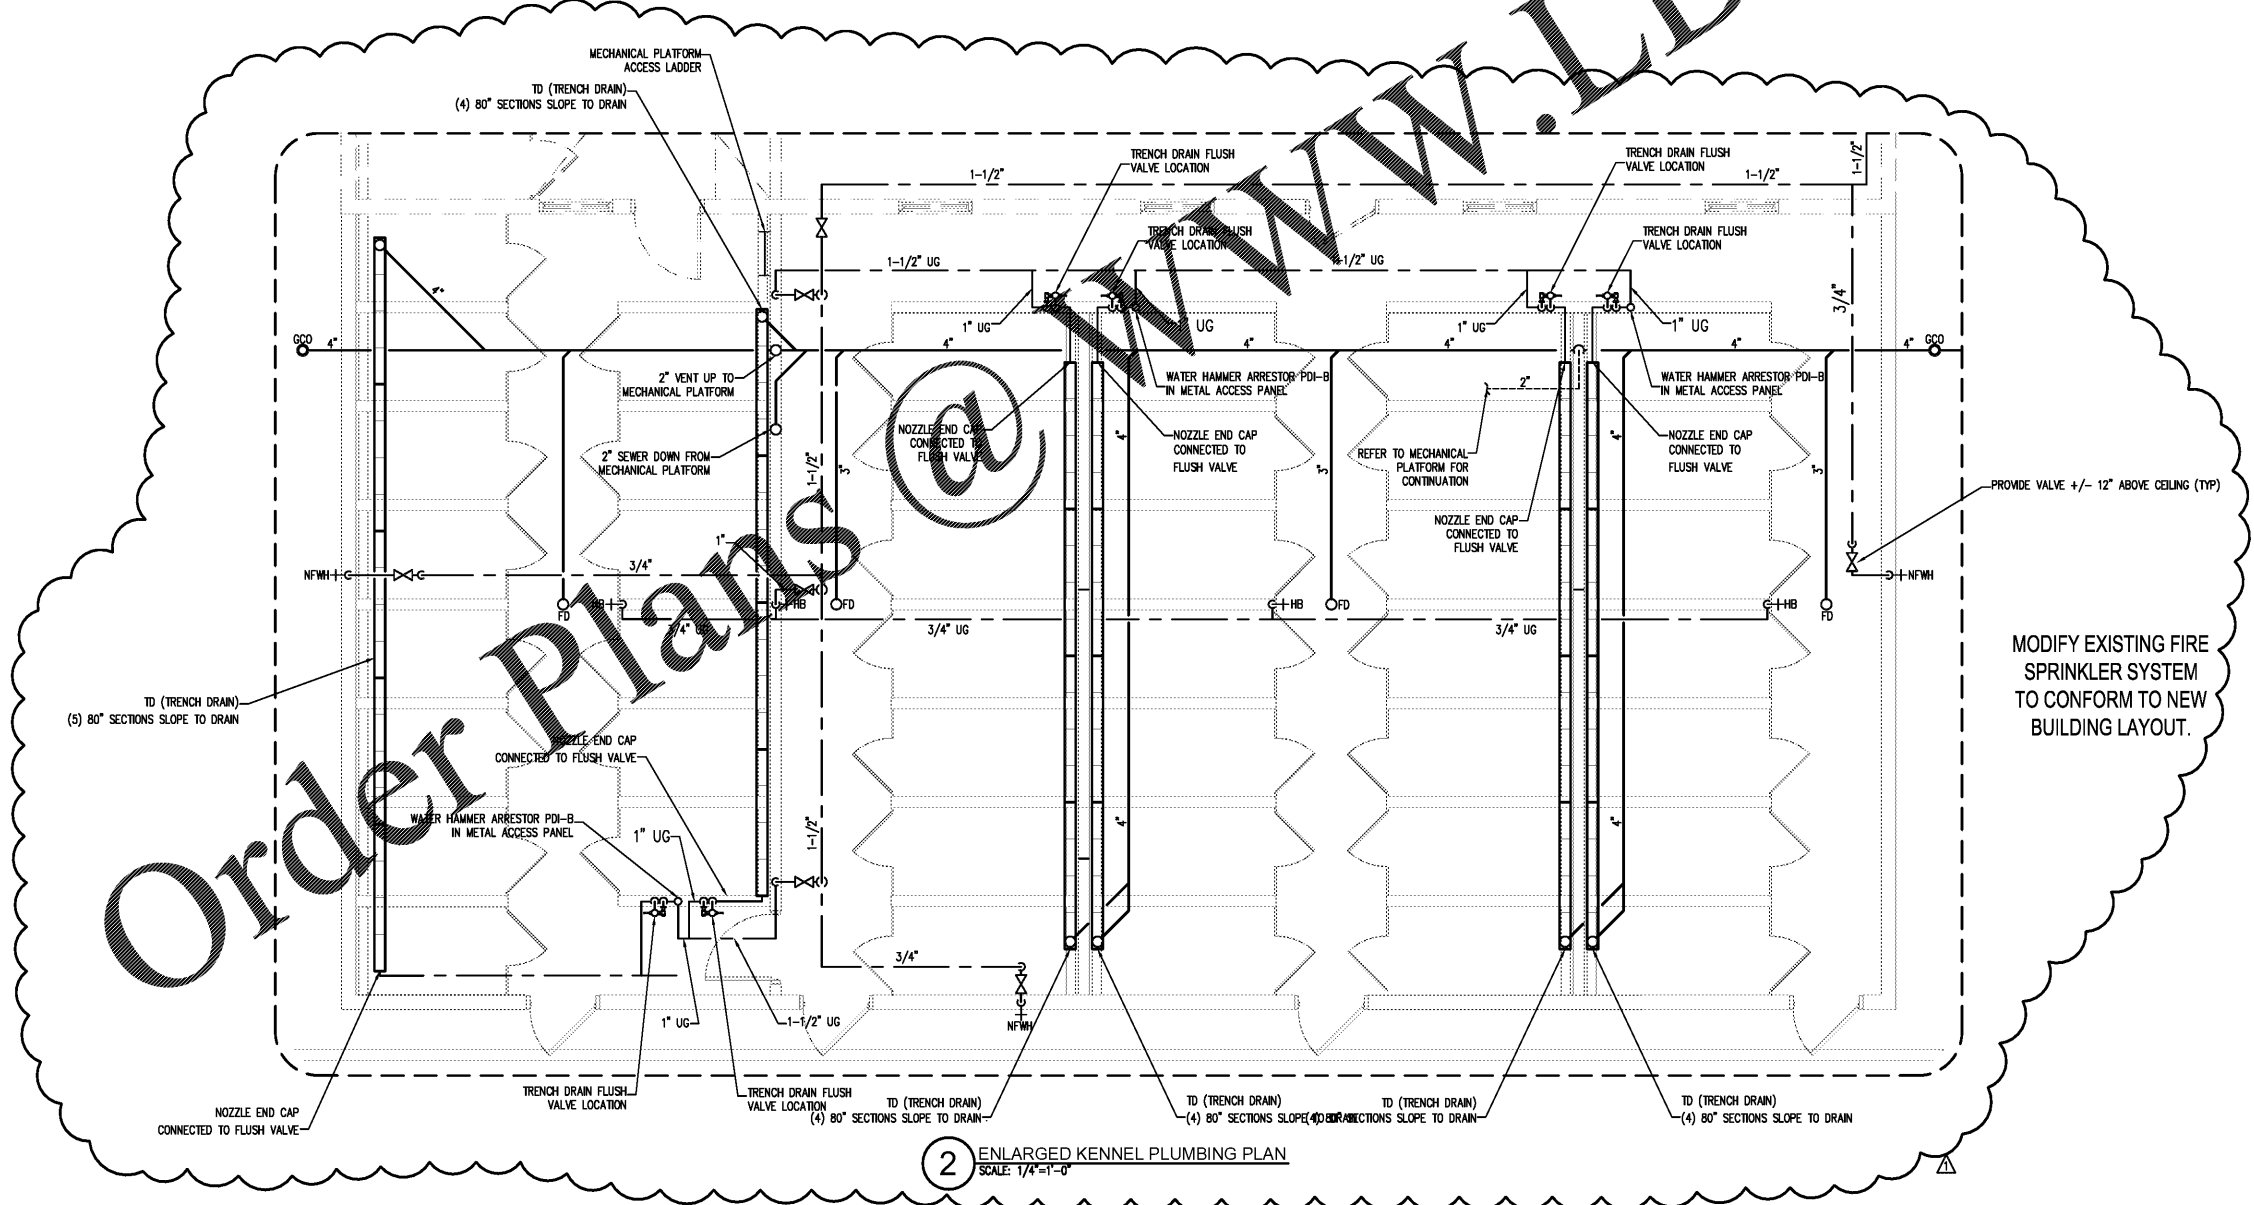

2 ENLARGED KENNEL PLUMBING PLAN  
 SCALE: 1/4"=1'-0"

Order Plans @ [www.LDILine.com](http://www.LDILine.com)

MARK	DATE	DESCRIPTION
△	12/17/19	KENNEL LOCATIONS

DATE: 11-01-18	PROJECT NUMBER: 18-059
DRAWN BY: JWK & KMP	CHECK BY: KMP

SHEET TITLE:  
 ENLARGED PLUMBING PLAN - KENNELS