
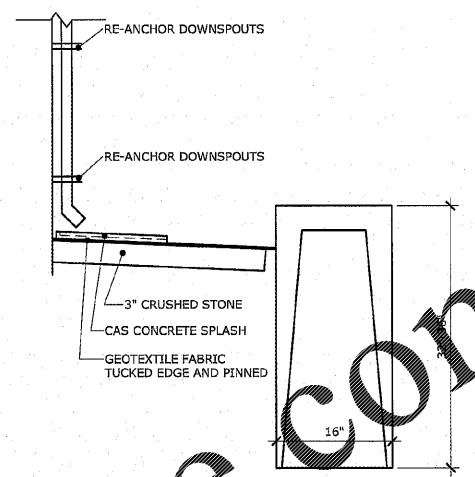


Z:\Archv..._Project\20-14 Terrace Manor ESD\DRAWINGS\CD Construction Documents\W\F\CD_SET.rvt
 PRINTED: 12/16/2020 8:56:55 AM

Order Plans @ www.LDILine.com

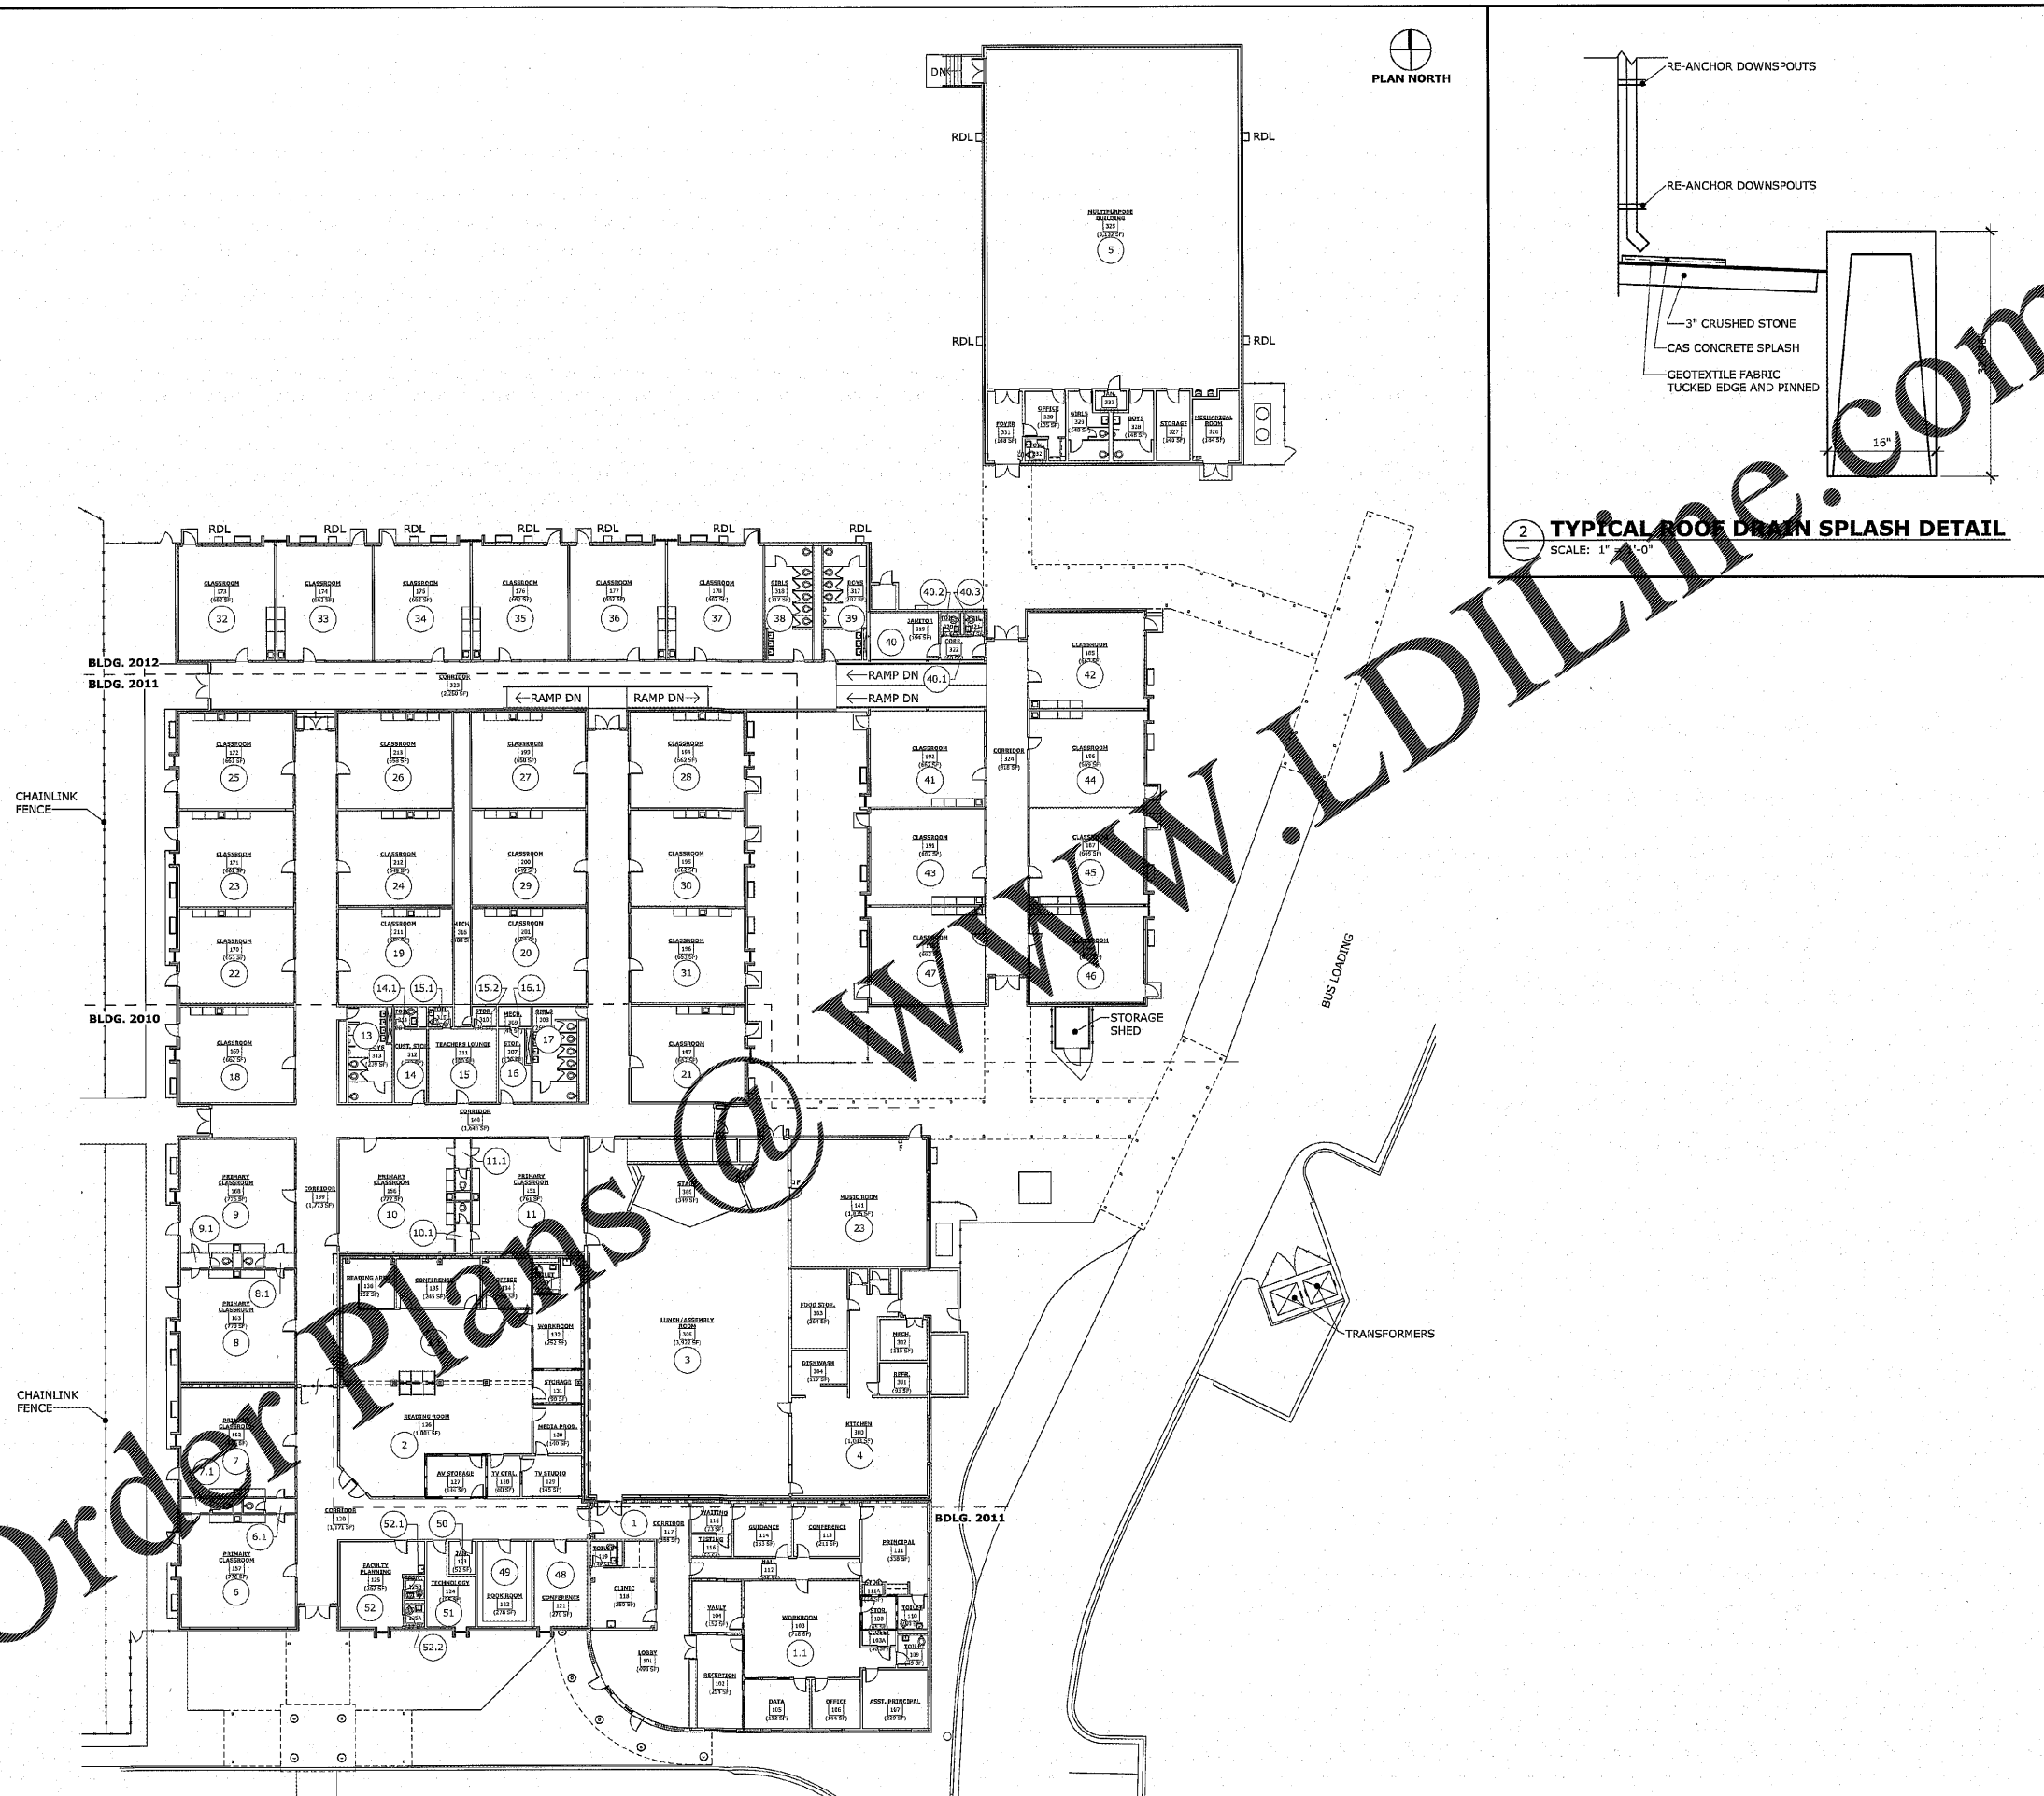


2 TYPICAL ROOF DRAIN SPLASH DETAIL
 SCALE: 1" = 1'-0"

2.K.M.
 ARCHITECTS, INC.
 526 GREENE ST., AUGUSTA, GA, 30901
 (706) 734-3333 - FAX (706) 734-7100

STATE OF GEORGIA
 ROBERT L. MAULDIN
 12/07/2020
 REGISTERED ARCHITECT
 CERTIFICATE No. 9999

This document is property of 2KM Architects, Inc. The unauthorized reproduction, copying, or otherwise use of this document is strictly prohibited and any infringement thereupon may be subject to legal action. Copyright © 2020, 2KM Architects, Inc.

- LEGEND:**
- 1-HOUR RATED
 - 2-HOUR RATED
 - 3-HOUR RATED
 - F.E.C. FIRE EXTINGUISHER, TYPE 'A'
 - F PULL STATION
 - 2 BOARD OF EDUCATION ROOM #
 - RDL ROOF DRAIN LEADER

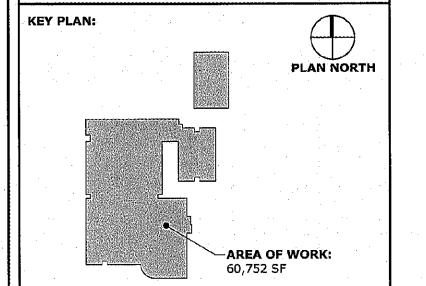

REVISIONS:

Date	Description

**TERRACE MANOR
 ELEMENTARY
 SCHOOL ROOF AND
 HVAC**

FOR
 RICHMOND COUNTY BOARD OF EDUCATION
 RCBOE # B-18-012-4330
 3110 TATE ROAD AUGUSTA, GA

DRAWING TITLE

REFERENCE PLAN

PROJECT NO. 20-14	DRAWING NO.
DATE 12/07/2020	GO.2
DRAWN BY RS	
PAPER 24"x36"	
ISSUE ISSUE FOR BID	

1 REFERENCE FLOOR PLAN
 SCALE: 1" = 20'-0"

SCALE: 1" = 20'-0"